


- KEY
- G - GLASS
 - T - TIMBER
 - G - GLASS
 - FAL - FIXED ALUMINIUM LOUVERS
 - FG - FIXED GLASS

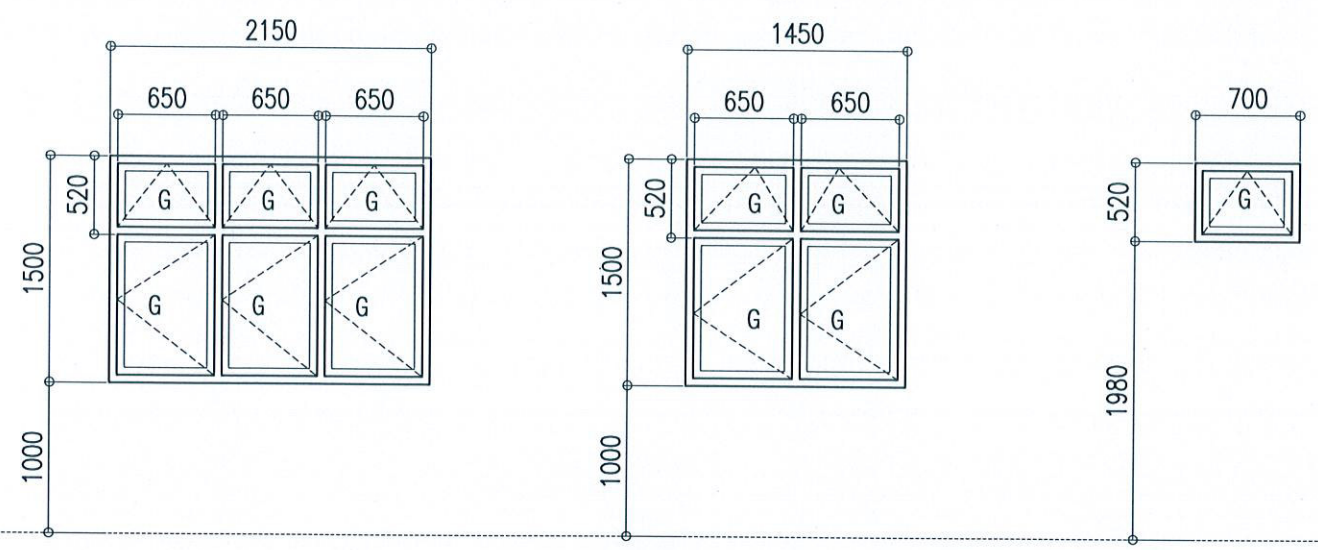


FIN FLOOR LVL

	W1	W2	W3
FRAME	ALUMINIUM	ALUMINIUM	ALUMINIUM
FINISHING	POWDER COAT	POWDER COAT	POWDER COAT
GLAZING	6MM THICK BLACK TINTED GLASS	6MM THICK BLACK TINTED GLASS	6MM THICK BLACK TINTED GLASS

DOOR AND WINDOW DETAILS
SCALE - 1:50

GROUND FLOOR	AIR CONDITIONED AREA
FIRST FLOOR	AIR CONDITIONED AREA
ALL TOILETS	MECHANICALLY VENTILATED

10 % VENTILATION SCHEDULE


 Ministry of Housing & Infrastructure
ACCREDITED CHECKER
STRUCTURAL CHECKER A1
 Name: Ashraf Hameed VALIDITY: 17.03.15 - 16.03.16
 Registration No: BPR2015006A1 A1-2015-006-001

REVISIONS:


PROJECT TITLE:
DHA. ATOLL COUNCIL

CLIENT :
LGA


ARCH. DESIGN:	SHAMIN	PROJECT NO	DHC-11/15
STRUC. DESIGN:	ASHRAF	DRAWING NO	A9
DATE :	MAY 2015		
SCALE:	AS GIVEN		


ALAAF PRIVATE LIMITED
 THARUHQE(GROUND FLOOR)BUDHERYA MAGUMALE'2004,
 TEL: (960)7773601, E-MAIL: alAAF.pvt@gmail.com, Web

COPYRIGHT: THE CONCEPT AND DESIGN IN THIS DRAWING ARE THE PROPERTIES OF ALAAF PVT. LTD. THIS DRAWING SHOULD BE USED ONLY FOR THE PROJECT MENTIONED ON THIS SHEET.

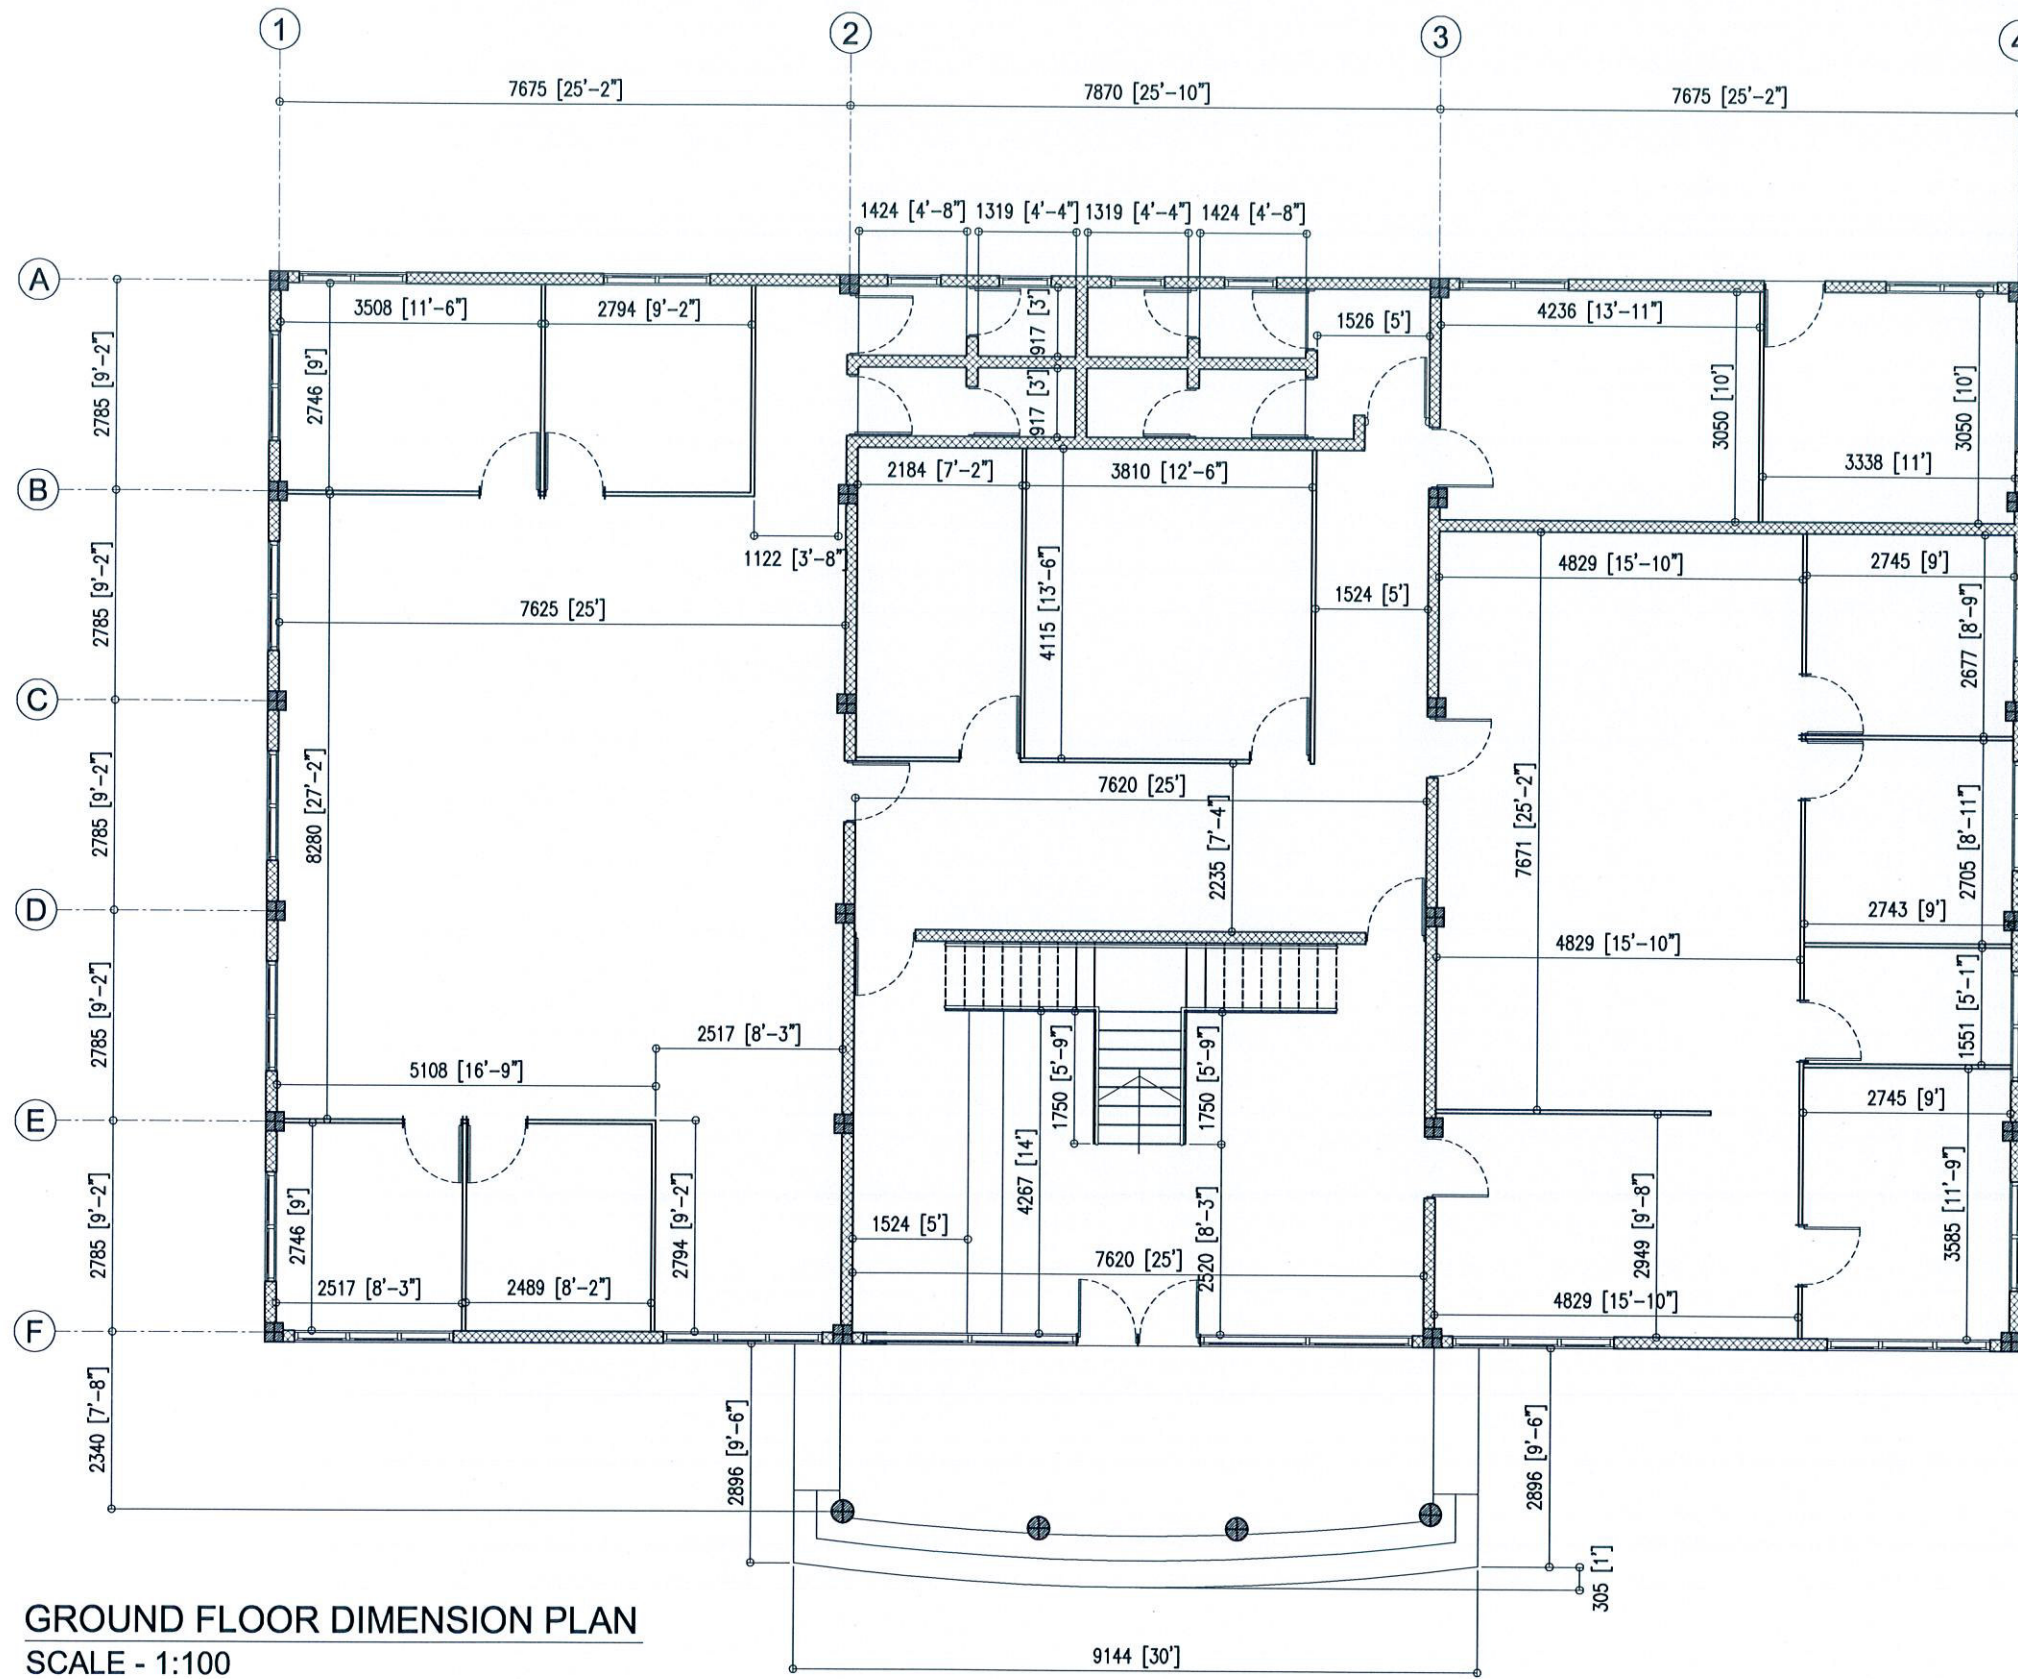

GROUND FLOOR DIMENSION PLAN
SCALE - 1:100


 Ministry of Housing & Infrastructure
ACCREDITED CHECKER
STRUCTURAL CHECKER A1
 Name: Ashraf Hameed VALIDITY: 17.03.15 - 16.03.16
 Registration No: BPR2015006A1 A1-2015-006-001

REVISIONS:


PROJECT TITLE:
DHA. ATOLL COUNCIL

CLIENT:
LGA


ARCH. DESIGN:	SHAMIN	PROJECT NO	DHC-11/15
STRUC. DESIGN:	ASHRAF	DRAWING NO	A10
DATE:	MAY 2015		
SCALE:	AS GIVEN		



ALAAF PRIVATE LIMITED
 THARUHQE(GROUND FLOOR)SABUDHERYA MAGUWALE'2004,
 TEL: (960)7773801, E-MAIL: alAAF.pvt@gmail.com, Web

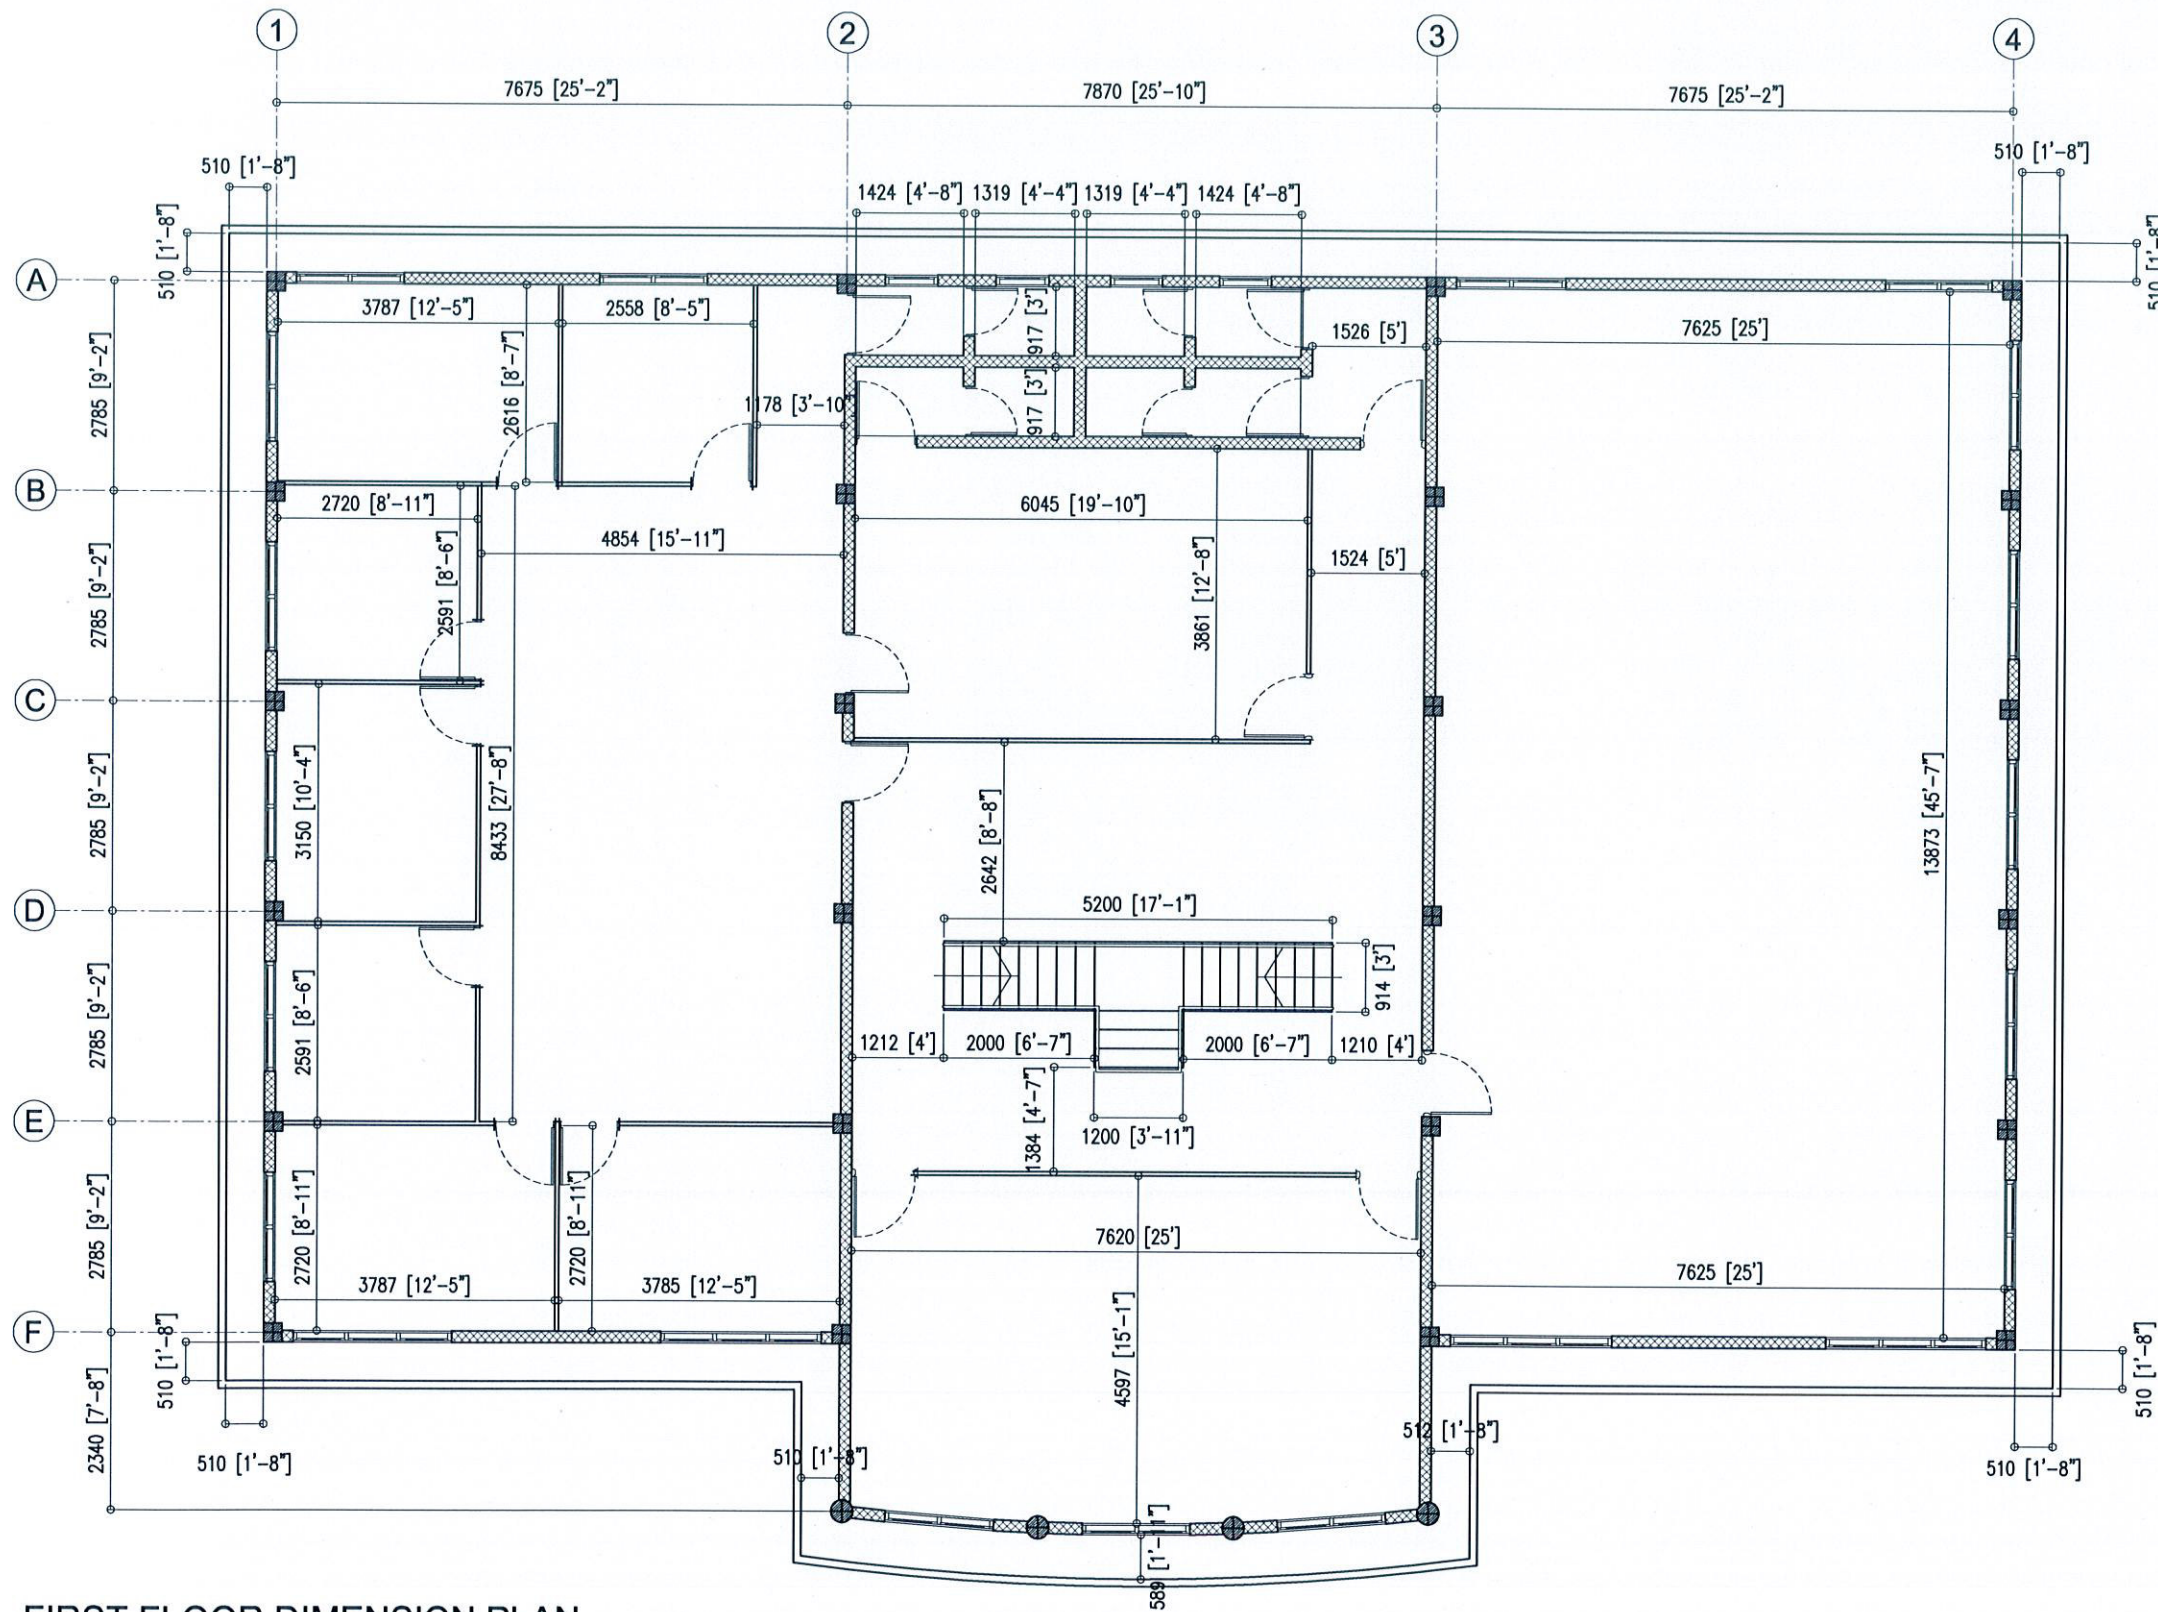COPYRIGHT: THE CONCEPT AND DESIGN IN THIS DRAWING ARE THE PROPERTIES OF ALAAF PVT LTD. THIS DRAWING SHOULD BE USED ONLY FOR THE PROJECT MENTIONED ON THIS SHEET.




FIRST FLOOR DIMENSION PLAN
SCALE - 1:100


 Ministry of Housing & Infrastructure
ACCREDITED CHECKER
STRUCTURAL CHECKER A1
 Name: Ashraf Hameed VALIDITY: 17.03.15 - 16.03.16
 Registration No: BPR2015006A1 A1-2015-006-001

REVISIONS:		
PROJECT TITLE: DHA. ATOLL COUNCIL		
CLIENT: LGA		
ARCH. DESIGN:	SHAMIN	PROJECT NO DHC-11/15
STRUC. DESIGN:	ASHRAF	DRAWING NO A11
DATE:	MAY 2015	
SCALE:	AS GIVEN	
 ALAAF <small>ALAAF PRIVATE LIMITED THARUWHE(GROUND FLOOR)BUDHERYA MAGUMALE'2004, TEL: (960)7773801, E-MAIL: alAAF.pvt@gmail.com, Web</small>		

COPYRIGHT: THE CONCEPT AND DESIGN IN THIS DRAWING ARE THE PROPERTIES OF ALAAF PVT. LTD. THIS DRAWING SHOULD BE USED ONLY FOR THE PROJECT MENTIONED ON THIS SHEET.

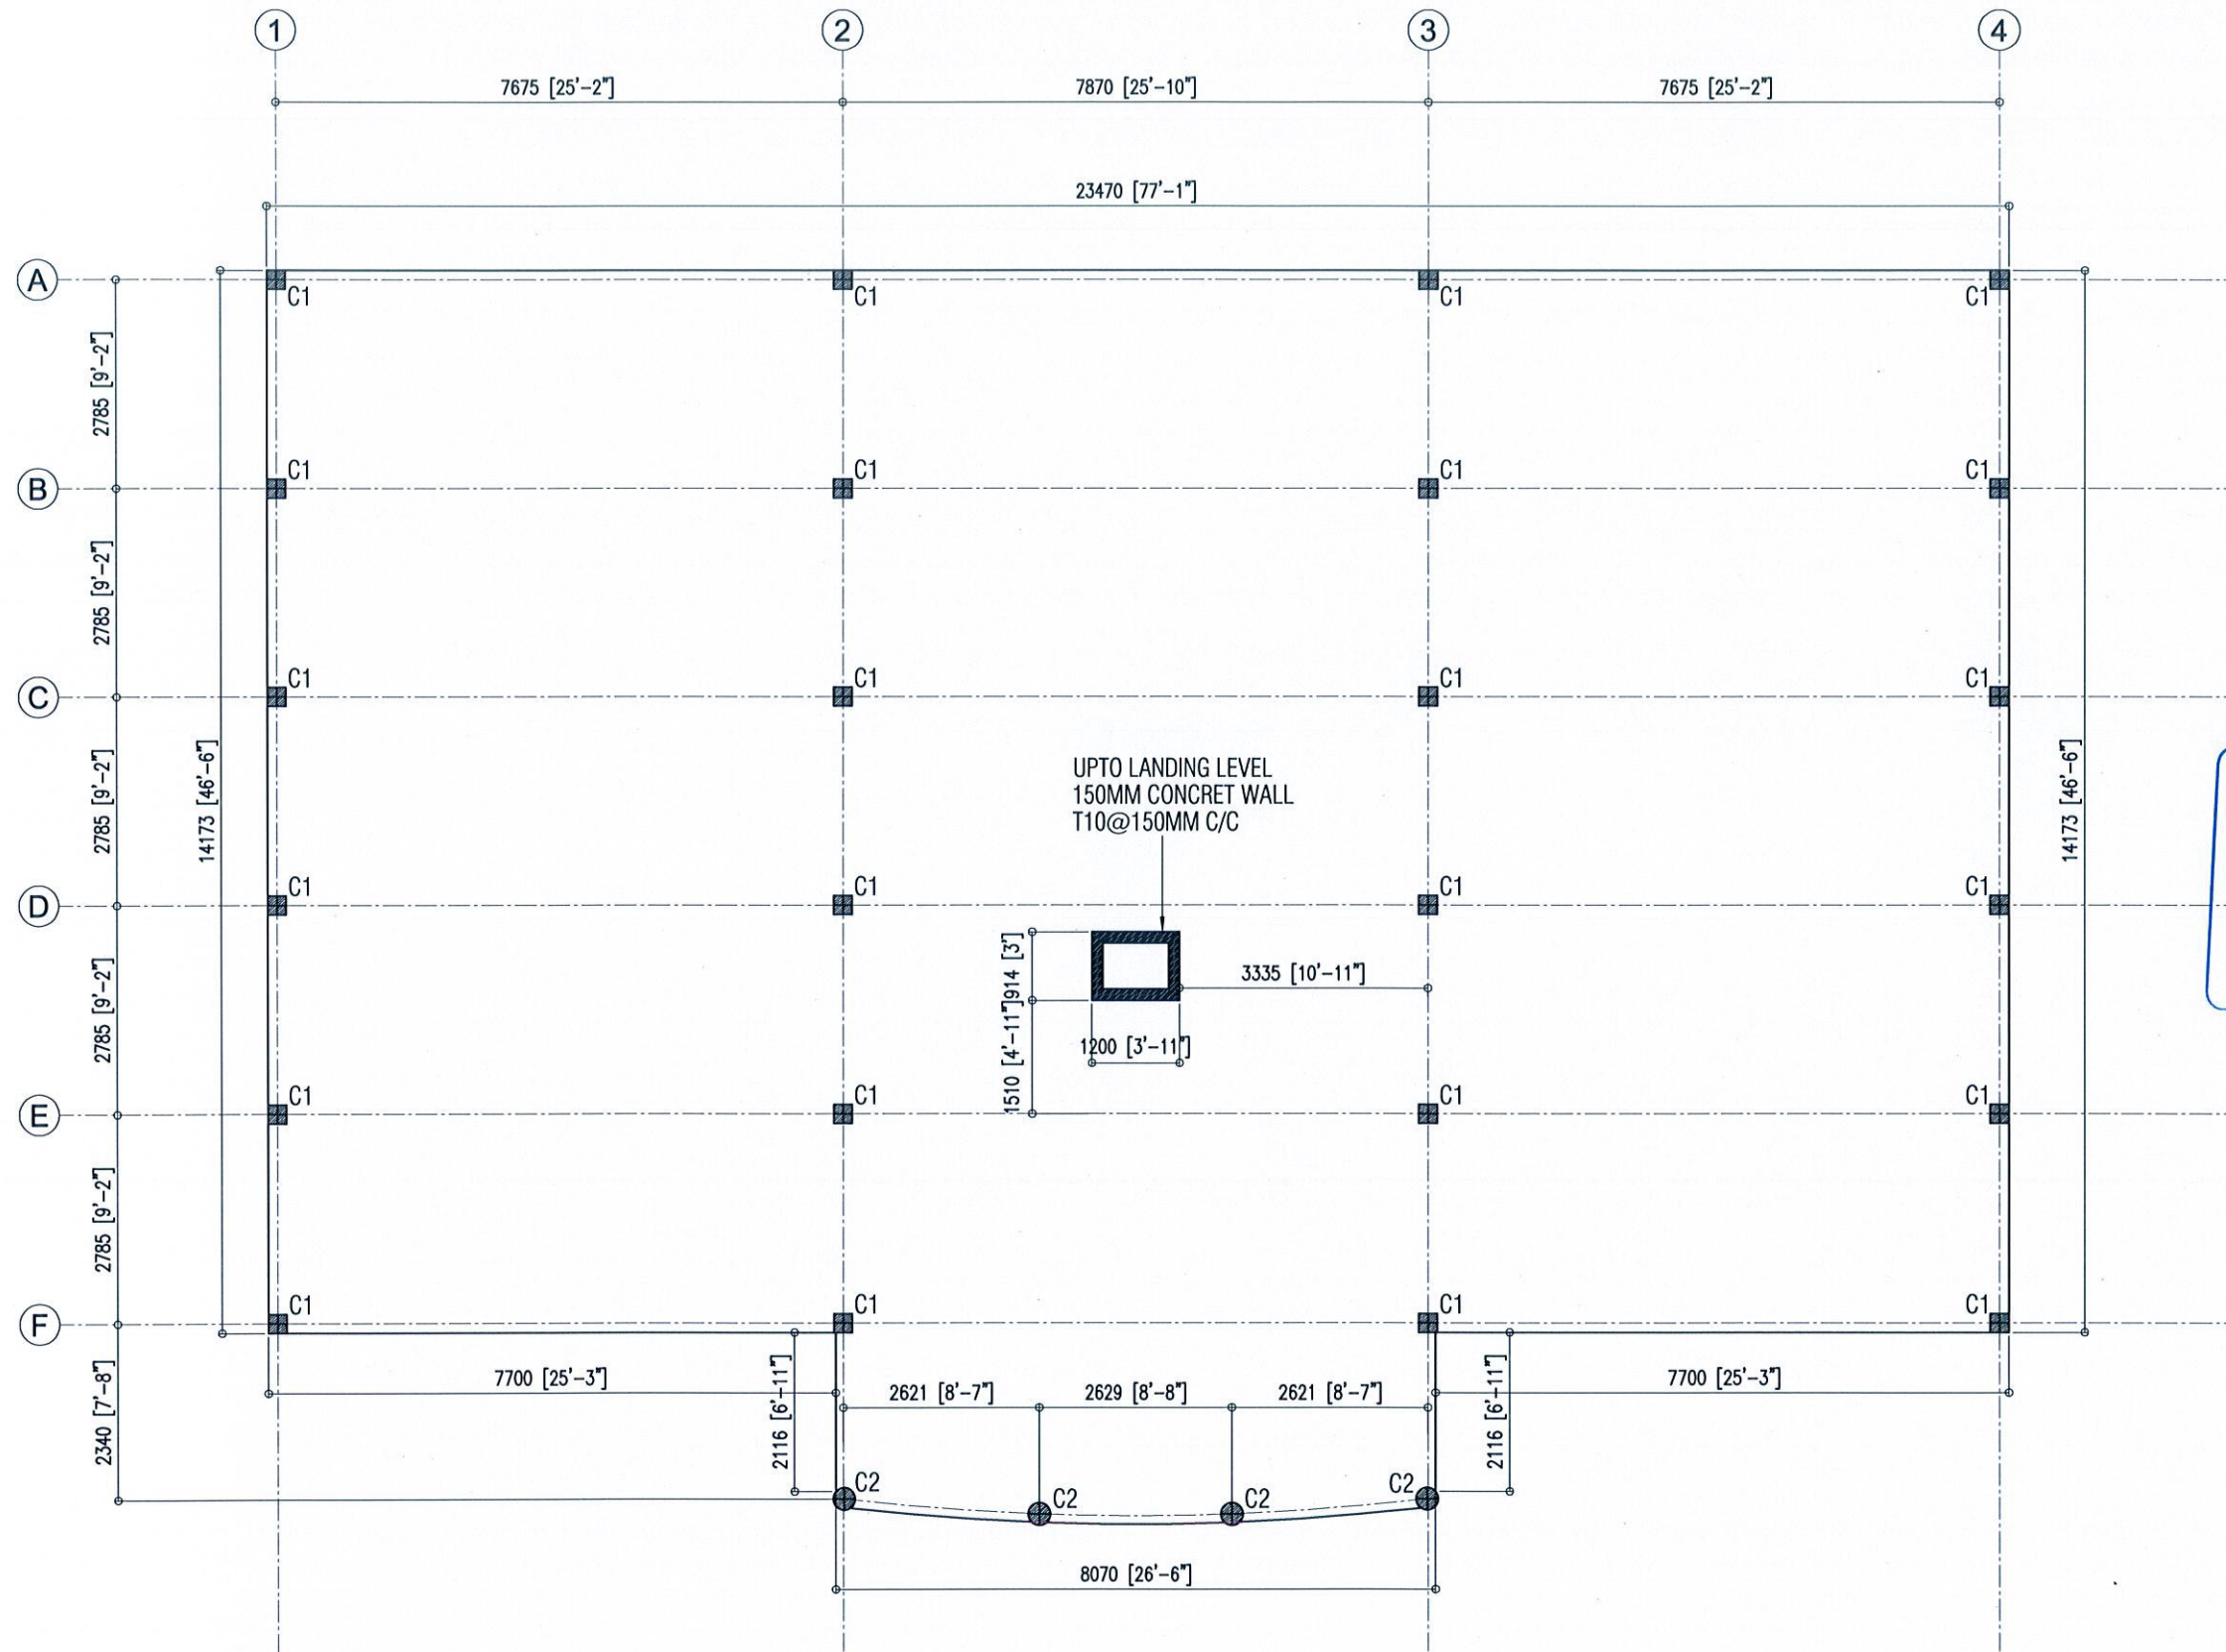

Ministry of Housing & Infrastructure
ACCREDITED CHECKER
 STRUCTURAL CHECKER A1
 Name: Ashraf Hameed VALIDITY: 17.03.15 - 16.03.16
 Registration No: BPR2015006A1 A1-2015-006-001

REVISIONS:

PROJECT TITLE:
DHA. ATOLL COUNCIL


CLIENT:
 LGA


ARCH. DESIGN:	SHAMIN	PROJECT NO	DHC-11/15
STRUC. DESIGN:	ASHRAF	DRAWING NO	S1
DATE:	MAY 2015		
SCALE:	AS GIVEN		

ALAAF
 ALAAF PRIVATE LIMITED
 THARUENHIGE(GROUND FLR)SABUDHERYA MAGUMALE20004,
 TEL: (990)7773601, E-MAIL: alAAF.pvt@gmail.com,Web


COLUMN SETTING OUT PLAN
 SCALE - 1:100

COPYRIGHT: THE CONCEPT AND DESIGN IN THIS DRAWING ARE THE PROPERTIES OF ALAAF PVT. LTD. THIS DRAWING SHOULD BE USED ONLY FOR THE PROJECT MENTIONED ON THIS SHEET.

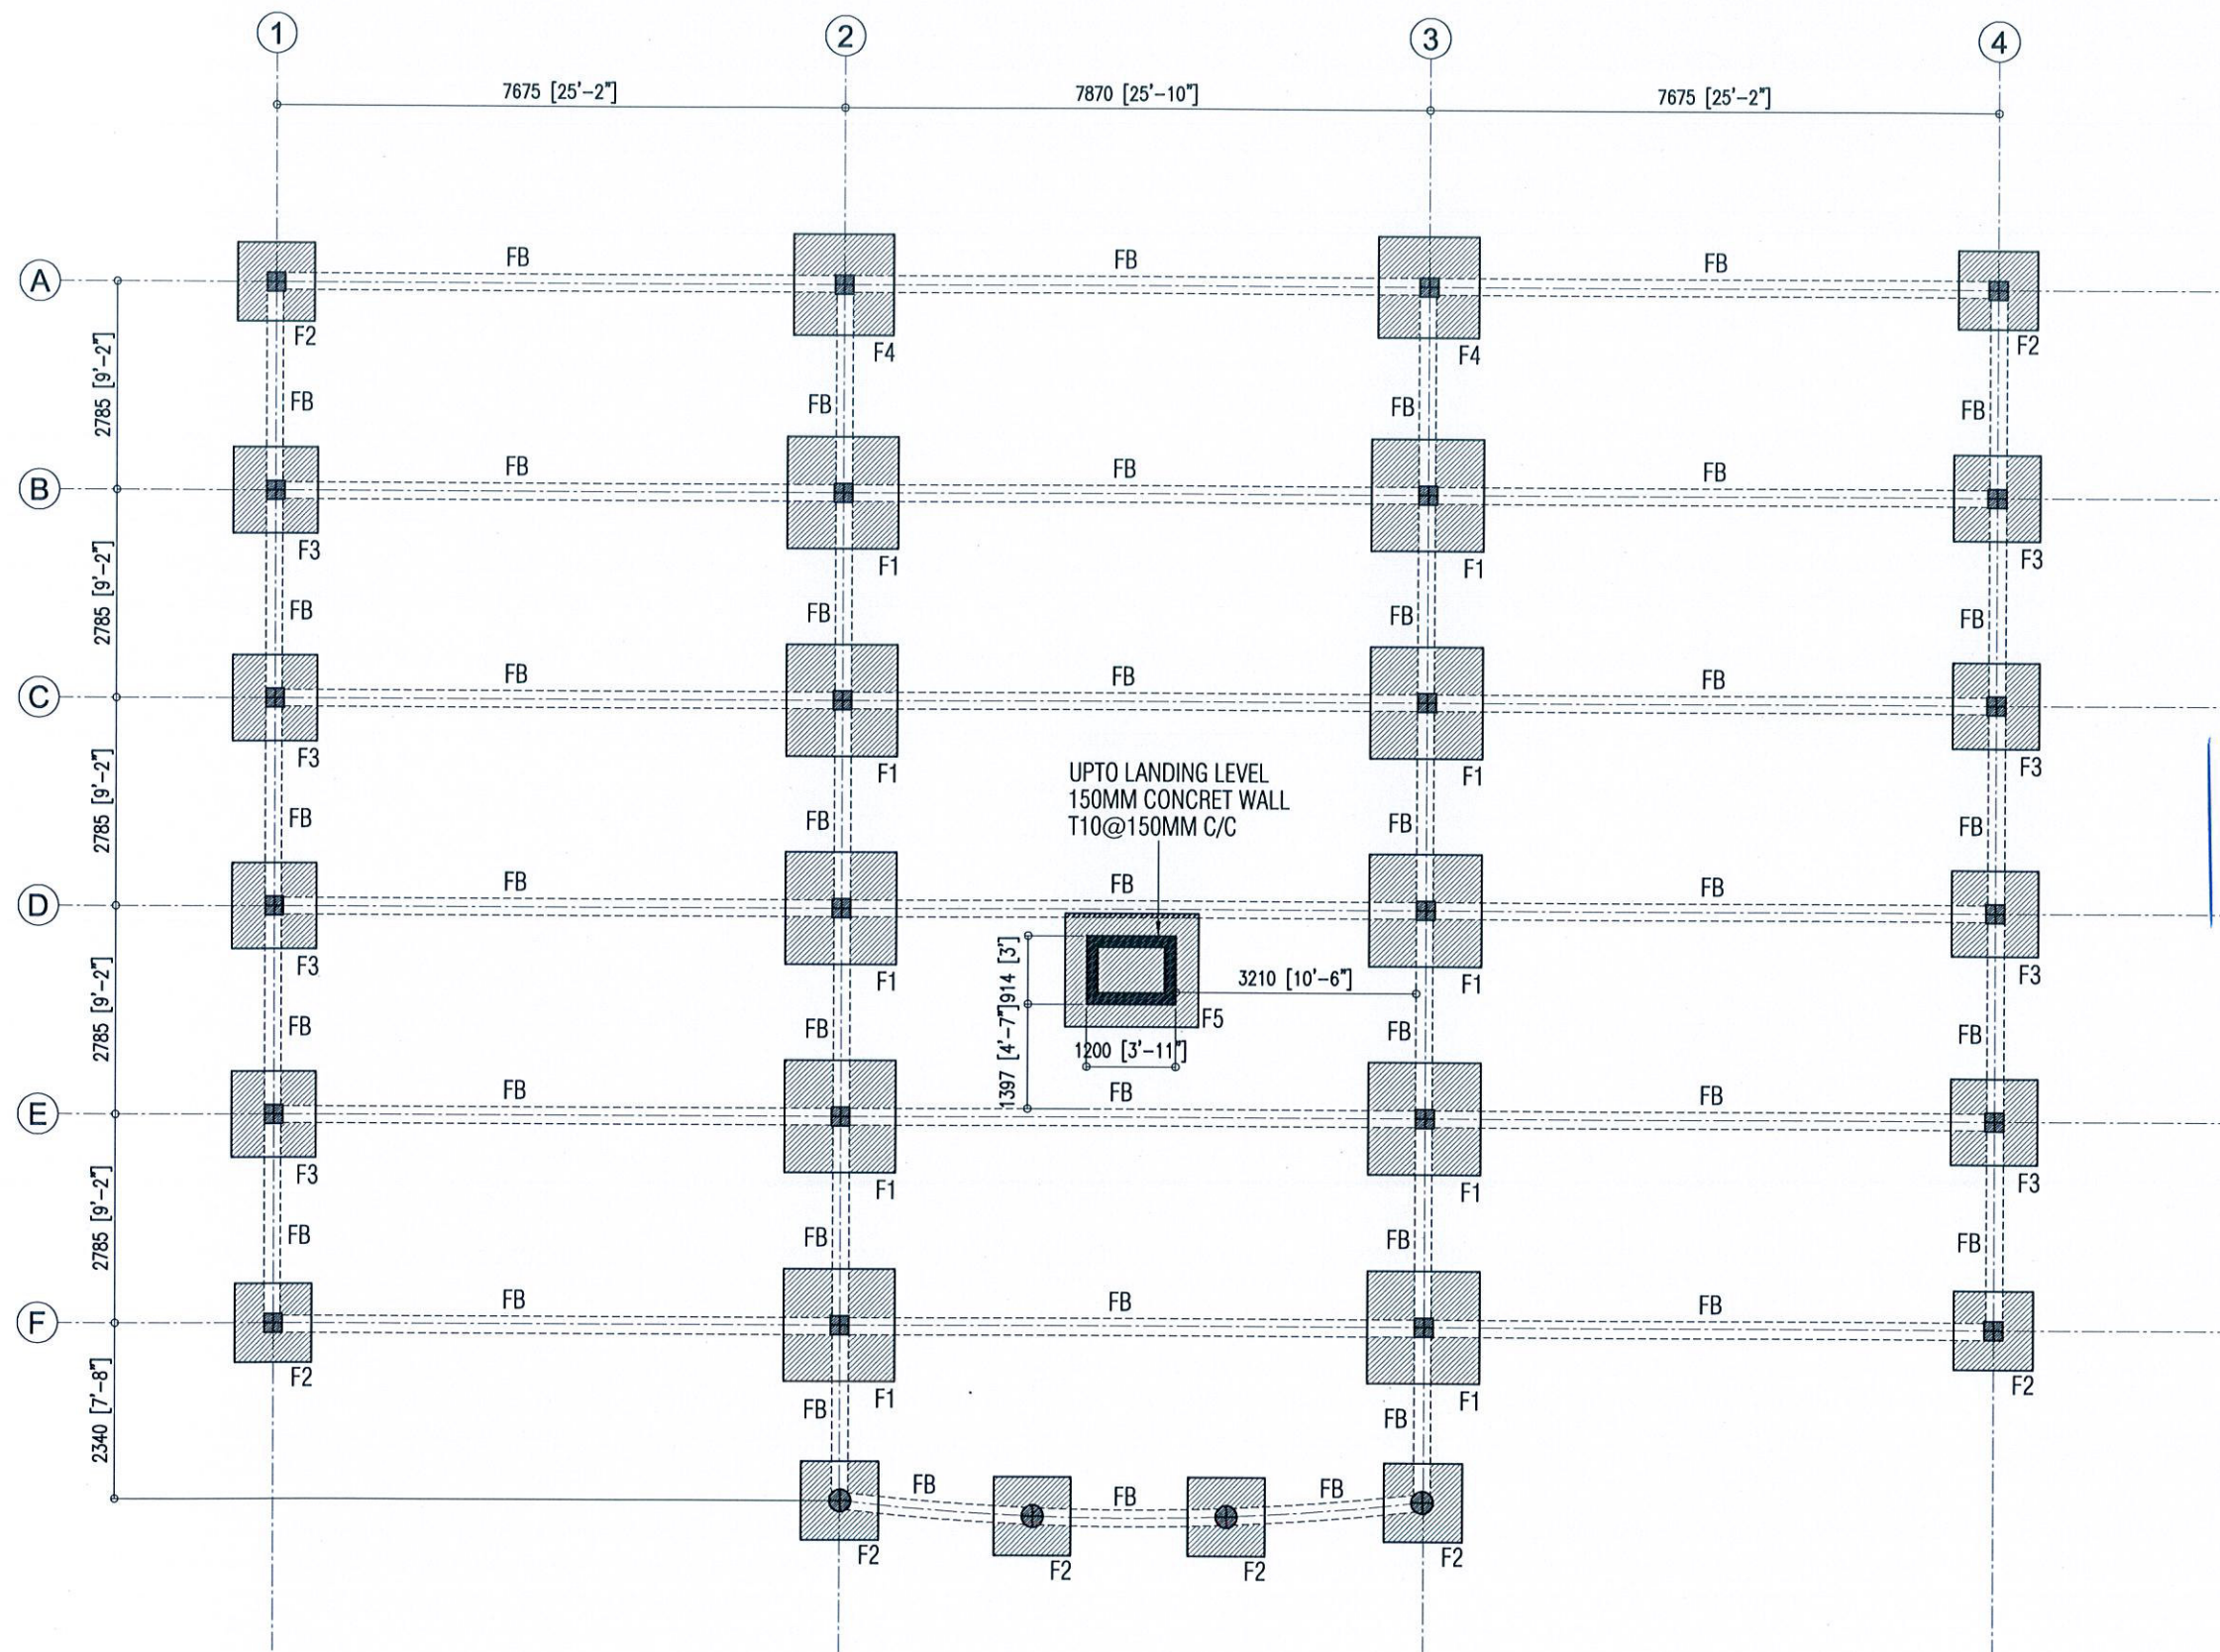



 Ministry of Housing & Infrastructure
ACCREDITED CHECKER
STRUCTURAL CHECKER A1
 Name: Ashraf Hameed VALIDITY: 17.03.15 - 16.03.16
 Registration No: BPR2015006A1 A1-2015-006-001

FOUNDATION PLAN
SCALE - 1:100

REVISIONS:		
PROJECT TITLE:		
DHA. ATOLL COUNCIL		
CLIENT :		
LGA		
ARCH. DESIGN:	SHAMIN	PROJECT NO
STRUC. DESIGN:	ASHRAF	DHC-11/15
DATE :	MAY 2015	DRAWING NO
SCALE:	AS GIVEN	S2
 <small>ALAAF PRIVATE LIMITED THARUWEGE(GROUND FLOOR)SABURHERIYA MAGUMALE'2004, TEL: (960)7773001, E-MAIL: alAAF.pvt@gmail.com, Web</small>		

COPYRIGHT: THE CONCEPT AND DESIGN IN THIS DRAWING ARE THE PROPERTIES OF ALAAF PVT. LTD. THIS DRAWING SHOULD BE USED ONLY FOR THE PROJECT MENTIONED ON THIS SHEET.

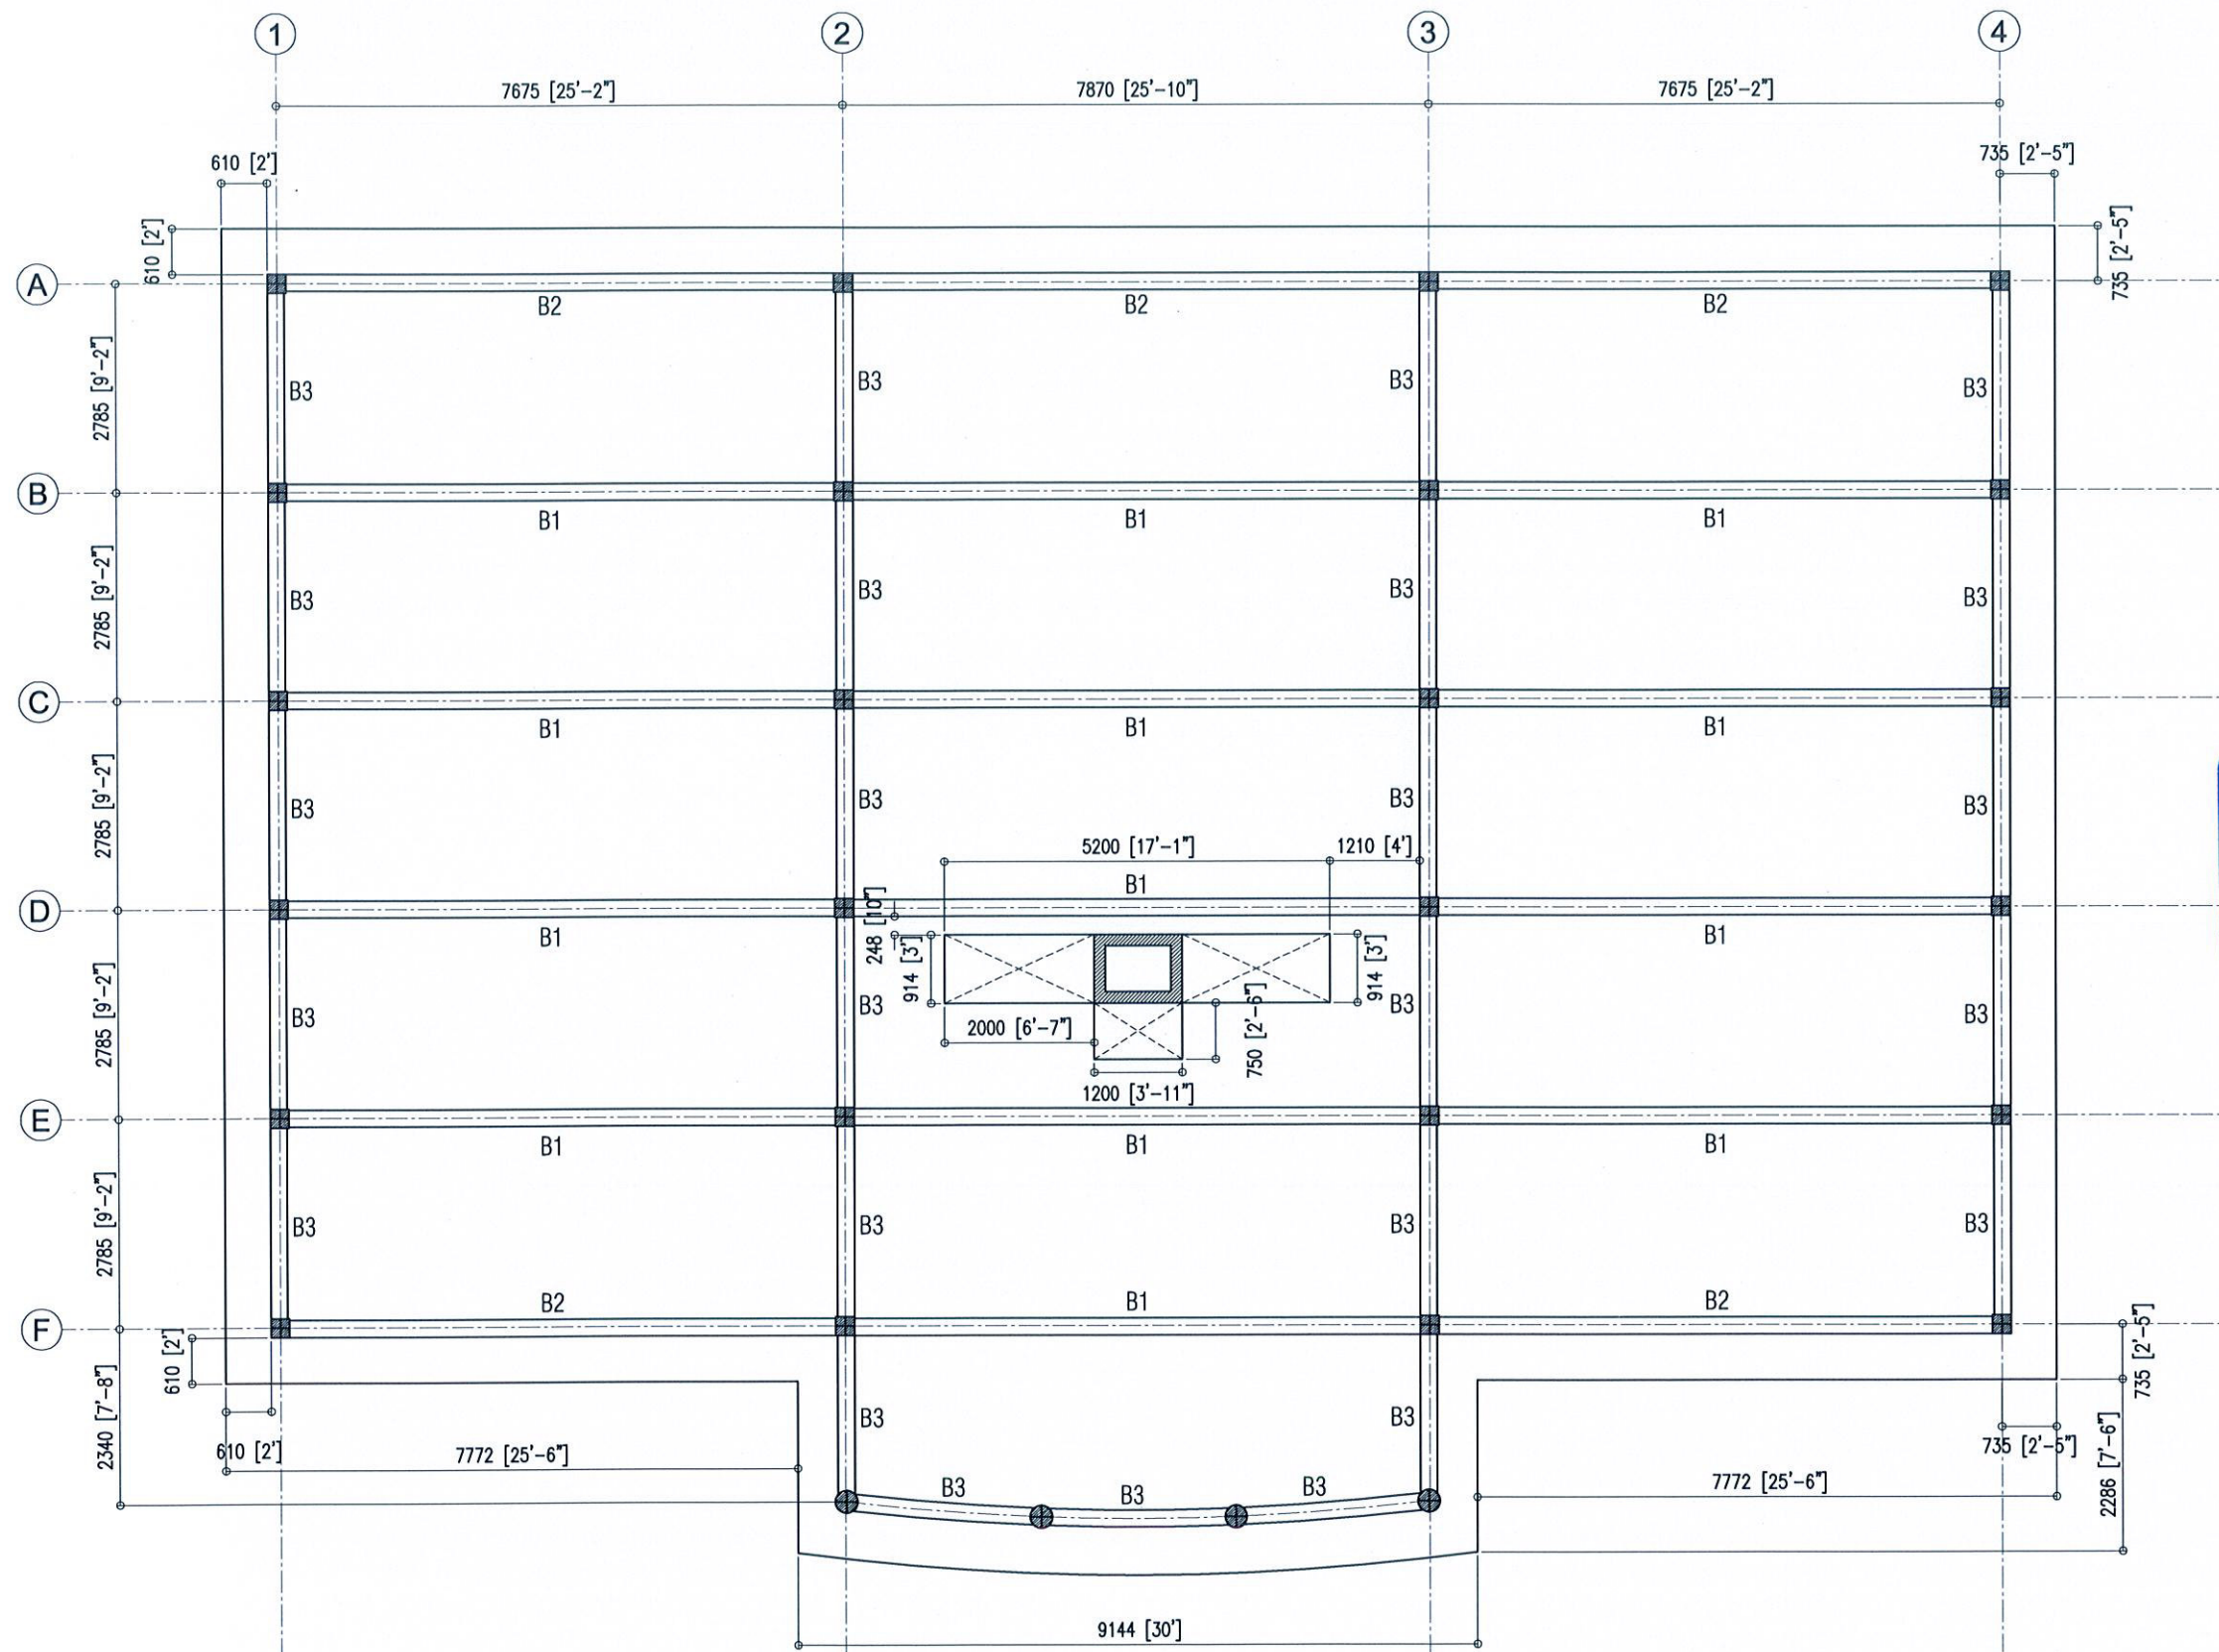


 Ministry of Housing & Infrastructure
ACCREDITED CHECKER:
STRUCTURAL CHECKER A1
 Name: Ashraf Hameed VALIDITY: 17.03.15 - 16.03.16
 Registration No: BPR2015006A1 A1-2015-006-001

REVISIONS:

PROJECT TITLE:
DHA, ATOLL COUNCIL


CLIENT:
LGA

ARCH. DESIGN:	SHAMIN	PROJECT NO	DHC-11/15
STRUC. DESIGN:	ASHRAF	DRAWING NO	S3
DATE:	MAY 2015		
SCALE:	AS GIVEN		

ALAAF
 ALAAF PRIVATE LIMITED
 THARUENGE (GROUND FLOOR) BUKHARIYA MAGUWALE 2004,
 TEL: (980)7773801, E-MAIL: alAAF.pvt@gmail.com, Web

1ST FLOOR BEAM PLAN
SCALE - 1:100

COPYRIGHT: THE CONCEPT AND DESIGN IN THIS DRAWING ARE THE PROPERTIES OF ALAAF PVT. LTD. THIS DRAWING SHOULD BE USED ONLY FOR THE PROJECT MENTIONED ON THIS SHEET.

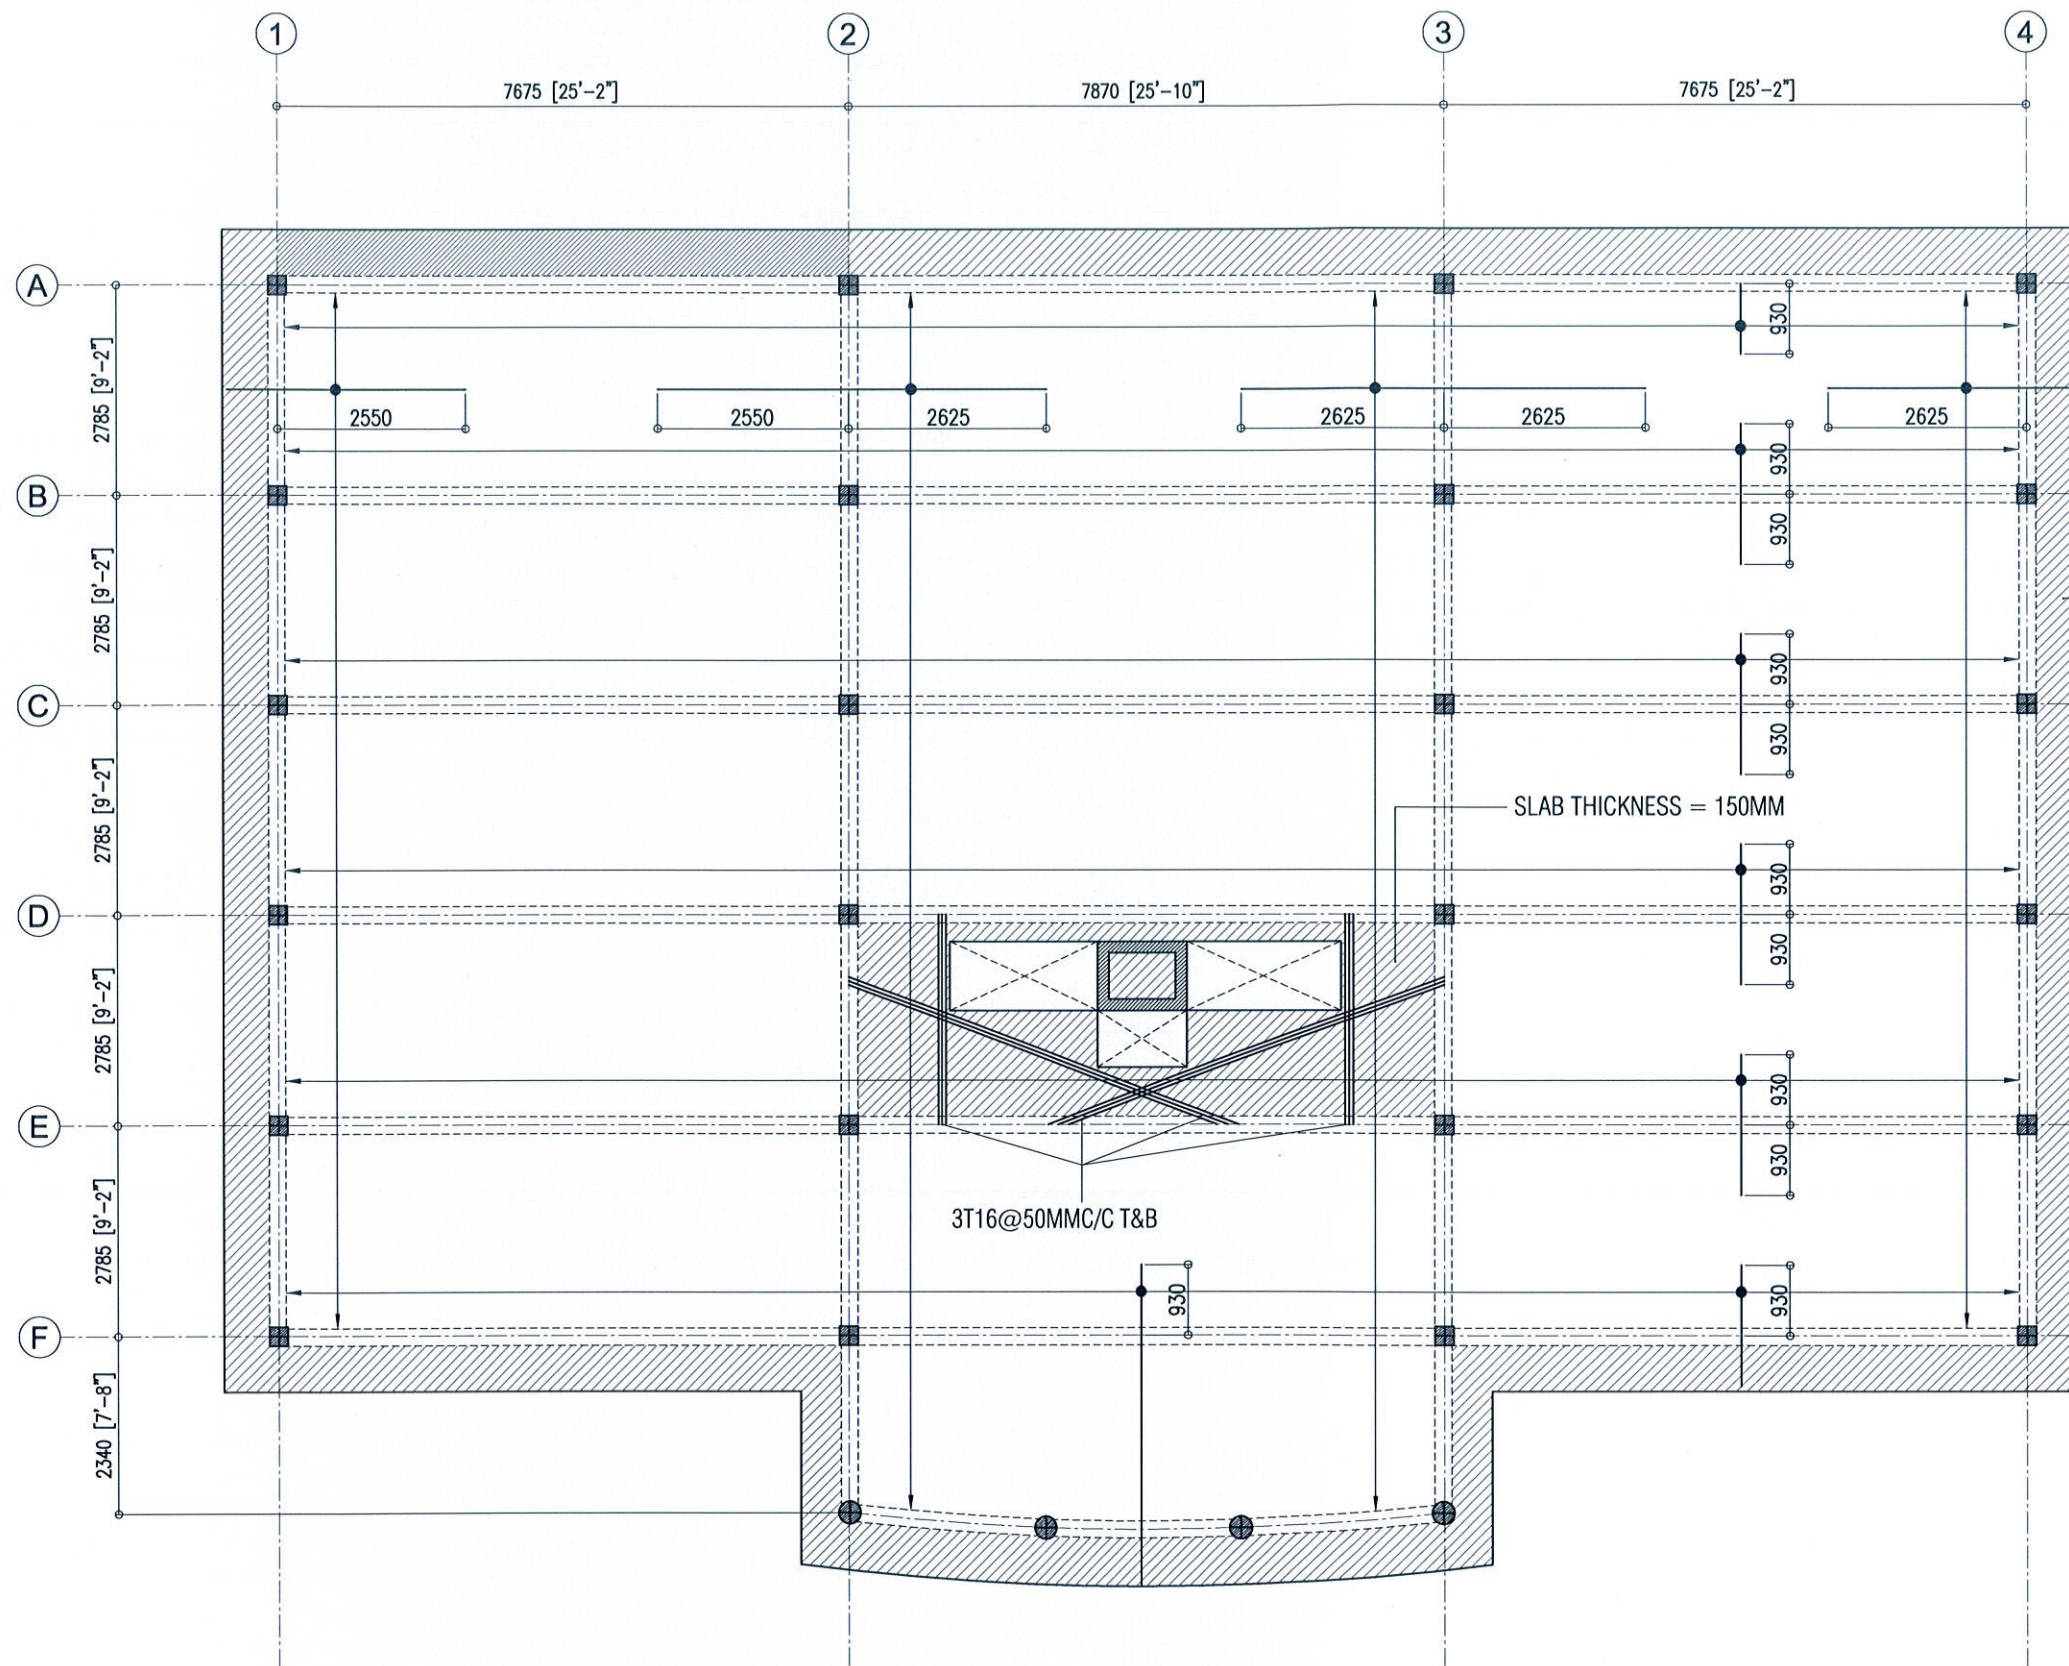

NOTE:-
 SLAB THICKNESS = 130MM
 TOP RFMNT = T10 @ 150 C/C BW (SHOWN)
 BOTTOM RFMNT = T10 @ 150 C/C BW (NOT SHOWN)
 DISTRIBUTION BARS = T10 @ 300 C/C BW (NOT SHOWN)
 REINFORCEMENT BARS WILL BE DISCONTINUOUS OVER VOIDS
 FOLLOW STANDARD REINFORCEMENT DETAILS FOR ALL OPENINGS
 ALL MAIN BARS SHAL HAVE BENDS UP OR DOWN EQUAL TO 12Ø FROM FACE OF SUPPORT

SLAB THICKNESS = 150MM



REVISIONS:

PROJECT TITLE:
DHA. ATOLL COUNCIL


CLIENT:
 LGA

ARCH. DESIGN:	SHAMIN	PROJECT NO	DHC-11/15
STRUC. DESIGN:	ASHRAF	DRAWING NO	S4
DATE:	MAY 2015		
SCALE:	AS GIVEN		

ALAAF
 ALAAF PRIVATE LIMITED
 THARUHOE (GROUND FLR) SABUDHEERIYA MAGU, MALE' 20004,
 TEL: (960)7773801, E-MAIL: alaaaf.pvt@gmail.com, Web

1ST FLOOR SLAB RFMT PLAN
 SCALE - 1:100

COPYRIGHT: THE CONCEPT AND DESIGN IN THIS DRAWING ARE THE PROPERTIES OF ALAAF PVT. LTD. THIS DRAWING SHOULD BE USED ONLY FOR THE PROJECT MENTIONED ON THIS SHEET.

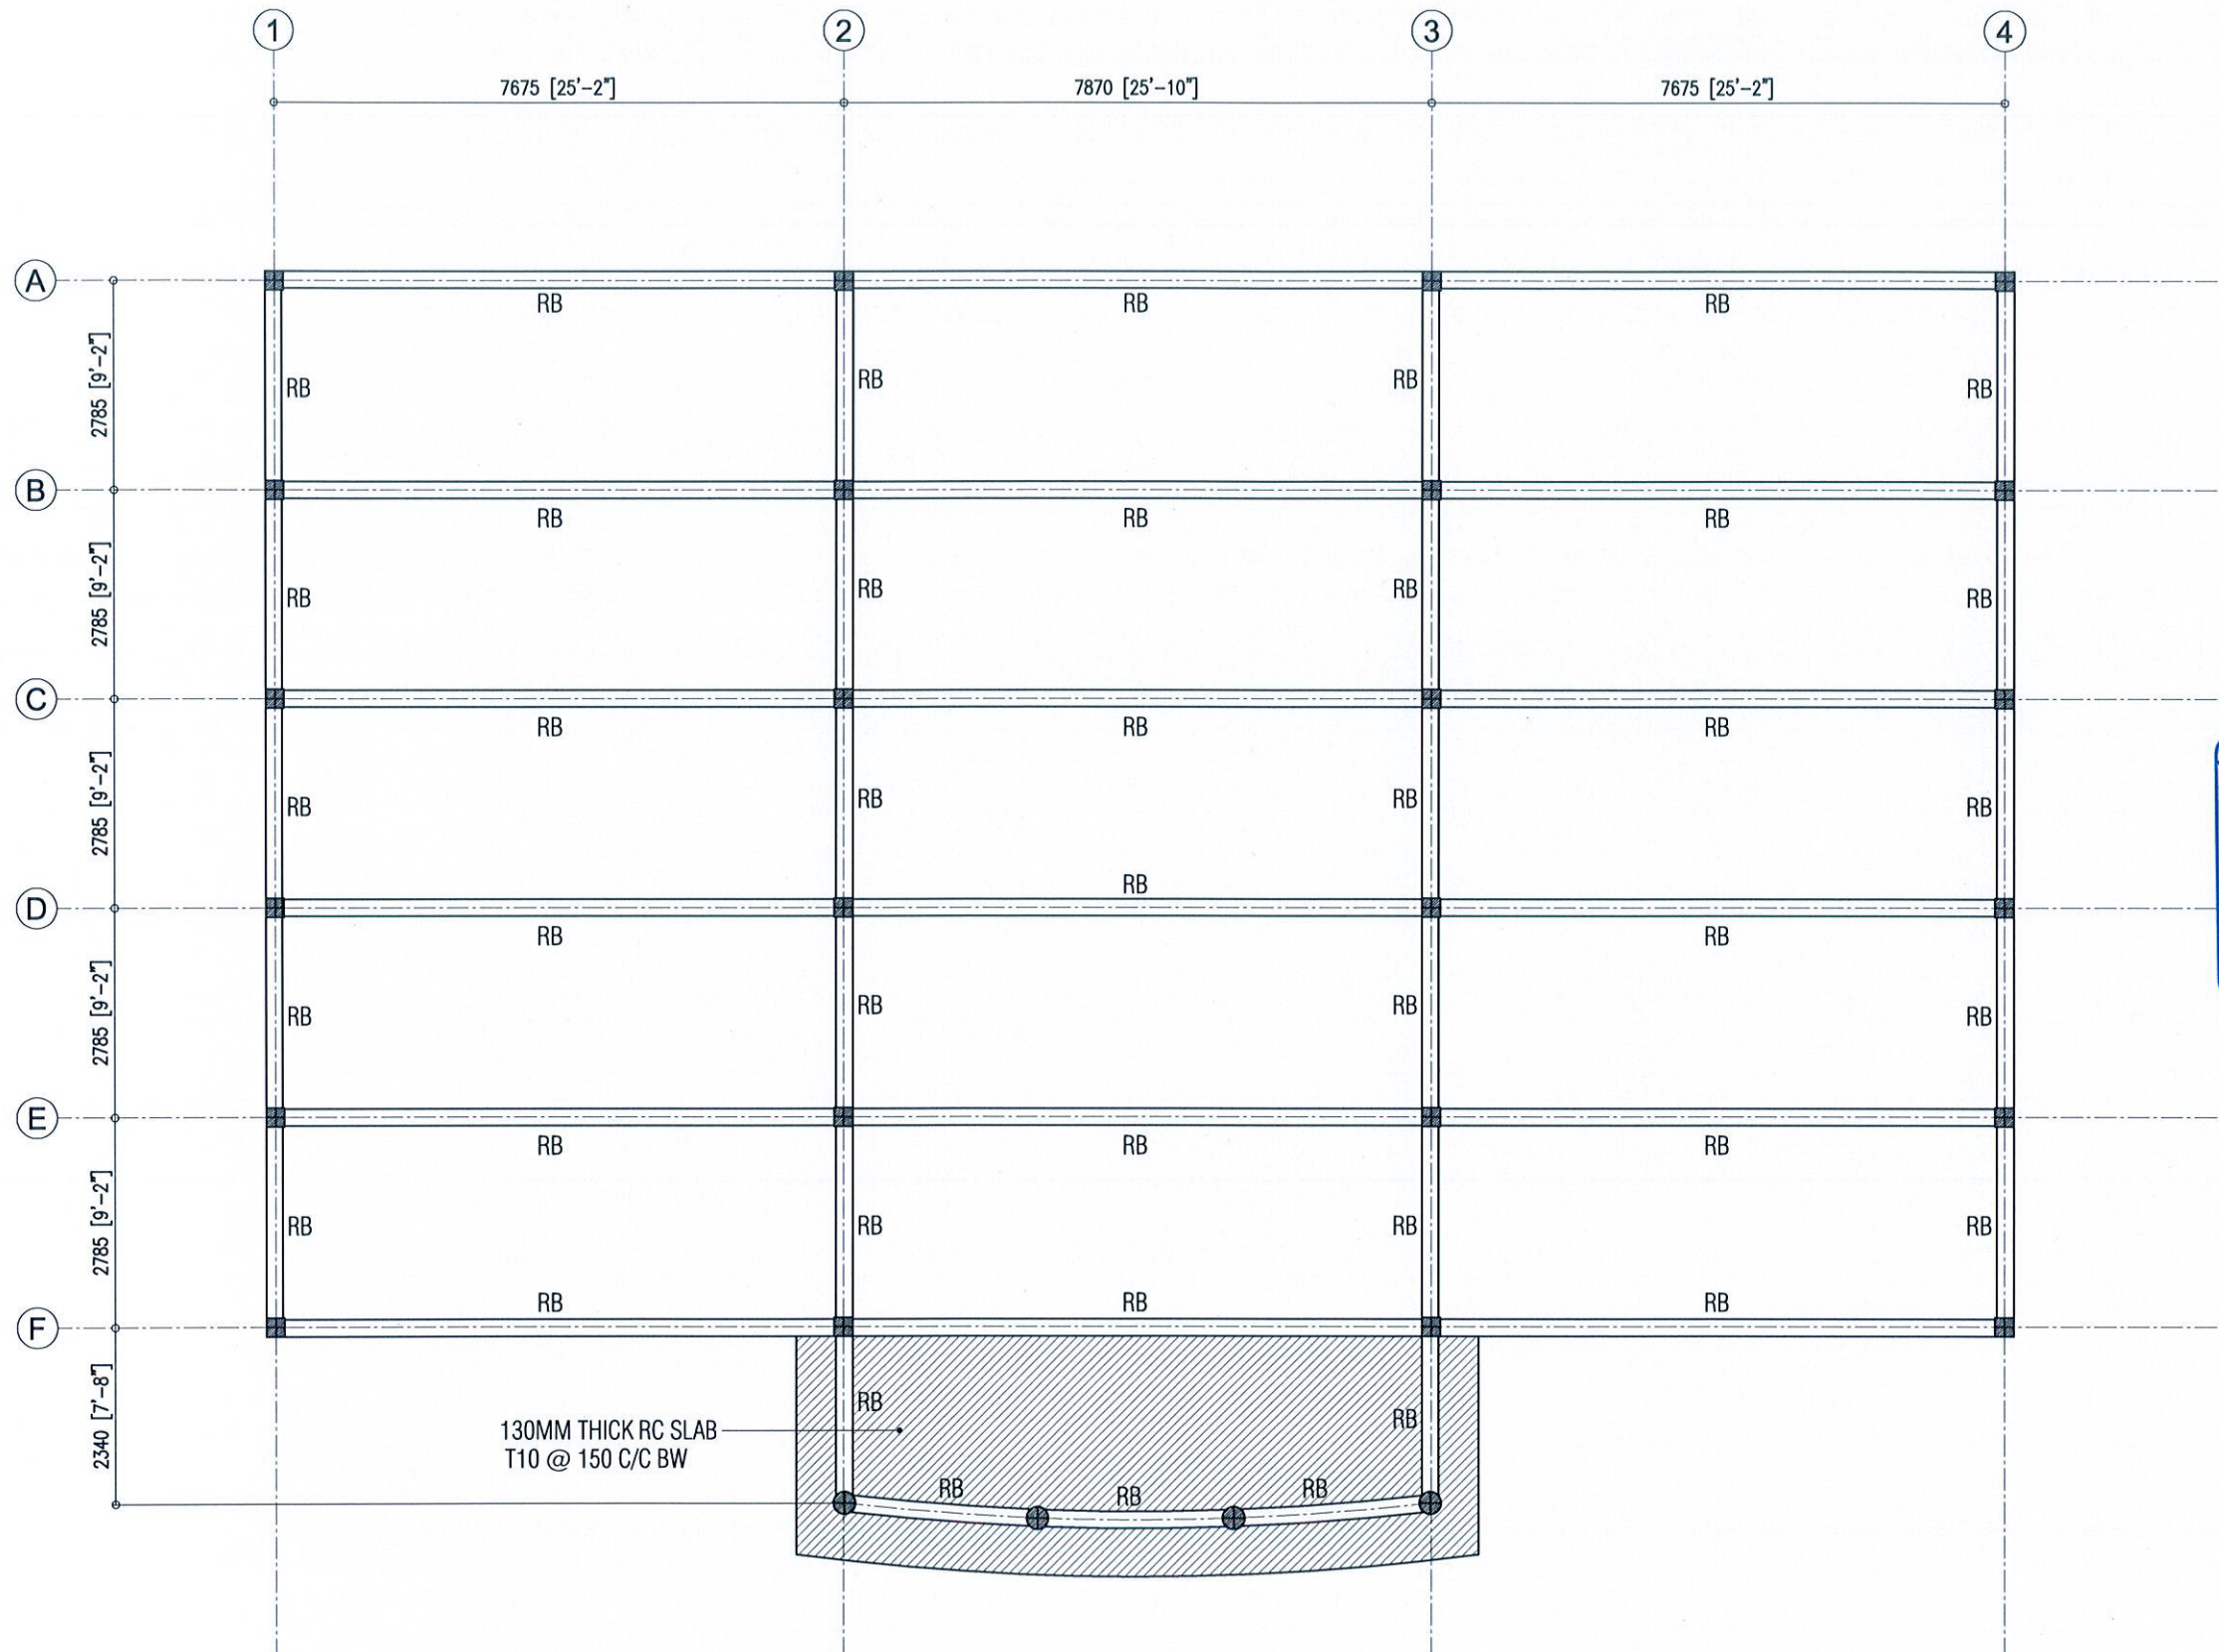

Ministry of Housing & Infrastructure
ACCREDITED CHECKER
STRUCTURAL CHECKER A1
 Name: Ashraf Hameed VALIDITY: 17.03.15 - 16.03.16
 Registration No: BPR2015006A1 A1-2015-006-001

REVISIONS:

PROJECT TITLE:
DHA. ATOLL COUNCIL


CLIENT:
 LGA

ARCH. DESIGN:	SHAMIN	PROJECT NO	DHC-11/15
STRUC. DESIGN:	ASHRAF	DRAWING NO	S5
DATE:	MAY 2015		
SCALE:	AS GIVEN		

ALAAF
 ALAAF PRIVATE LIMITED
 THARNEERU(ROUND FLU)SABURHERYA MAGUMALE'20004,
 TEL: (980)7773801, E-MAIL: alaf.pvt@gmail.com, Web

ROOF BEAM PLAN
 SCALE - 1:100

COPYRIGHT: THE CONCEPT AND DESIGN IN THIS DRAWING ARE THE PROPERTIES OF ALAAF PVT LTD. THIS DRAWING SHOULD BE USED ONLY FOR THE PROJECT MENTIONED ON THIS SHEET.

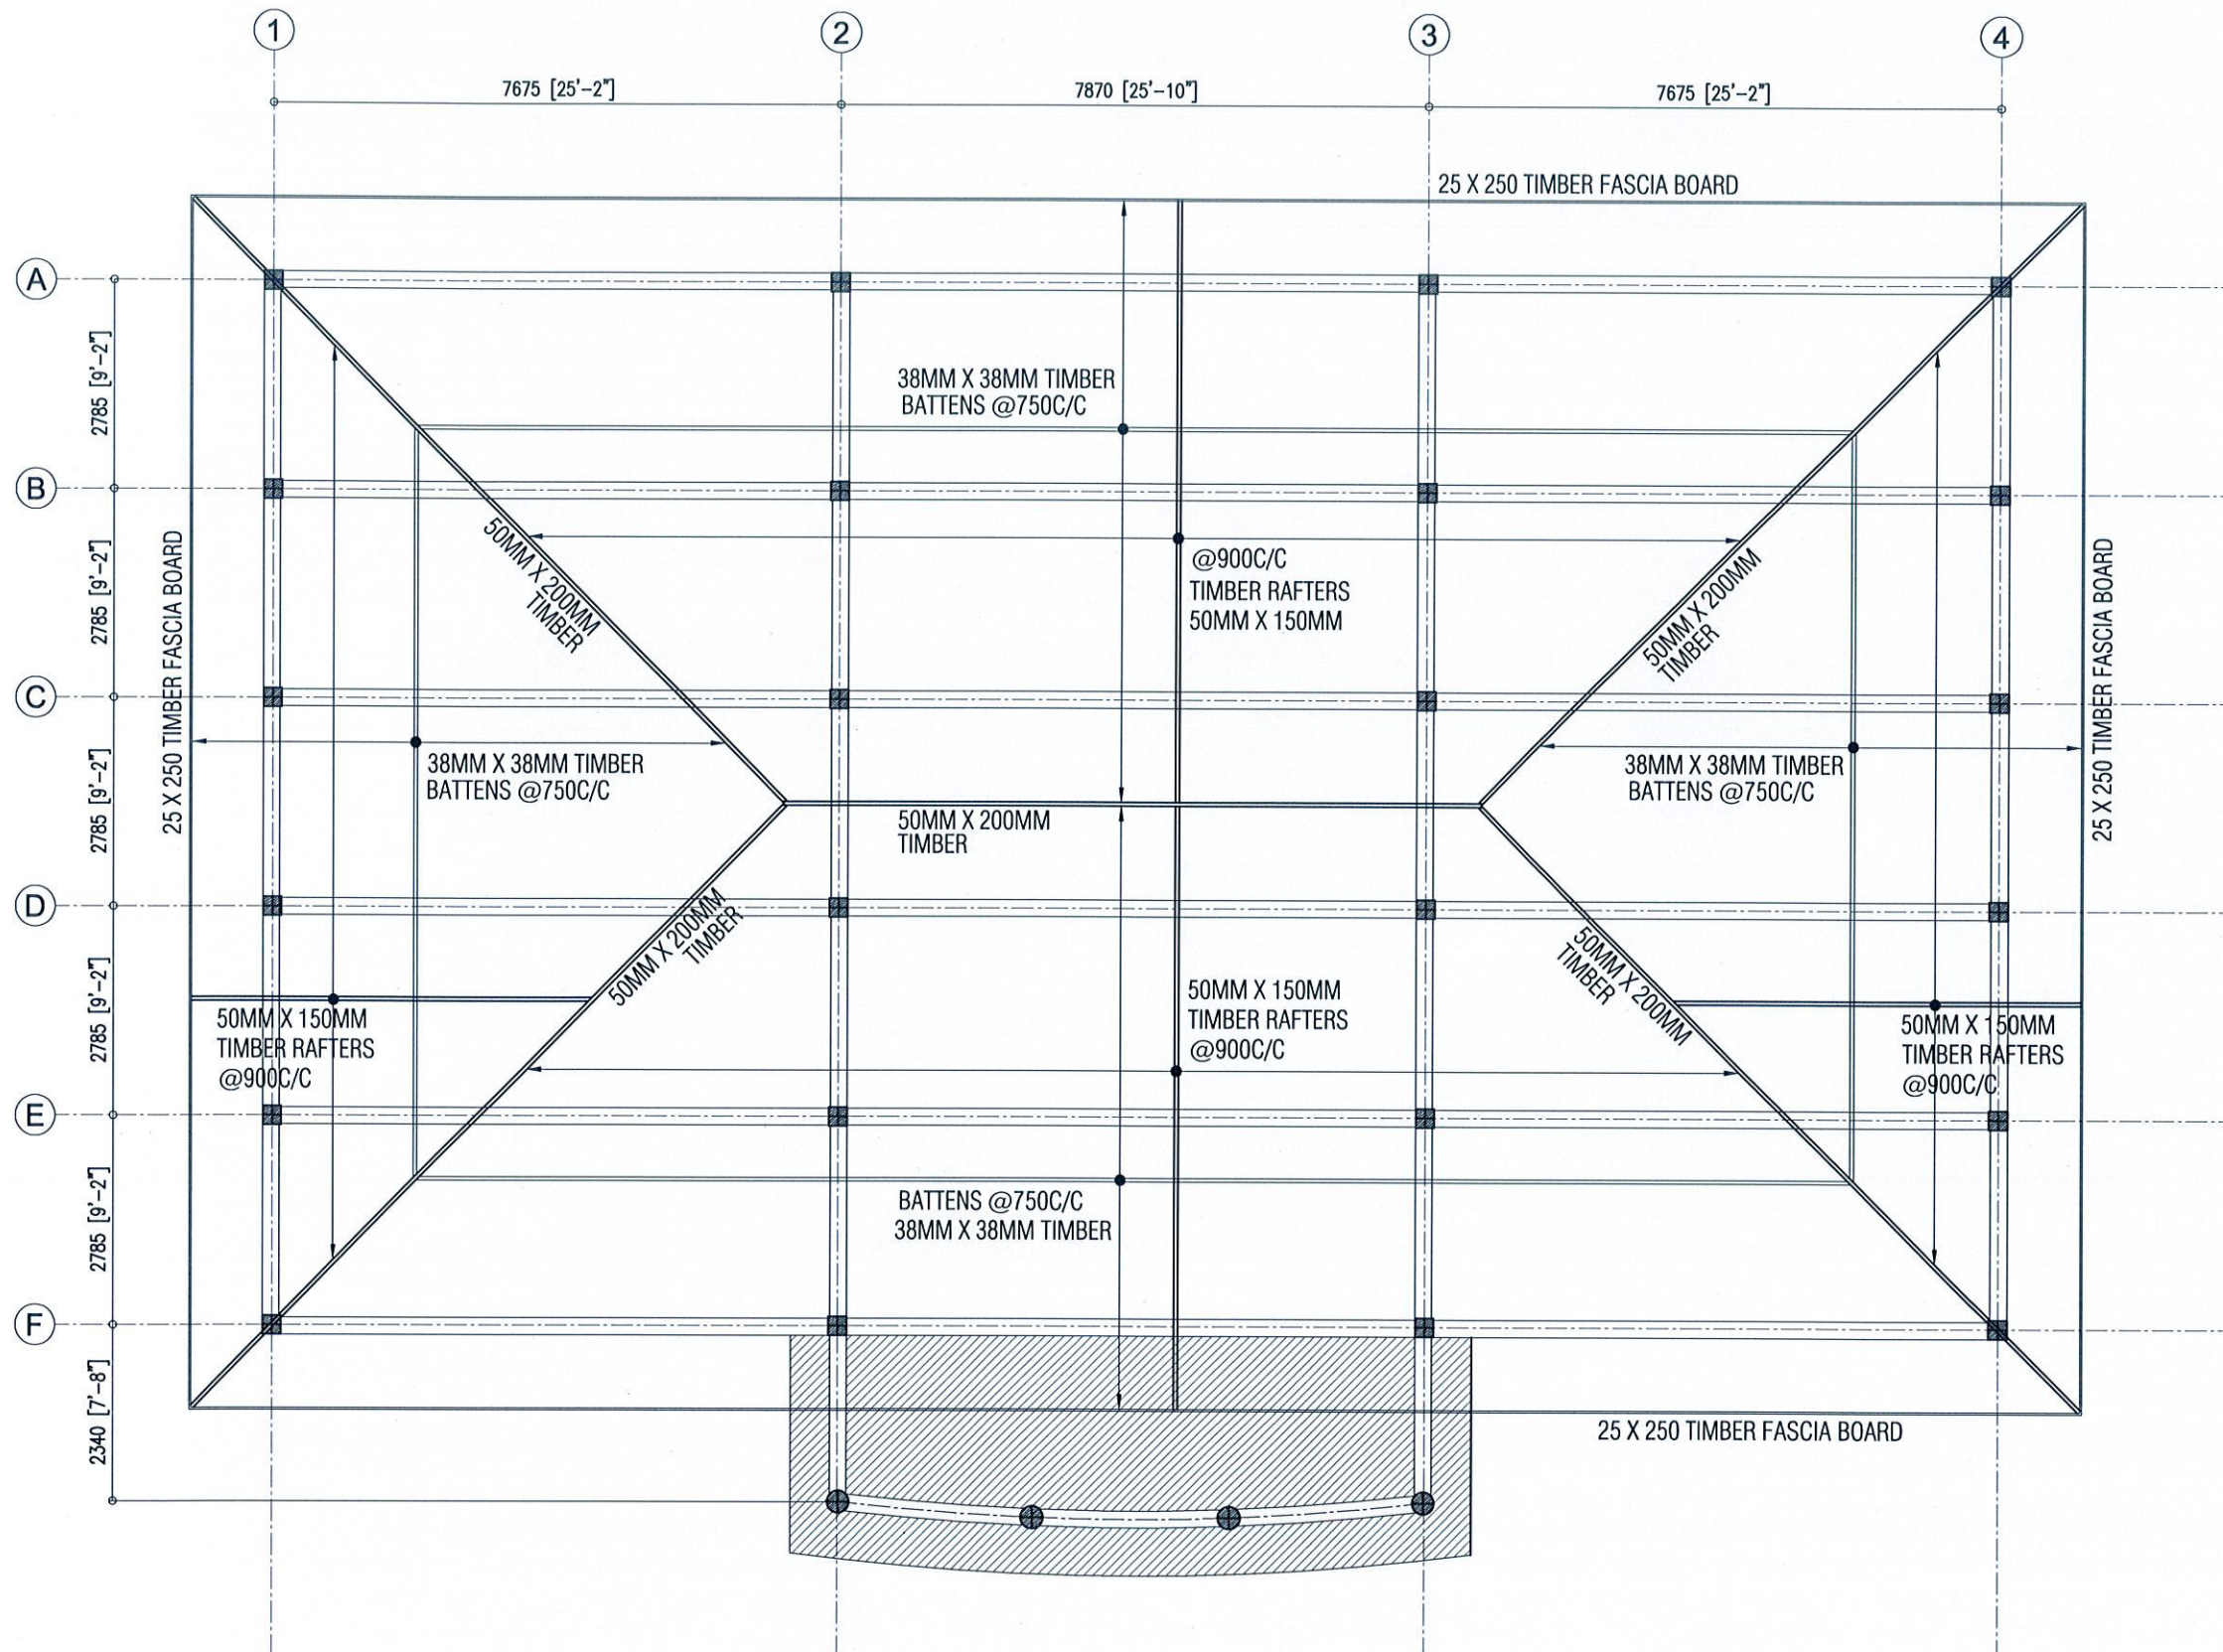

Ministry of Housing & Infrastructure
ACCREDITED CHECKER
STRUCTURAL CHECKER A1
 Name: Ashraf Hameed VALIDITY: 17.03.15 - 16.03.16
 Registration No: BPR2015006A1 A1-2015-006-001

REVISIONS:

PROJECT TITLE:
DHA. ATOLL COUNCIL


CLIENT:
 LGA

ARCH. DESIGN:	SHAMIN	PROJECT NO	DHC-11/15
STRUC. DESIGN:	ASHRAF	DRAWING NO	S6
DATE:	MAY 2015		
SCALE:	AS GIVEN		



ALAAF
 ALAAF PRIVATE LIMITED
 THARUHEIGE(GROUND FLOOR)SABUDHERYA MAGU,MALE'2004,
 TEL: (96)7773601, E-MAIL: alaf.pvt@gmail.com,Web

ROOF FRAMING PLAN
 SCALE - 1:100


COPYRIGHT: THE CONCEPT AND DESIGN IN THIS DRAWING ARE THE PROPERTIES OF ALAAF PVT. LTD. THIS DRAWING SHOULD BE USED ONLY FOR THE PROJECT MENTIONED ON THIS SHEET.

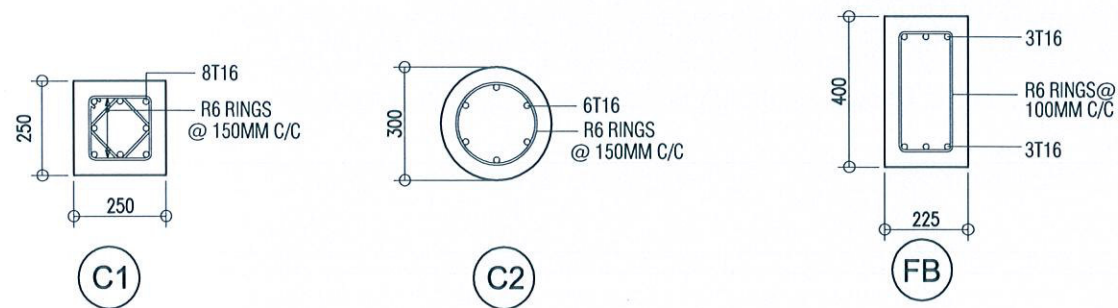

FOUNDATION BEAM AND COLUMN DETAILS
SCALE-1:20

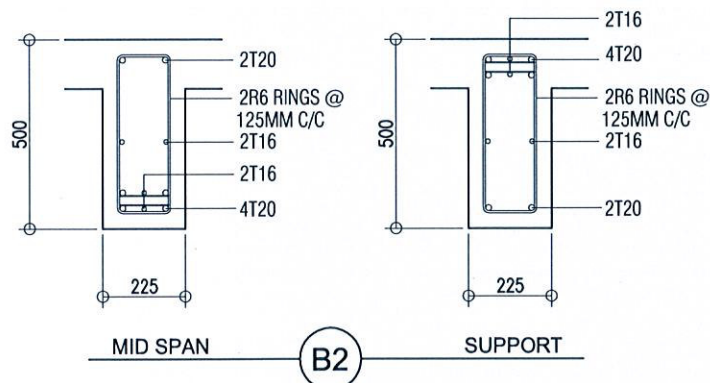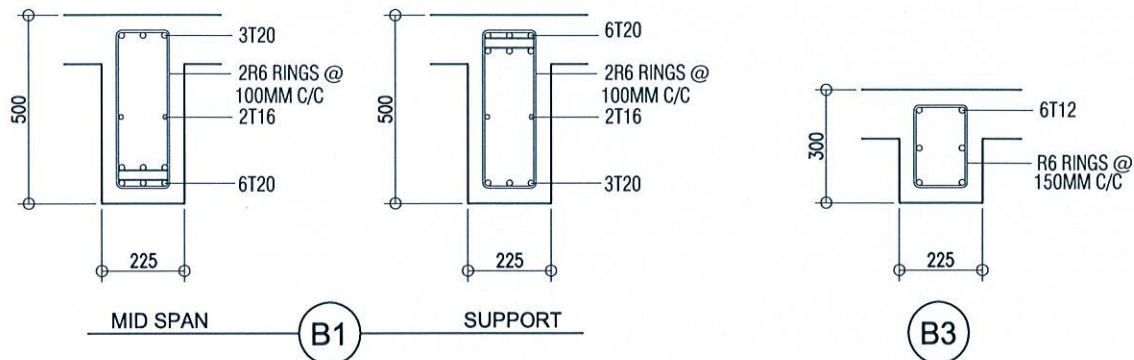

BEAM DETAILS
SCALE 1:20

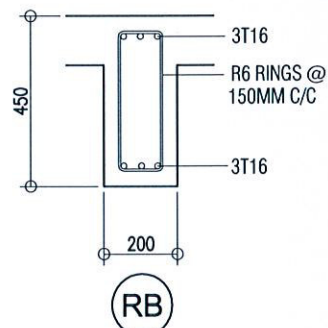

ROOF BEAM DETAILS
SCALE 1:20

FOUNDATION FOOTING DETAILS	FOUNDATION FOOTING DIMENSION	FOUNDATION FOOTING RFMT
F1	1500MM X 1500MM X 300MM	T12 @ 125MM C/C BW BOTTOM
F2	1050MM X 1050MM X 300MM	T10 @ 150MM C/C BW BOTTOM
F3	1150MM X 1150MM X 300MM	T10 @ 150MM C/C BW BOTTOM
F4	1350MM X 1350MM X 300MM	T10 @ 125MM C/C BW BOTTOM
F5	1500MM X 1800MM X 300MM	T10 @ 125MM C/C BW BOTTOM

SPECIFICATIONS FOR CONCRETE WORKS


- USE RIVER SAND AND GRANITE FOR AGGREGATES.
- MAIN REINFORCEMENT STEEL TO BE HIGH STRENGTH DEFORMED BARS FOR CONCRETING
- USE WATER FREE OF SALT AND ANY OTHER IMPURITIES

NOTE:


- APPROVED TYPE OF WATER PROOFING TO BE APPLIED ON ALL THE FOUNDATION

MIN. REINFORCEMENT CLEAR COVERS :

- FOUNDATION BEAMS 50MM (BOT, TOP, SIDES)
- COLUMNS 40MM (SIDES)
- SLAB BEAM 35MM (BOT), 40MM (SIDES)
- SLAB 30MM (BOT), 40MM (SIDES)

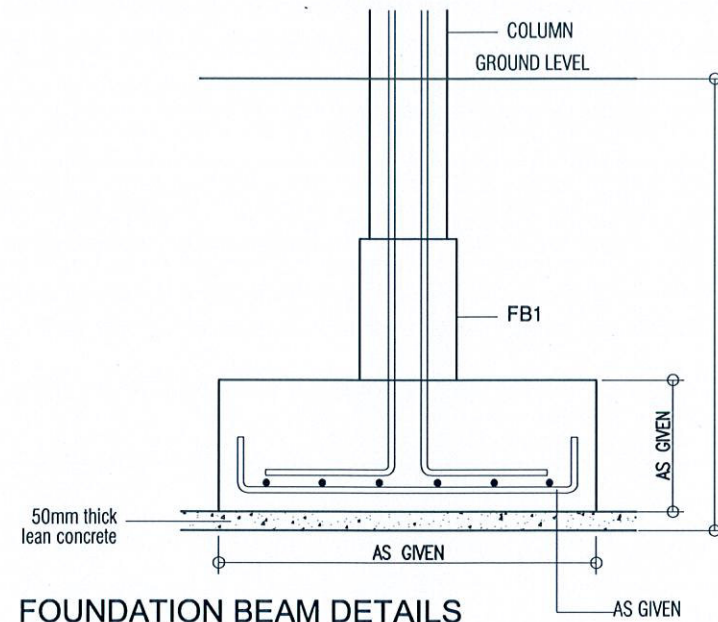

FOUNDATION BEAM DETAILS
SCALE 1:20

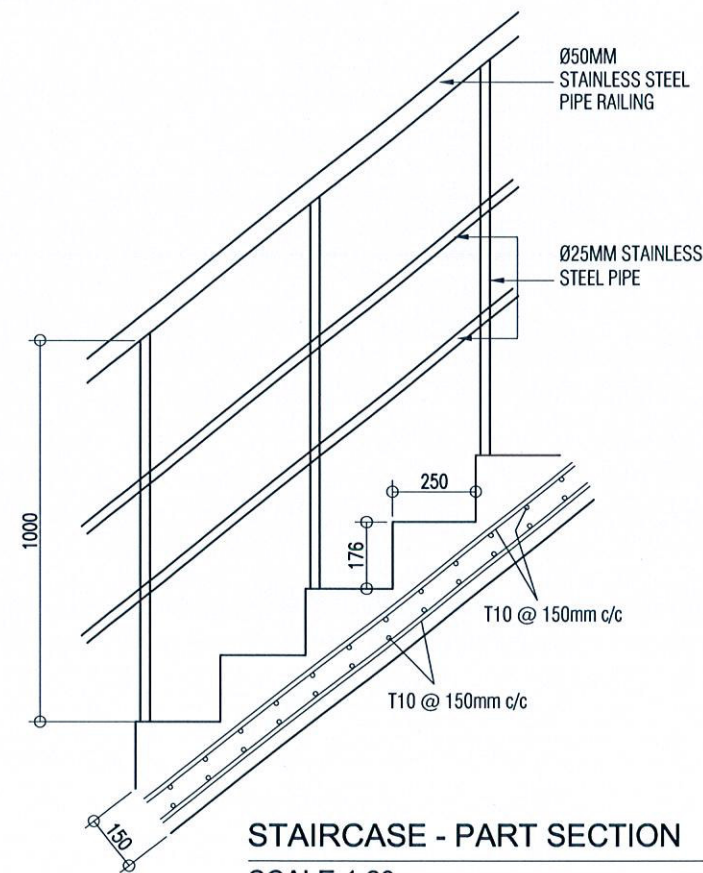

STAIRCASE - PART SECTION
SCALE 1:20



REVISIONS:	
PROJECT TITLE: DHA. ATOLL COUNCIL	
CLIENT : LGA	
ARCH. DESIGN: SHAMIN	PROJECT NO: DHC-11/15
STRUC. DESIGN: ASHRAF	DRAWING NO: S7
DATE: MAY 2015	SCALE: AS GIVEN
ALAAF ALAAF PRIVATE LIMITED THARUJEEZE(GROUND FLR)SABUKHERYA MAGUMALE 20004. TEL: (980)773801, E-MAIL: alaaaf.pvt@gmail.com, Web	

COPYRIGHT: THE CONCEPT AND DESIGN IN THIS DRAWING ARE THE PROPERTIES OF ALAAF PVT LTD. THIS DRAWING SHOULD BE USED ONLY FOR THE PROJECT MENTIONED ON THIS SHEET.