

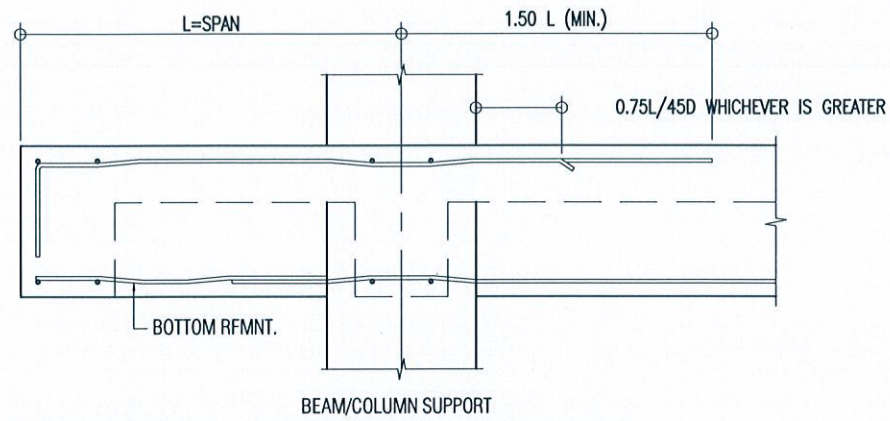



TYPICAL JUNCTION DETAILS OF BEAM & COLUMN  
SCALE 1:20

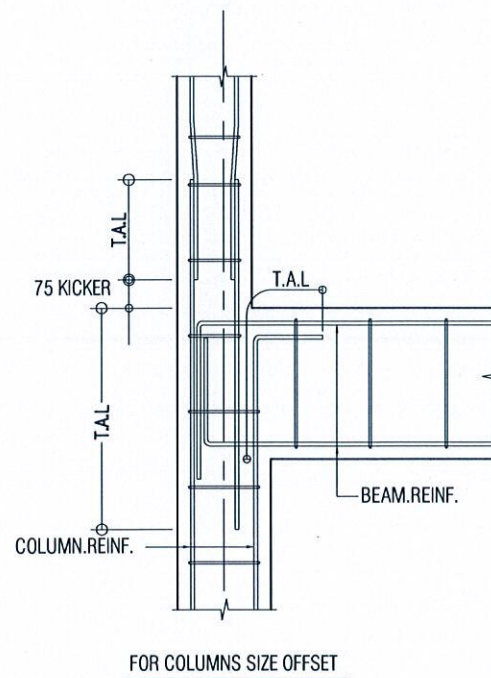

TYPICAL BEAM DETAILS FOR CANTILEVER  
SCALE 1:20

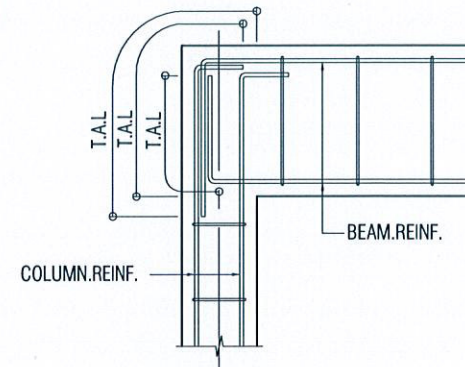

TYPICAL JUNCTION DETAILS OF BEAM & COLUMN  
SCALE 1:20

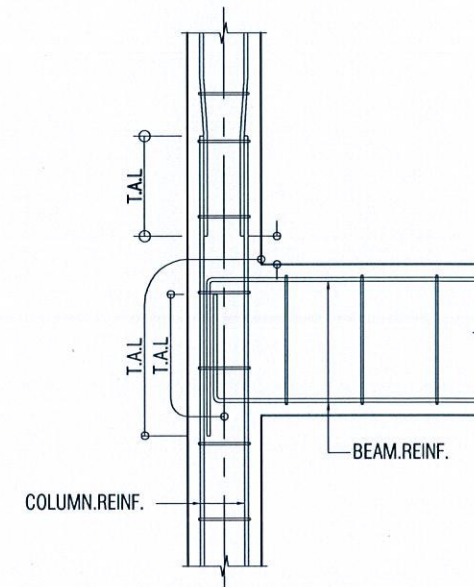






 




Ministry of Housing & Infrastructure  
**ACCREDITED CHECKER**  
STRUCTURAL CHECKER A1  
Name: Ashraf Hameed VALIDITY: 17.03.15 - 16.03.16  
Registration No: BPR2015006A1 A1-2015-006-001

REVISIONS:		
PROJECT TITLE: DHA. ATOLL COUNCIL		
CLIENT : LGA		
ARCH. DESIGN:	SHAMIN	PROJECT NO DHC-11/15
STRUC. DESIGN:	ASHRAF	DRAWING NO S8
DATE:	MAY 2015	
SCALE:	AS GIVEN	
<b>ALAAF</b> ALAAF PRIVATE LIMITED THURUHEE(GROUND FLR)SABUKHERYA MAGUMALE'20004, TEL: (990)773801, E-MAIL: alaa.pvt@gmail.com, Web		

COPYRIGHT: THE CONCEPT AND DESIGN IN THIS DRAWING ARE THE PROPERTIES OF ALAAF PVT. LTD. THIS DRAWING SHOULD BE USED ONLY FOR THE PROJECT MENTIONED ON THIS SHEET.

**ELECTRICAL LEGEND**

-  CEILING MOUNT LIGHT
-  600 MM - L LENGTH FLOURESCENT TUBE LIGHT LUMINARE
-  ONE WAY SWITCH 1.2MH
-  TELEPHONE SOCKET
-  NETWORK
-  WALL SOCKET OUTLET (SGL GNG 13A)
-  WALL SOCKET OUTLET (DBL GNG 13A)
-  WALL SOCKET OUTLET (SERVICE 15A)
-  D-BOARD
-  WEATHER PROOF MOUNT LIGHT

REVISIONS:


PROJECT TITLE:  
**DHA. ATOLL COUNCIL**

CLIENT :  
LGA

ARCH. DESIGN:	SHAMIN	PROJECT NO
STRUC. DESIGN:	ASHRAF	DHC-11/15
DATE :	MAY 2015	DRAWING NO
SCALE:	AS GIVEN	<b>E1</b>

**ALAAF**  
ALAAF PRIVATE LIMITED  
THARUHQE(GROUND FLR)SABUDHERYA MAGUMALE'20004,  
TEL: (960)7773801, E-MAIL: alaaflpvt@gmail.com, Web

COPYRIGHT: THE CONCEPT AND DESIGN IN THIS DRAWING ARE THE PROPERTIES OF ALAAF PVT LTD. THIS DRAWINGS SHOULD BE USED ONLY FOR THE PROJECT MENTIONED ON THIS SHEET.

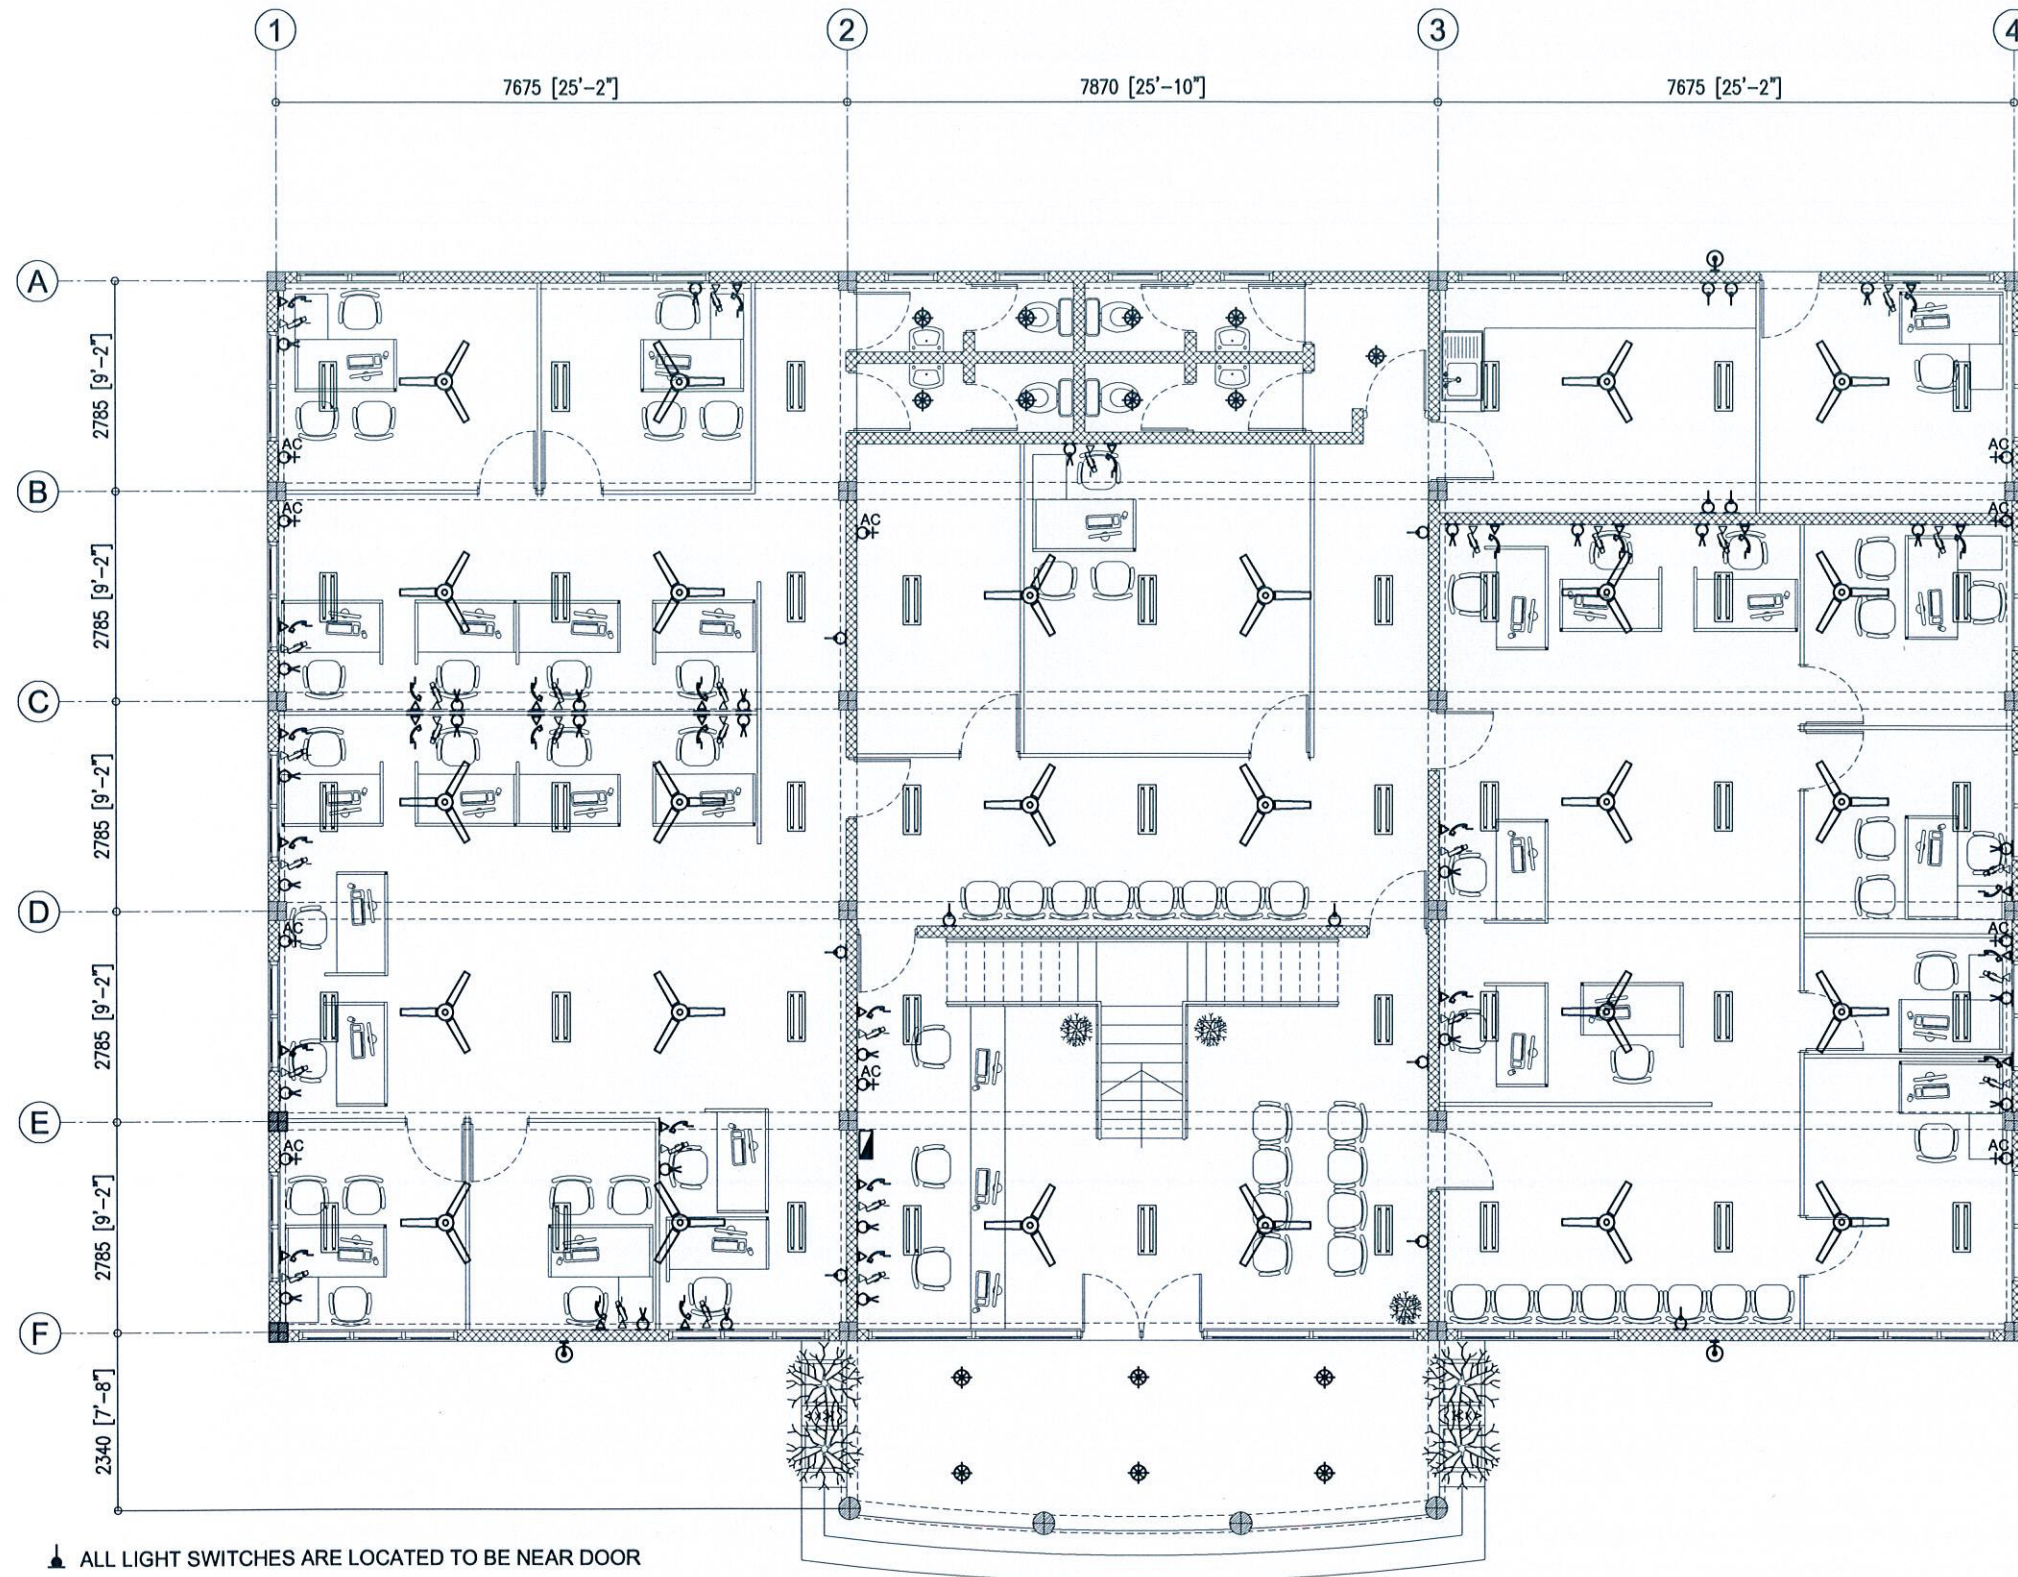

▲ ALL LIGHT SWITCHES ARE LOCATED TO BE NEAR DOOR

**GROUND ELECTRICAL LAYOUT**  
SCALE - 1:100

REVISIONS:


PROJECT TITLE:  
**DHA. ATOLL COUNCIL**

CLIENT :  
LGA

ARCH. DESIGN:	SHAMIN	PROJECT NO	DHC-11/15
STRUC. DESIGN:	ASHRAF	DRAWING NO	E2
DATE:	MAY 2015		
SCALE:	AS GIVEN		

**ALAAF**  
ALAAF PRIVATE LIMITED  
THIRUVARUR (GROUND FLOOR) SAUBHERAYA NAGAR, MALE 20004,  
TEL: (980) 7773001, E-MAIL: alaaft@gmail.com, Web

COPYRIGHT: THE CONCEPT AND DESIGN IN THIS DRAWING ARE THE PROPERTIES OF ALAAF PVT. LTD. THIS DRAWING SHOULD BE USED ONLY FOR THE PROJECT MENTIONED ON THIS SHEET.

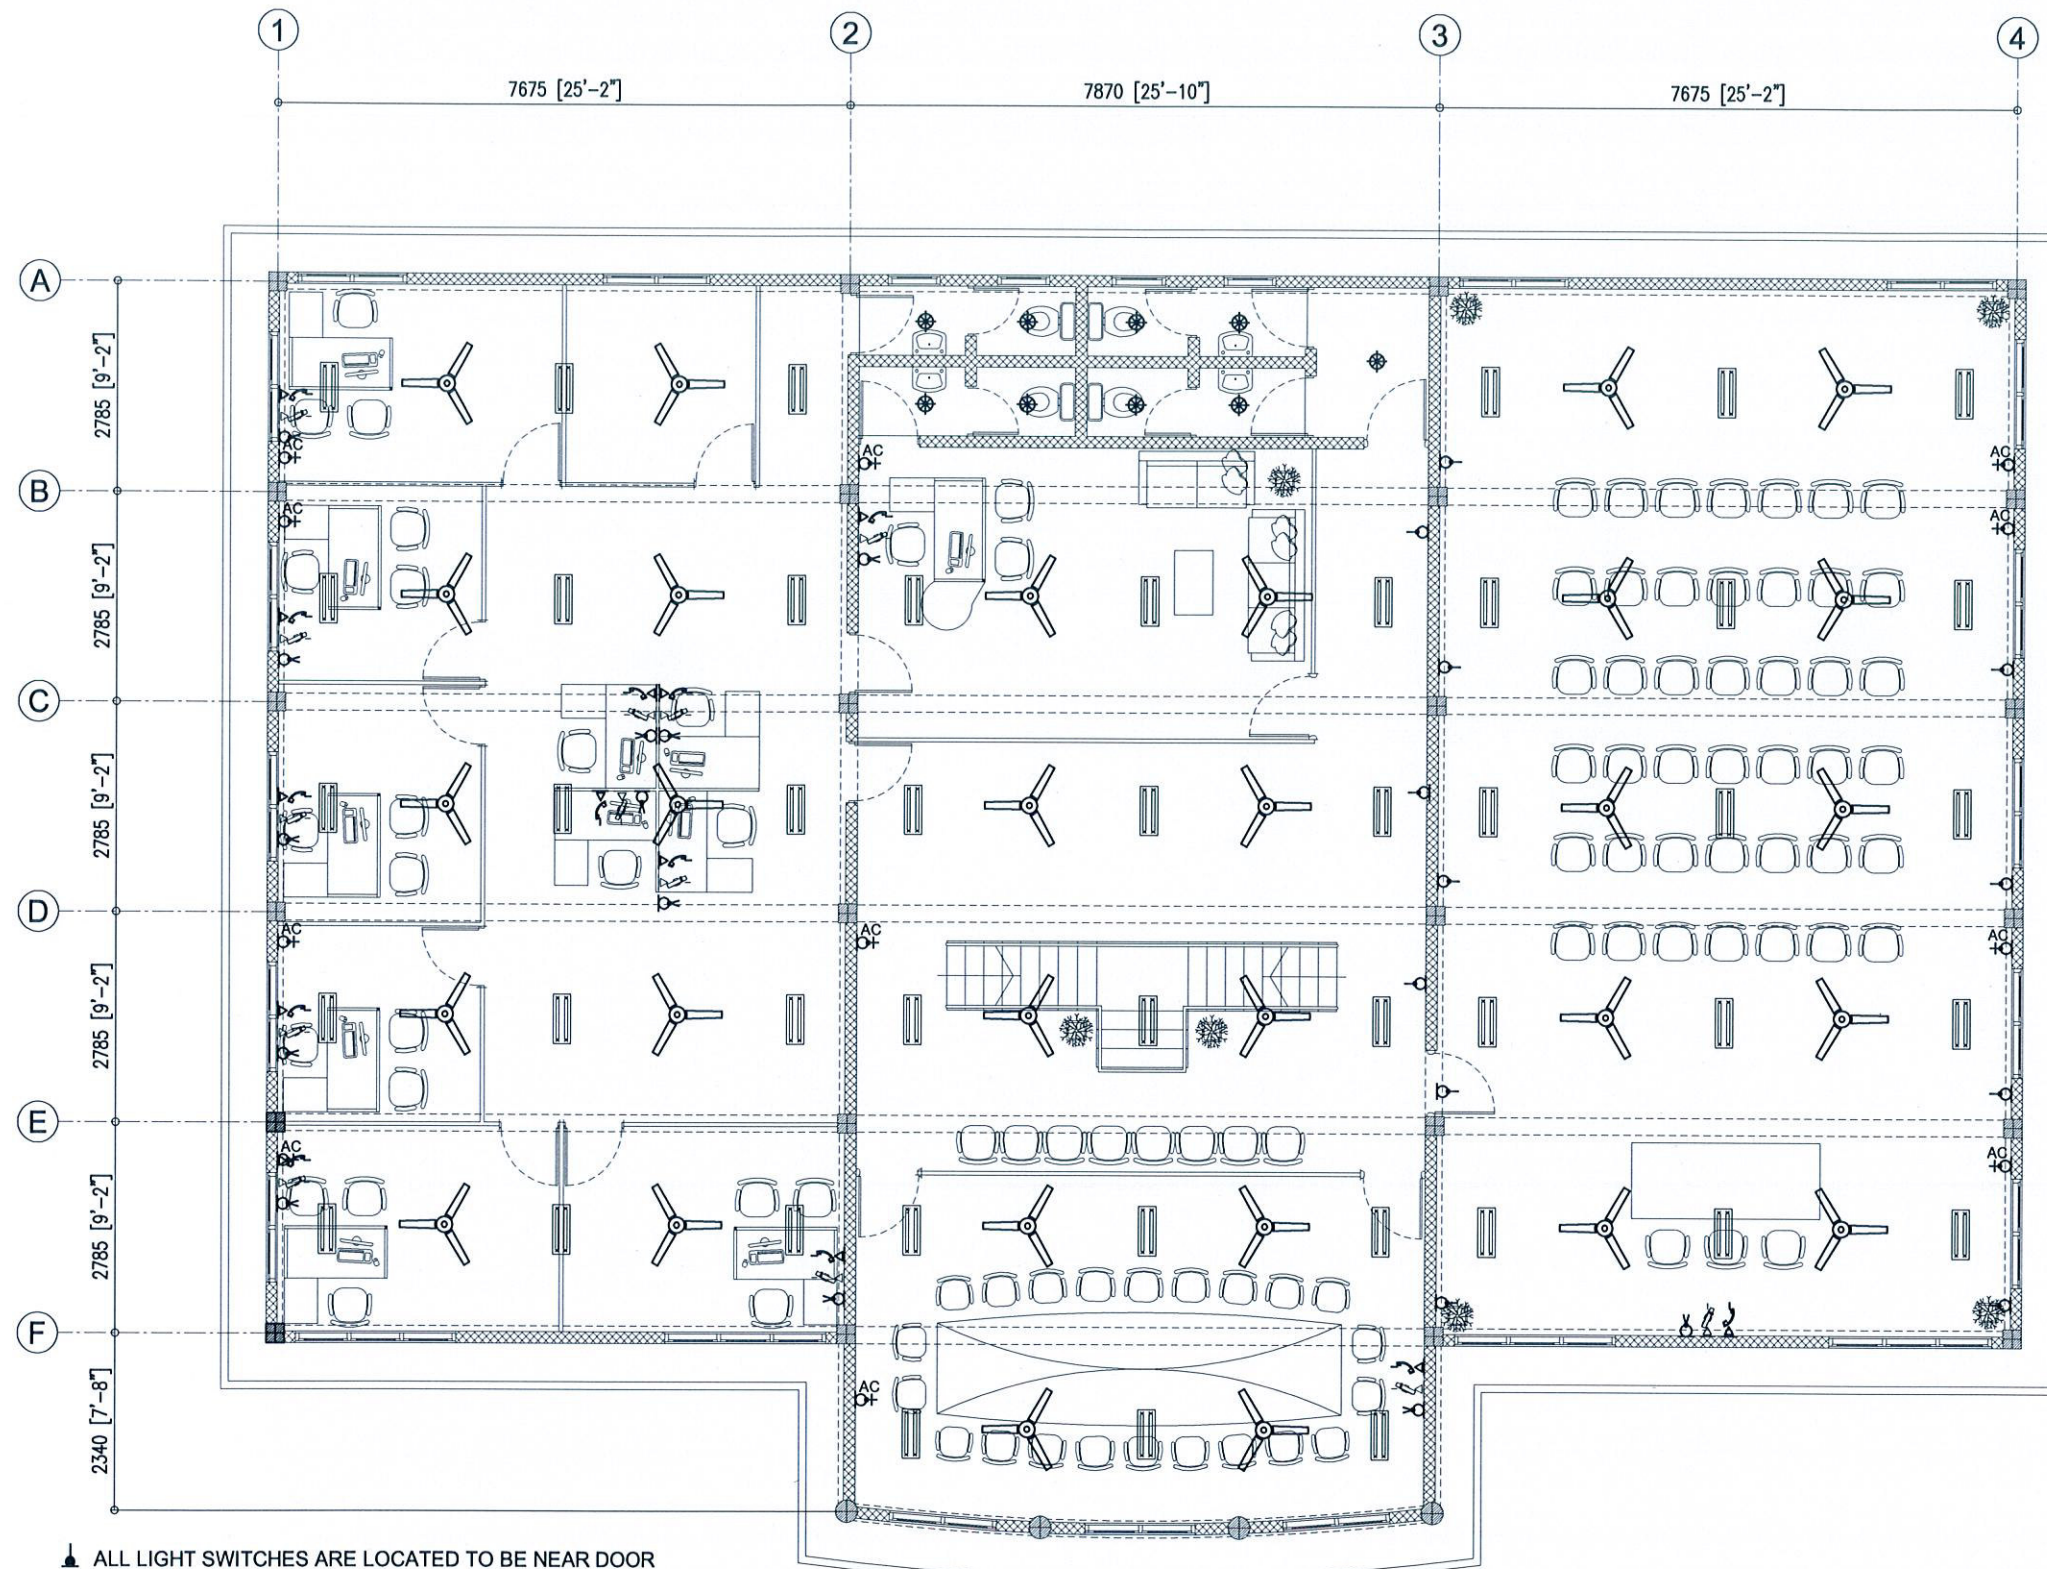





 




 



 
⬇ ALL LIGHT SWITCHES ARE LOCATED TO BE NEAR DOOR

**1ST FLOOR ELECTRICAL LAYOUT**  
SCALE - 1:100

REVISIONS:		
PROJECT TITLE:		
DHA. ATOLL COUNCIL		
CLIENT:		
LGA		
ARCH. DESIGN:	SHAMIN	PROJECT NO
STRUC. DESIGN:	ASHRAF	DHC-11/15
DATE:	MAY 2015	DRAWING NO
SCALE:	AS GIVEN	E3
<small>ALAAF PRIVATE LIMITED THARUDHIGE(GROUND FLR)SABUDHERYA MAGUMALE 20004. TEL: (960)7773601, E-MAIL: alAAF.pvt@gmail.com, Web</small>		


COPYRIGHT: THE CONCEPT AND DESIGN IN THIS DRAWING ARE THE PROPERTIES OF ALAAF PVT. LTD. THIS DRAWING SHOULD BE USED ONLY FOR THE PROJECT MENTIONED ON THIS SHEET.

**Plumbing Symbols Key:**


SYMBOLS	DESCRIPTION	SYMBOLS	DESCRIPTION
	- SEWAGE DISPOSAL LINE (Ø100)		- FLOOR DRAIN
	- WASTE WATER LINE(Ø35)		- STOP/GATE VALVE
	- MWSC WATER PIPE(Ø35)		- PUMP
	- GROUND WATER PIPE(Ø35)		- MWSC WATER METER
	- VENT PIPE(Ø50)		- Ø100MM CLEAN OUT WITH CAP
	- FAUCET (F)		- SHOWER (S)
	- MUSLIM SHOWER (M)		- BOOSTER BUMP

**NOTE:**

- \* ALL THE CONNECTION SHOULD BE DONE THROUGH GATE VALVE
- \* THIS DRAWING IS ONLY FOR PLUMBING USE

REVISIONS:		
PROJECT TITLE:		
DHA. ATOLL COUNCIL		
CLIENT:		
LGA		
ARCH. DESIGN:	SHAMIN	PROJECT NO
STRUC. DESIGN:	ASHRAF	DHC-11/15
DATE:	MAY 2015	DRAWING NO
SCALE:	AS GIVEN	P1
		
<small>ALAAF PRIVATE LIMITED THARUJHGE(GROUND FLOOR)SABUDHERYA MAGUMALE'20004, TEL: (980)7773601, E-MAIL: alaf.pvt@gmail.com,Web</small>		

COPYRIGHT: THE CONCEPT AND DESIGN IN THIS DRAWING ARE THE PROPERTIES OF ALAAF PVT LTD. THIS DRAWING SHOULD BE USED ONLY FOR THE PROJECT MENTIONED ON THIS SHEET.

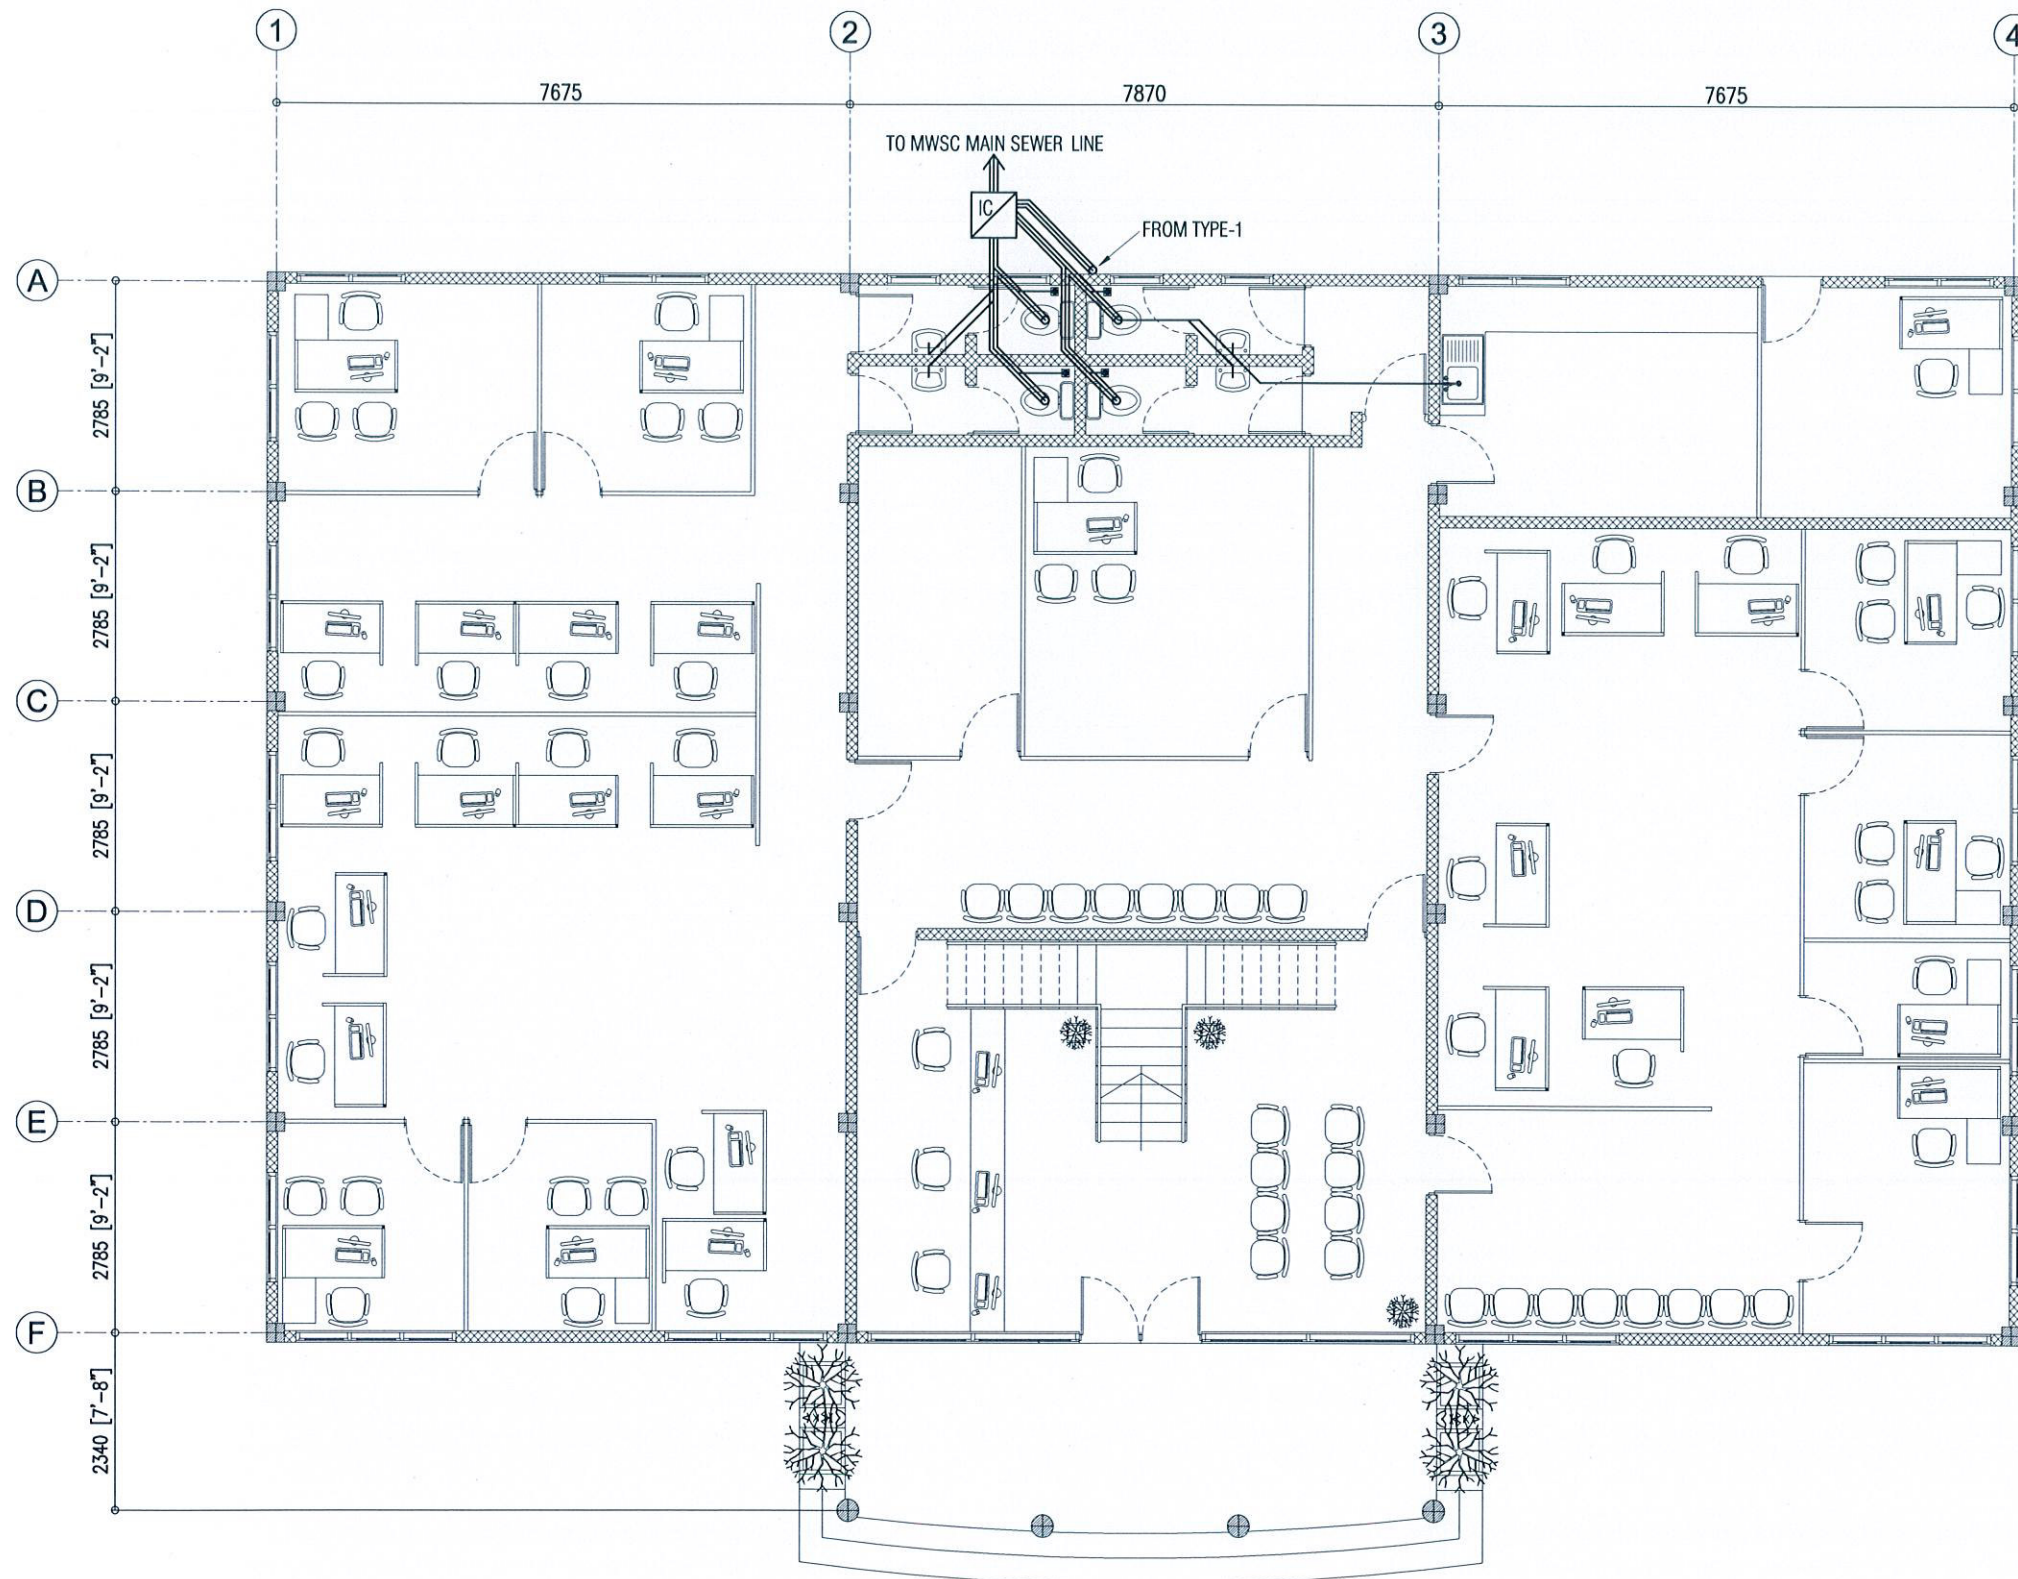

**GROUND FLOOR WASTE WATER LINE LAYOUT**  
**SCALE - 1:100**

REVISIONS:


PROJECT TITLE:  
**DHA. ATOLL COUNCIL**

CLIENT :  
 LGA

ARCH. DESIGN:	SHAMIN	PROJECT NO	DHC-11/15
STRUC. DESIGN:	ASHRAF	DRAWING NO	P2
DATE :	MAY 2015		
SCALE:	AS GIVEN		

**ALAAF**  
 ALAAF PRIVATE LIMITED  
 THARAKHIGE(GROUND FLOOR)BUDHERIYA MAGUMALE'20004,  
 TEL: (960)7773801, E-MAIL: alAAF.pvt@gmail.com,Web

COPYRIGHT: THE CONCEPT AND DESIGN IN THIS DRAWING ARE THE PROPERTIES OF ALAAF PVT. LTD. THIS DRAWING SHOULD BE USED ONLY FOR THE PROJECT MENTIONED ON THIS SHEET.

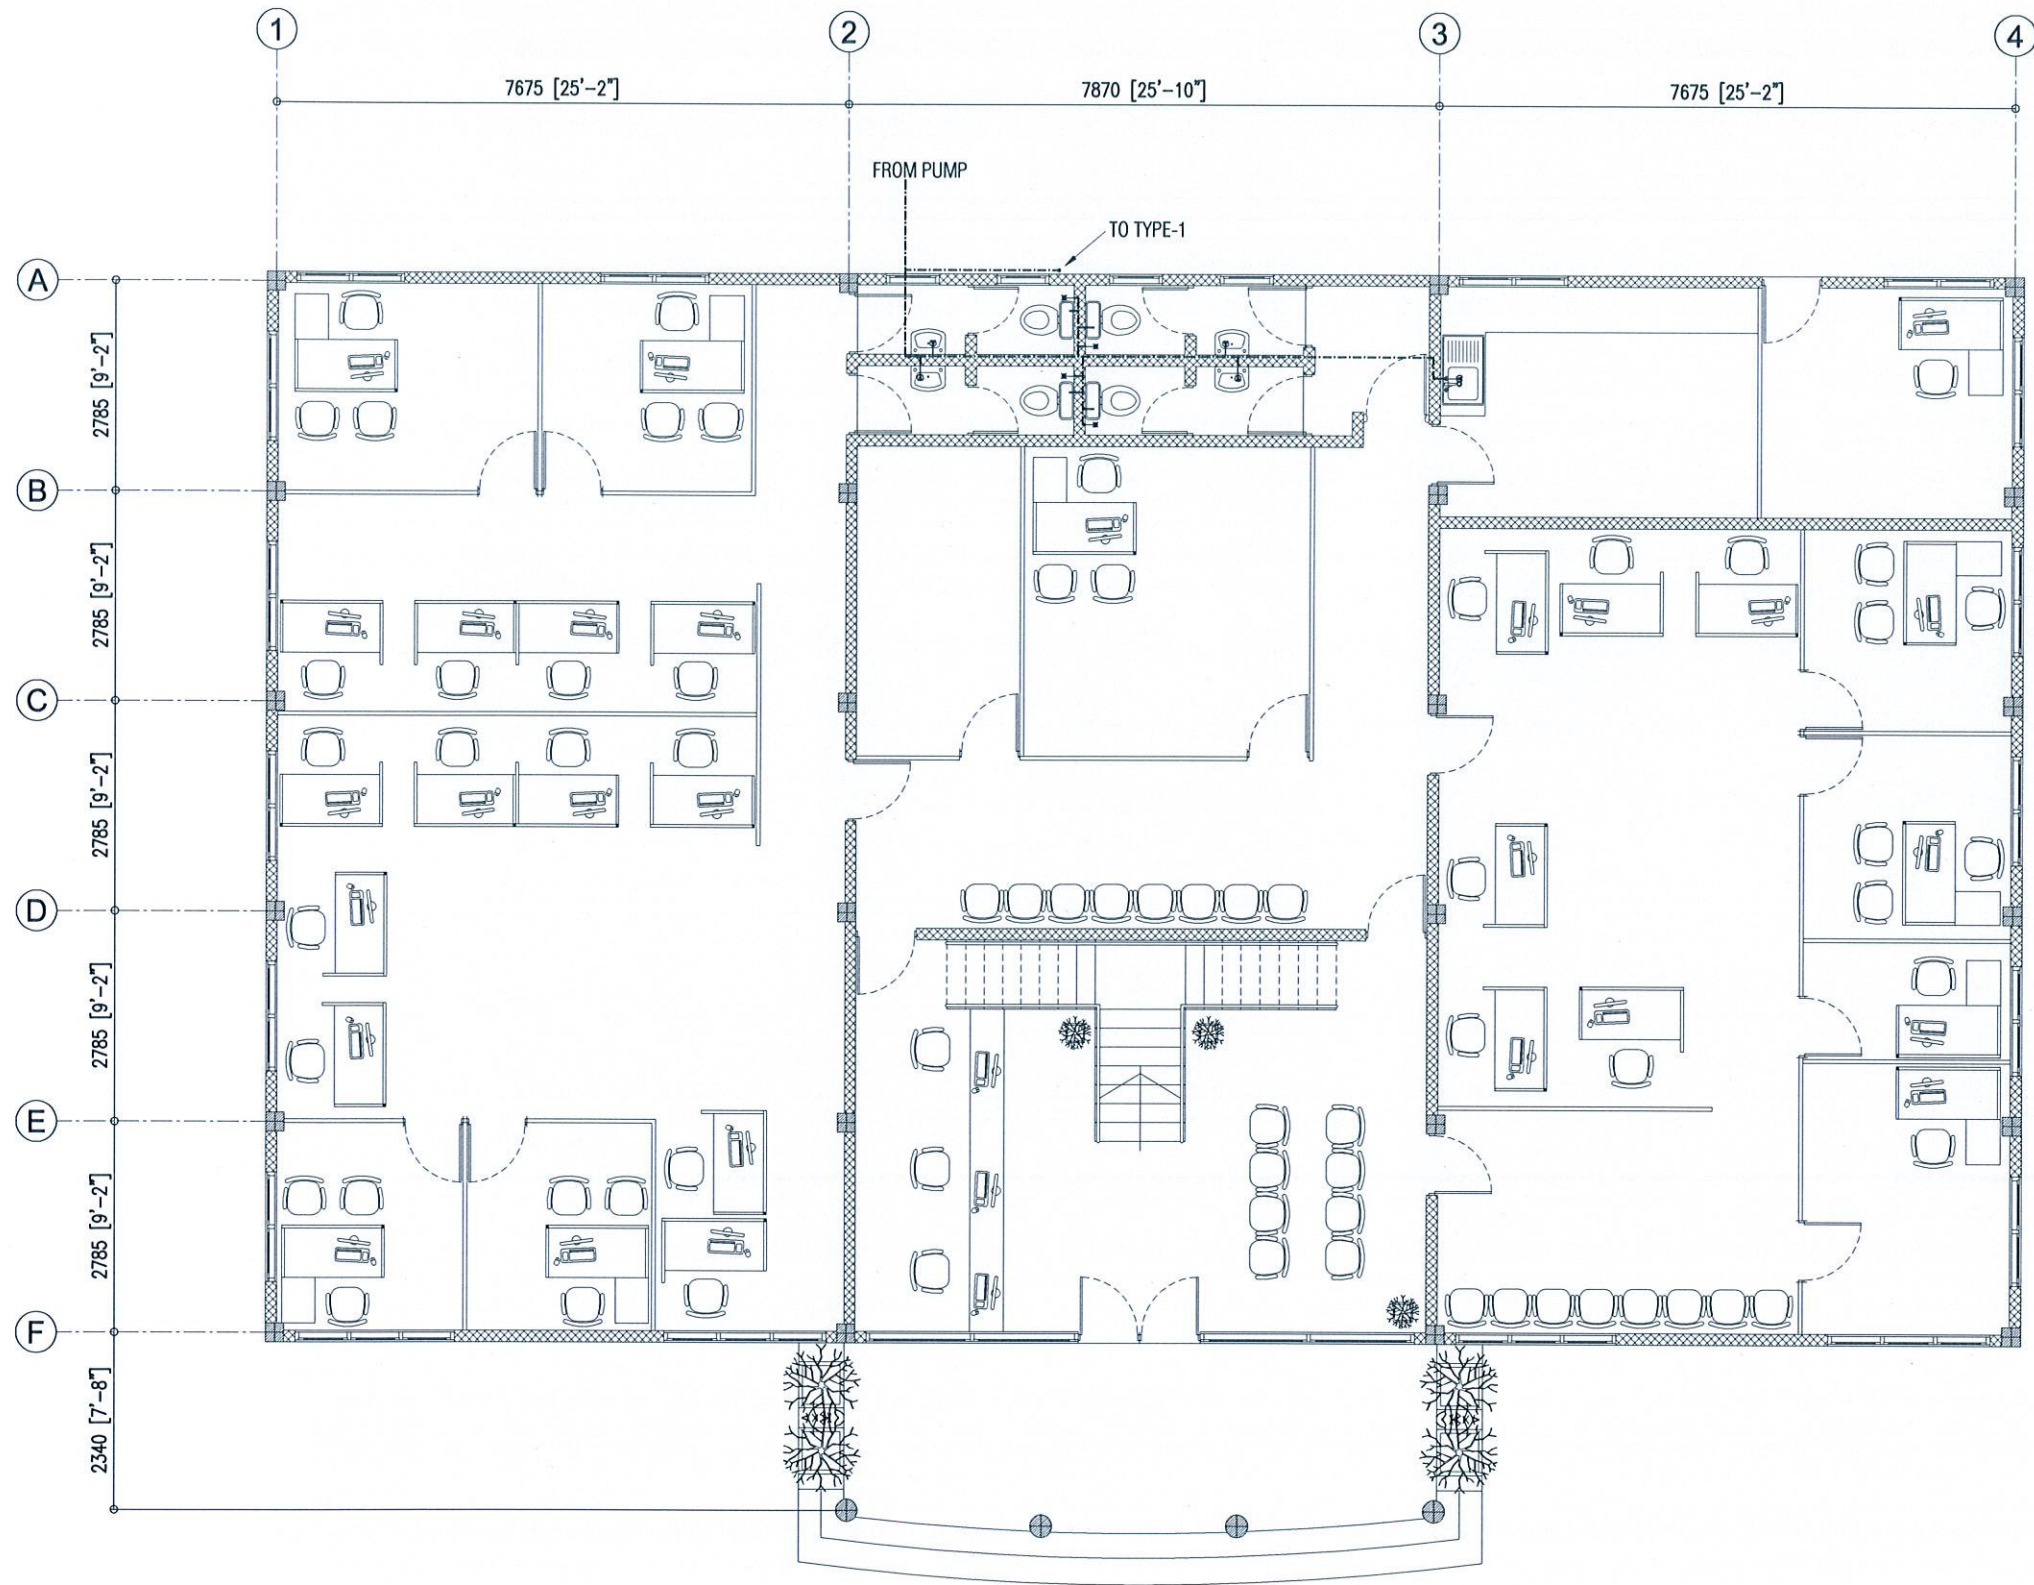

**GROUND FLOOR WELL WATER LINE LAYOUT**  
**SCALE - 1:100**

REVISIONS:


PROJECT TITLE:  
**DHA. ATOLL COUNCIL**

CLIENT:  
 LGA

ARCH. DESIGN:	SHAMIN	PROJECT NO	DHC-11/15
STRUC. DESIGN:	ASHRAF	DRAWING NO	P3
DATE:	MAY 2015		
SCALE:	AS GIVEN		

**ALAAF**  
 ALAAF PRIVATE LIMITED  
 THIRUVARHOOR(GROUND FLOOR)SABUDHERRYA WAGUJALE'20004,  
 TEL: (980)7773801, E-MAIL: alaaaf.pvt@gmail.com, Web

COPYRIGHT: THE CONCEPT AND DESIGN IN THIS DRAWING ARE THE PROPERTIES OF ALAAF PVT LTD. THIS DRAWING SHOULD BE USED ONLY FOR THE PROJECT MENTIONED ON THIS SHEET.

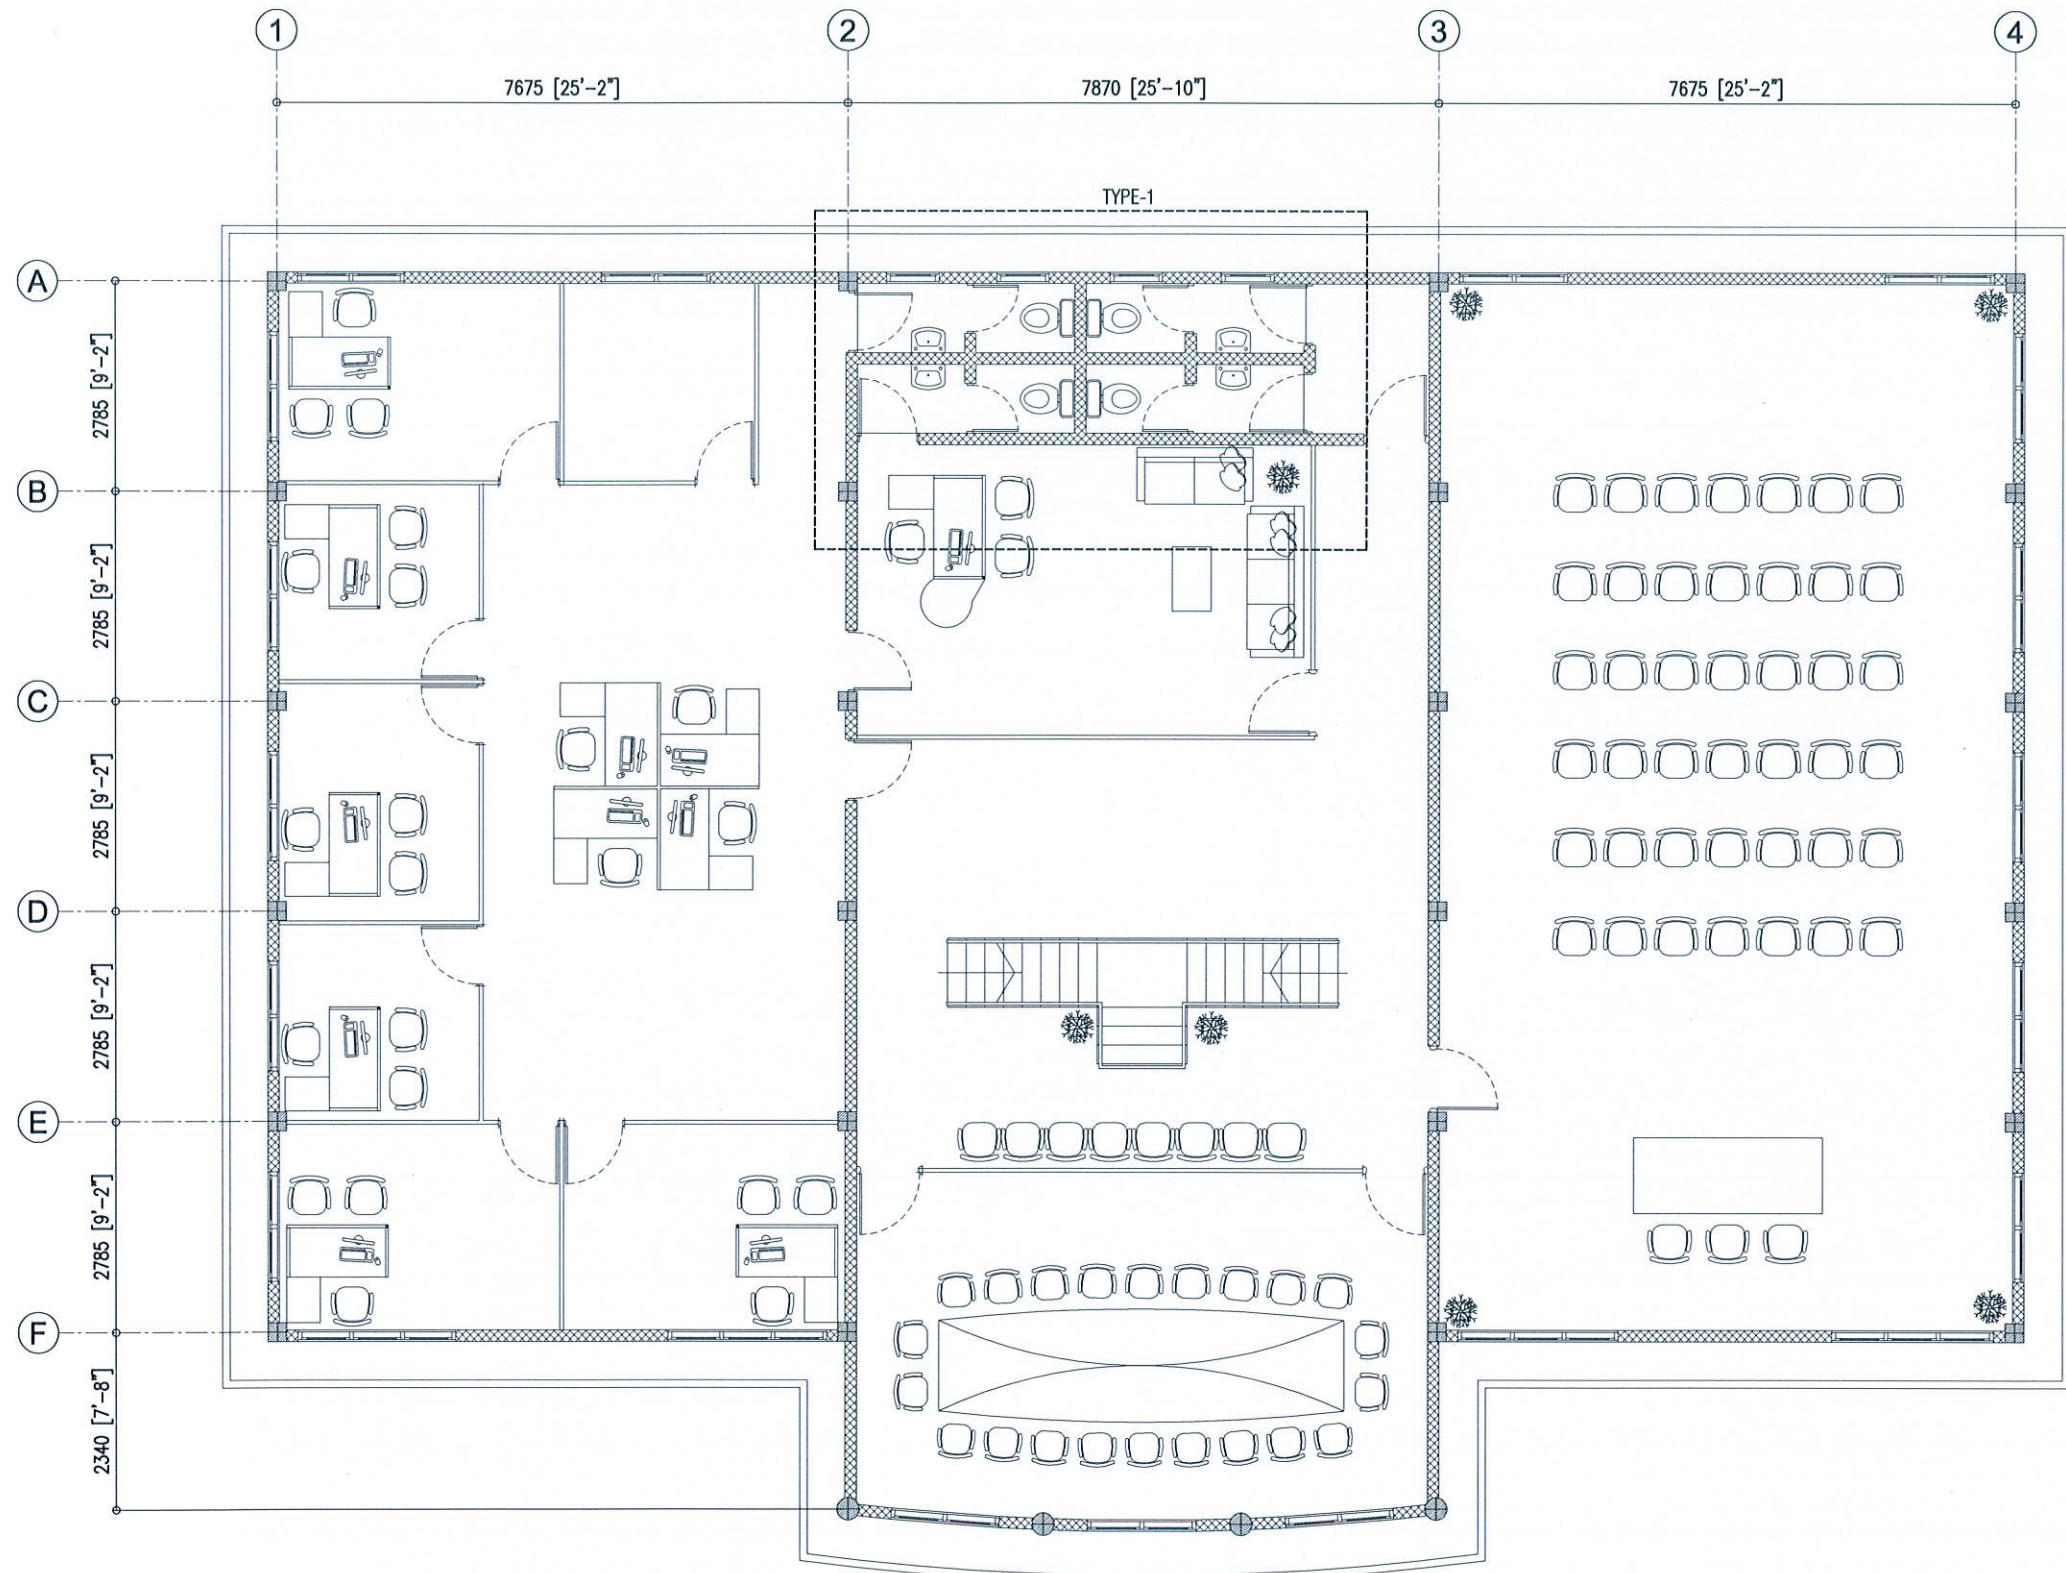

**1ST FLOOR KEY PLAN**  
SCALE - 1:100

REVISIONS:

PROJECT TITLE:  
**DHA. ATOLL COUNCIL**


CLIENT:  
LGA

ARCH. DESIGN:	SHAMIN	PROJECT NO	DHC-11/15
STRUC. DESIGN:	ASHRAF	DRAWING NO	P4
DATE:	MAY 2015		
SCALE:	AS GIVEN		

**ALAAF**  
ALAAF PRIVATE LIMITED  
THARUDHIGE(GROUND FLR)SABUDHERYA MAGU,MALE'20004,  
TEL: (960)7773601, E-MAIL: alAAF.pvt@gmail.com,Web

COPYRIGHT: THE CONCEPT AND DESIGN IN THIS DRAWING ARE THE PROPERTIES OF ALAAF PVT. LTD. THIS DRAWING SHOULD BE USED ONLY FOR THE PROJECT MENTIONED ON THIS SHEET.




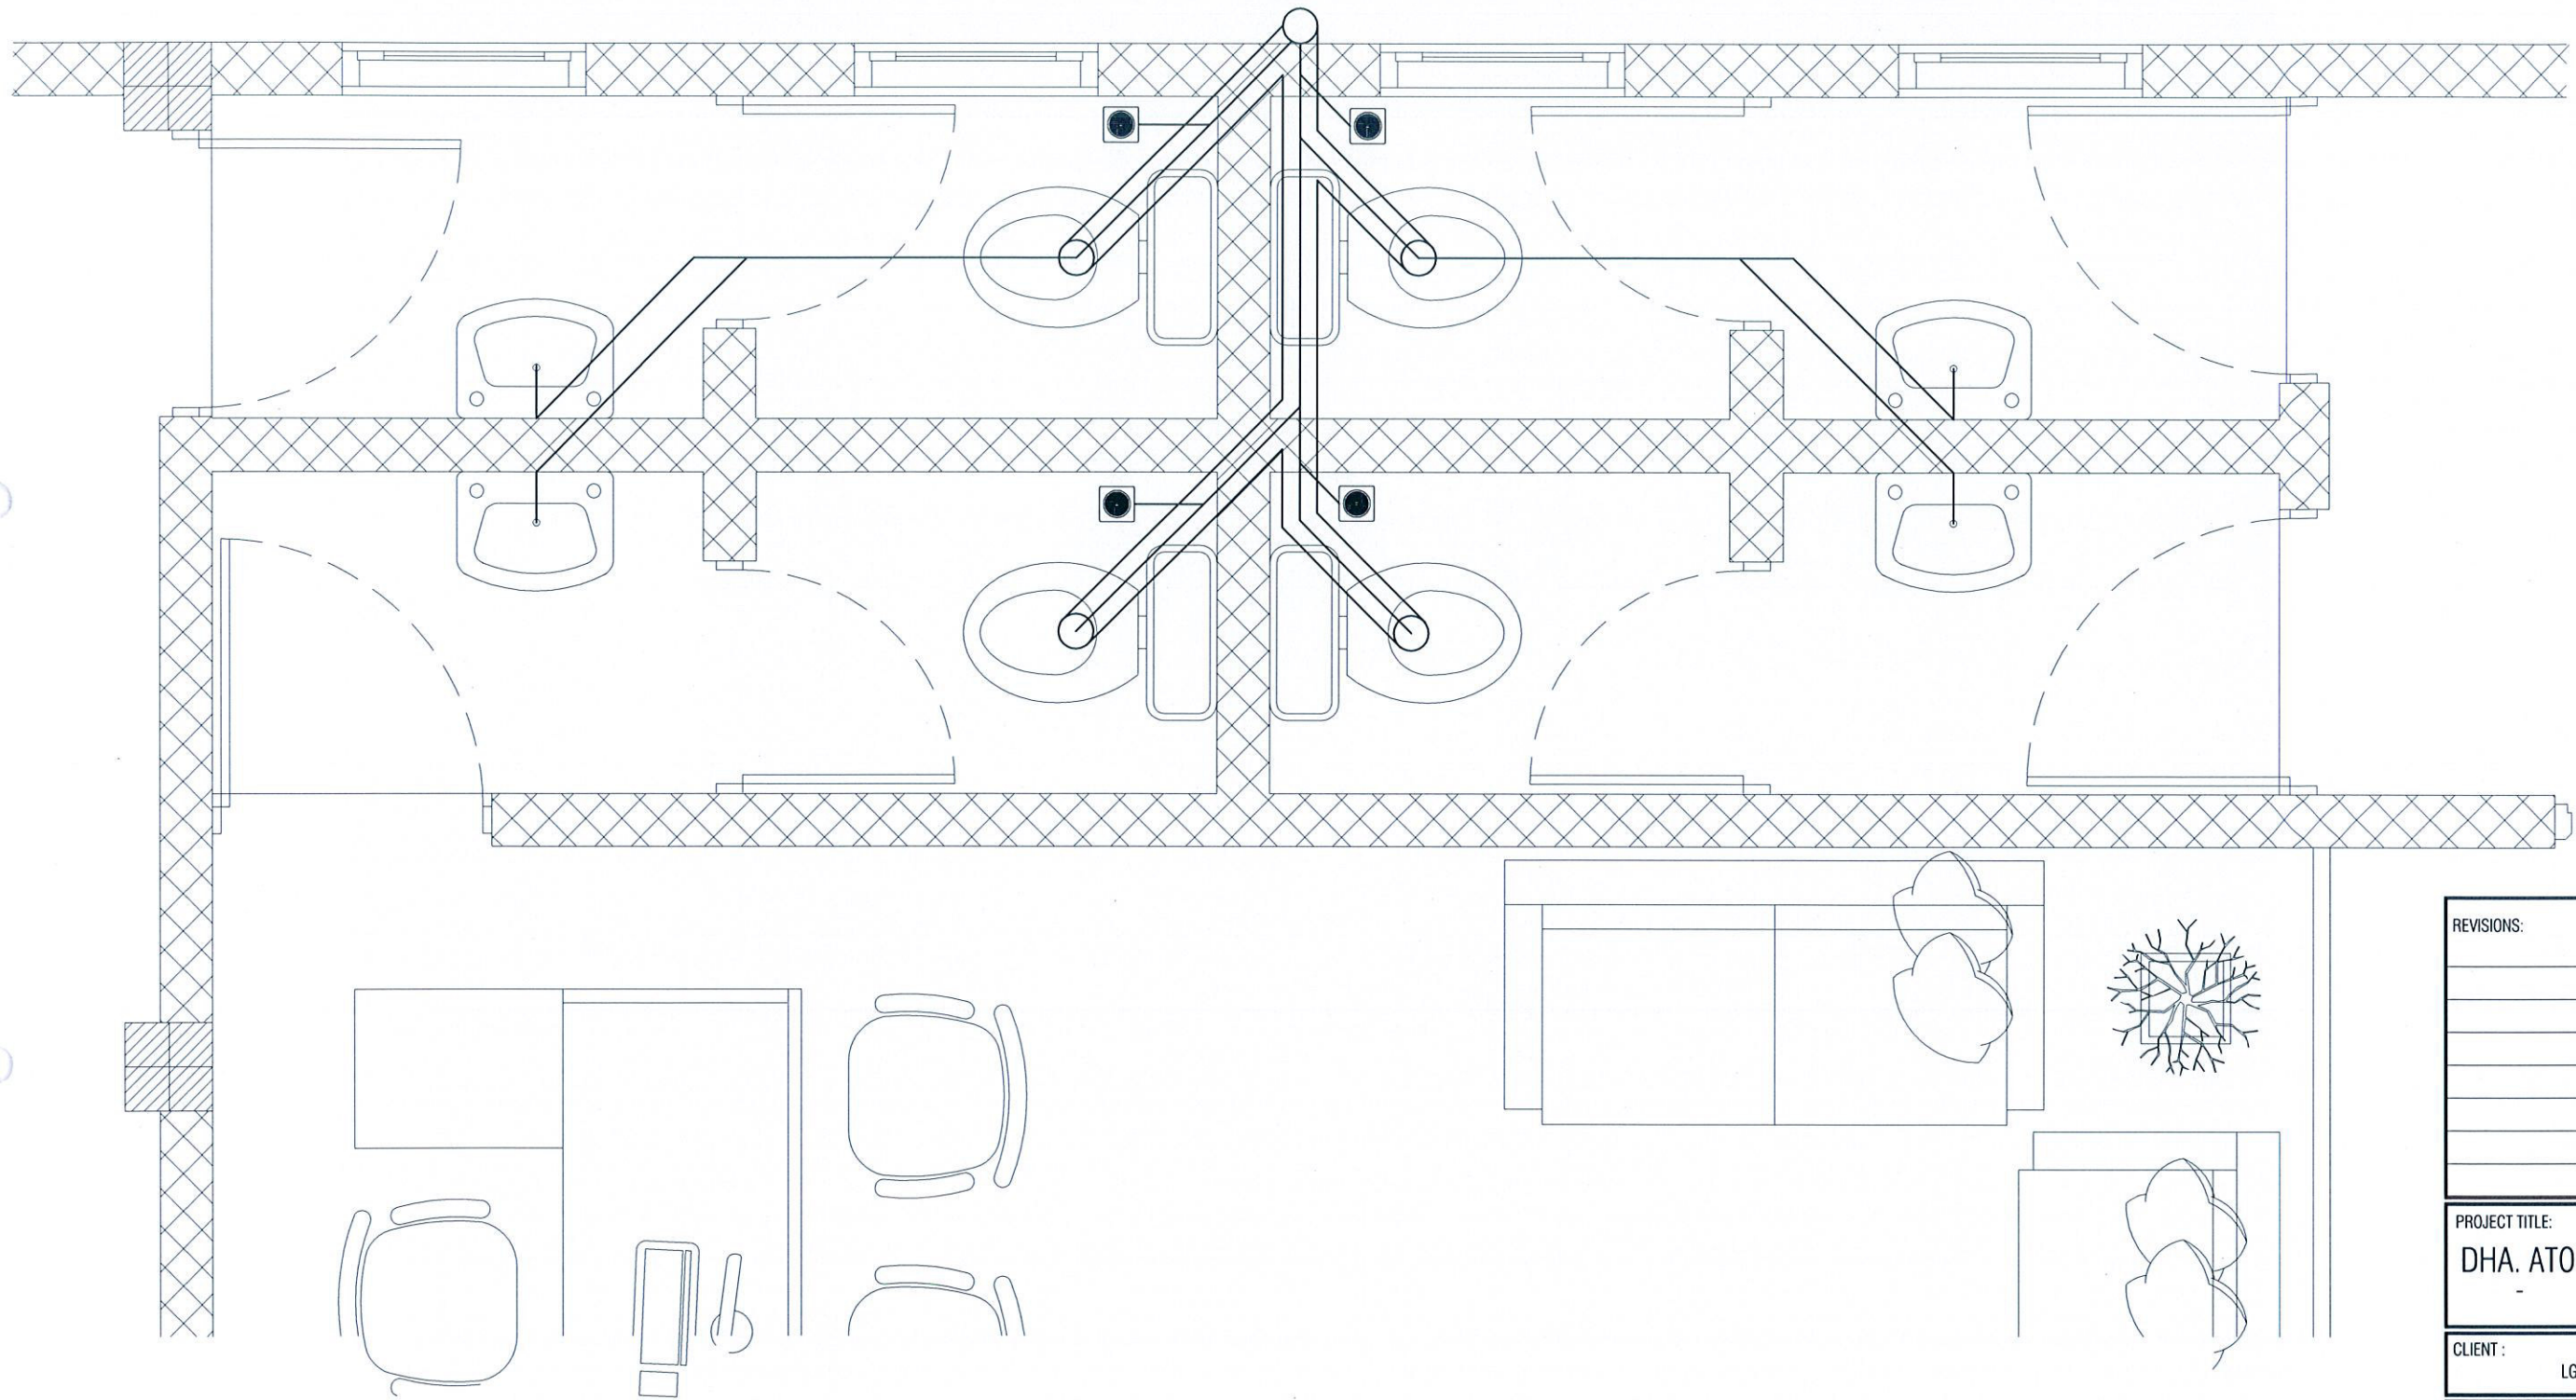

**WASTE WATER AND SEWAGE DISPOSAL LAYOUT - TYPE-1**  
**SCALE - 1:20**

REVISIONS:		
PROJECT TITLE:		
DHA. ATOLL COUNCIL		
CLIENT :		
LGA		
ARCH. DESIGN:	SHAMIN	PROJECT NO
STRUC. DESIGN:	ASHRAF	DHC-11/15
DATE :	MAY 2015	DRAWING NO
SCALE:	AS GIVEN	P5
<b>ALAAF</b> ALAAF PRIVATE LIMITED THARUKHOE(GROUND FLOOR)BUDHERYA WADJUMALE'20004, TEL: (960)7773001, E-MAIL: alaf.pvt@gmail.com,Web		

COPYRIGHT: THE CONCEPT AND DESIGN IN THIS DRAWING ARE THE PROPERTIES OF ALAAF PVT LTD. THIS DRAWING SHOULD BE USED ONLY FOR THE PROJECT MENTIONED ON THIS SHEET.

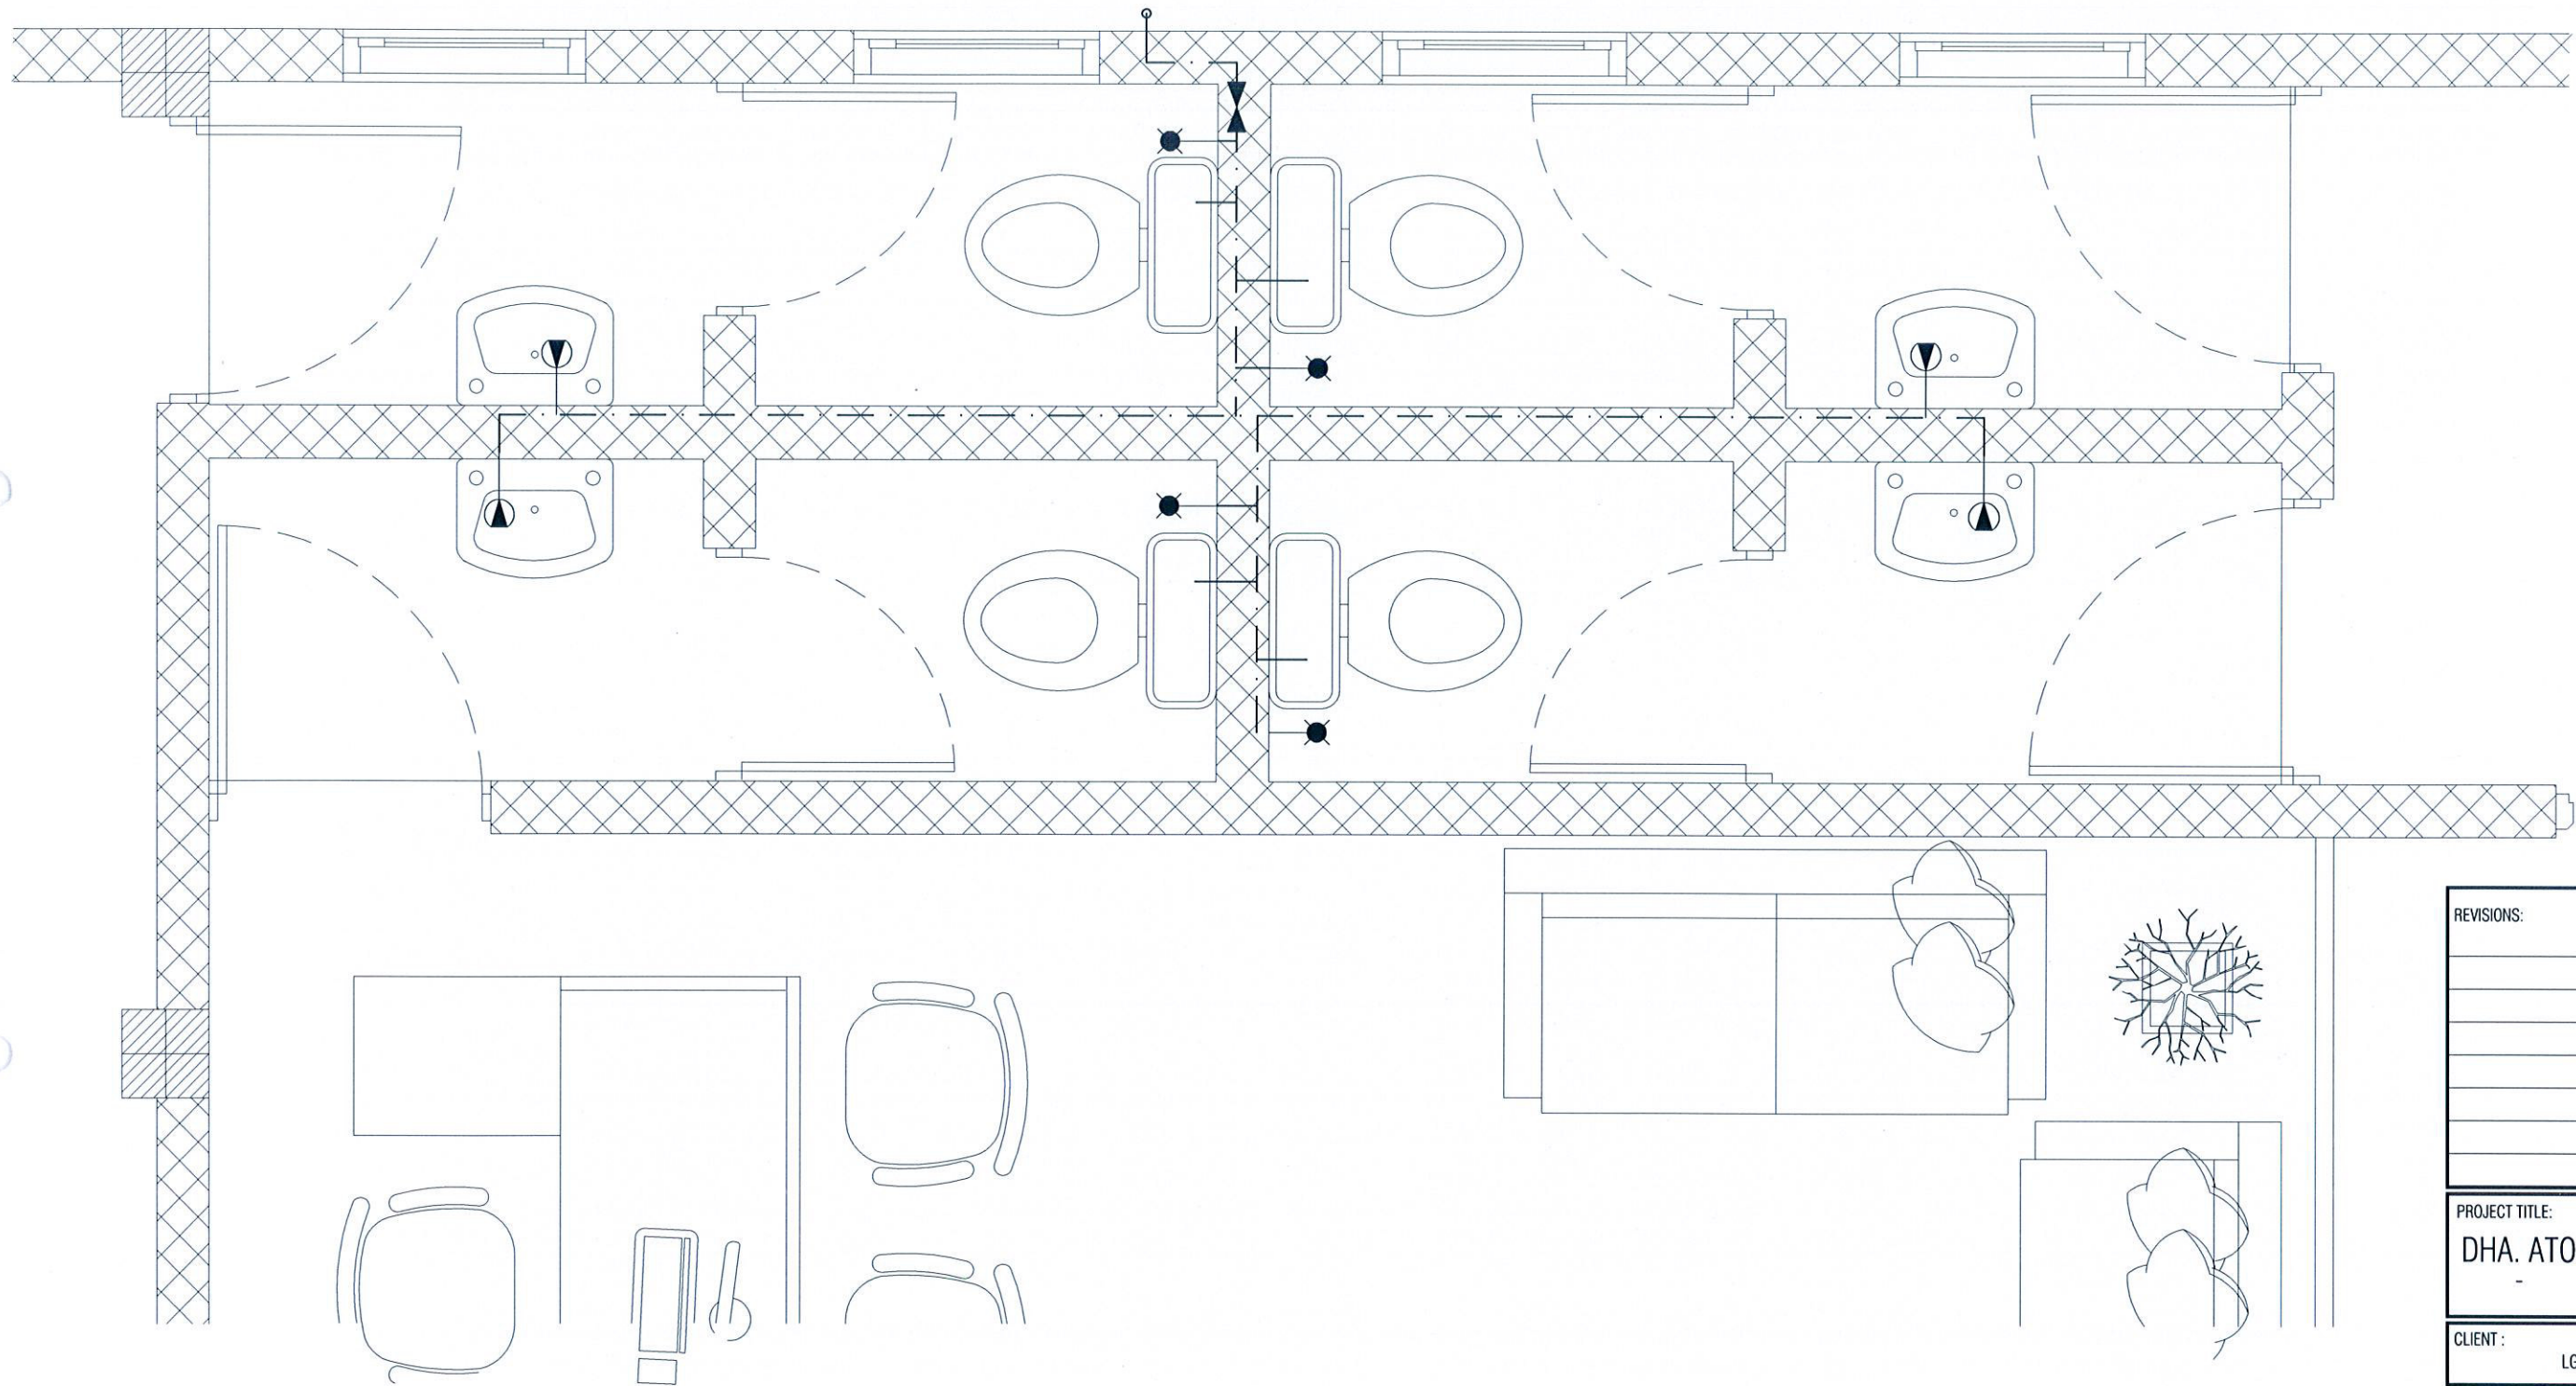

**GROUND WATER SUPPLY LAYOUT - TYPE-1**  
**SCALE - 1:20**

REVISIONS:

PROJECT TITLE:  
**DHA. ATOLL COUNCIL**

CLIENT :  
 LGA

ARCH. DESIGN:	SHAMIN	PROJECT NO	DHC-11/15
STRUC. DESIGN:	ASHRAF	DRAWING NO	P6
DATE:	MAY 2015		
SCALE:	AS GIVEN		

**ALAAF**  
 ALAAF PRIVATE LIMITED  
 THARUWEGE(GROUND FLR)SABUDHERYA MAGUMALE'20004,  
 TEL: (960)7773601, E-MAIL: alAAF.pvt@gmail.com, Web

COPYRIGHT: THE CONCEPT AND DESIGN IN THIS DRAWING ARE THE PROPERTIES OF ALAAF PVT LTD. THIS DRAWINGS SHOULD BE USED ONLY FOR THE PROJECT MENTIONED ON THIS SHEET.