


**SITE PLAN**  
SCALE: 1 : 100

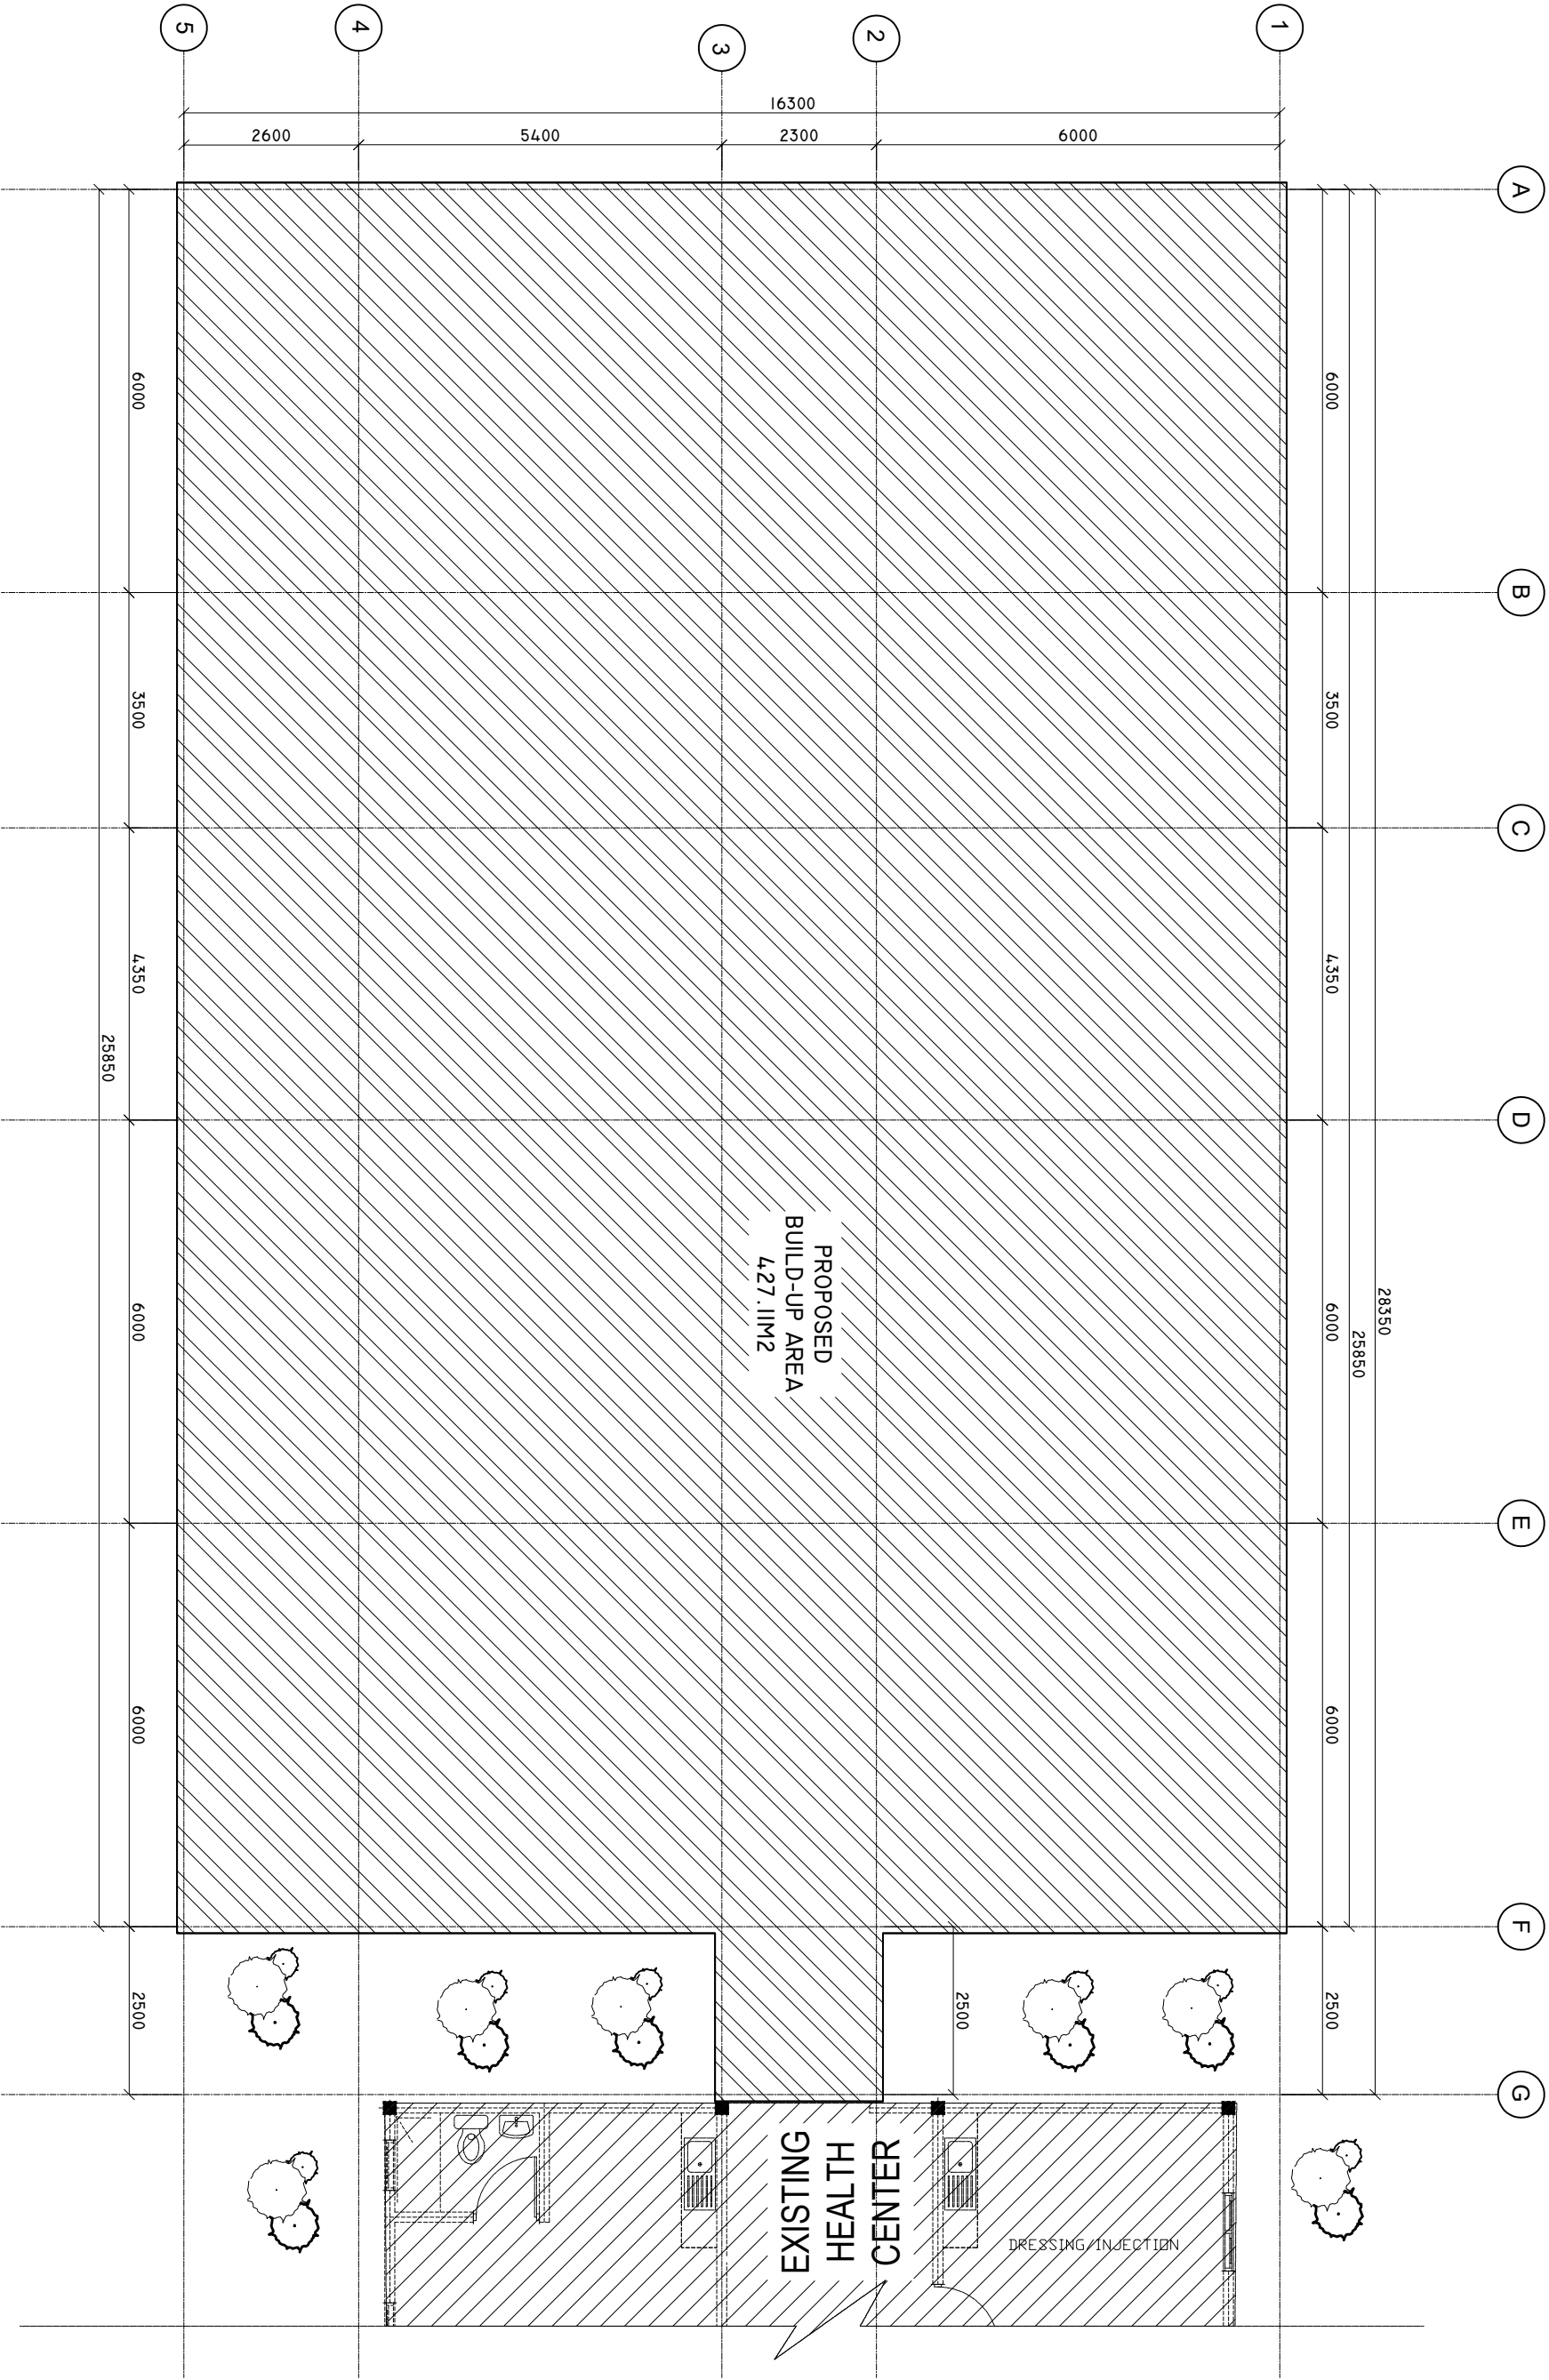

SHEET CONTENTS :

REVISION NOTES:

PROJECT:  
HEALTH CENTER  
EXTENSION BUILDING  
TYPE - B

CLIENT:  
MINISTRY OF HEALTH

LOCATION:  
DIFFERENT ISLAND

CONTENTS: AS GIVEN

PROJECT MANAGER:

DESIGNER: ARIZ

CIV/STR. ENGINEER:

SURVEYED BY: -

DRAWN BY: ARIZ

CHECKED BY:

DATE : APRIL 2025

SHEET NO. : 00/00

PAPER SIZE: A3



Infrastructure Development Unit  
Ministry of Health  
Resthouse Building  
Sosun Alaga  
Tel: 332 8887, Fax: 3328889  
Email: projects@health.gov.mv


SCALE: 1 : 100



*Infrastructure Development Unit  
Ministry of Health  
Roshanee Building  
Sosun Magu'  
Tel: 332 8887, Fax: 3328889  
Email: [projects@health.gov.mv](mailto:projects@health.gov.mv)*

ROOF PLAN


SCALE: 1 : 100

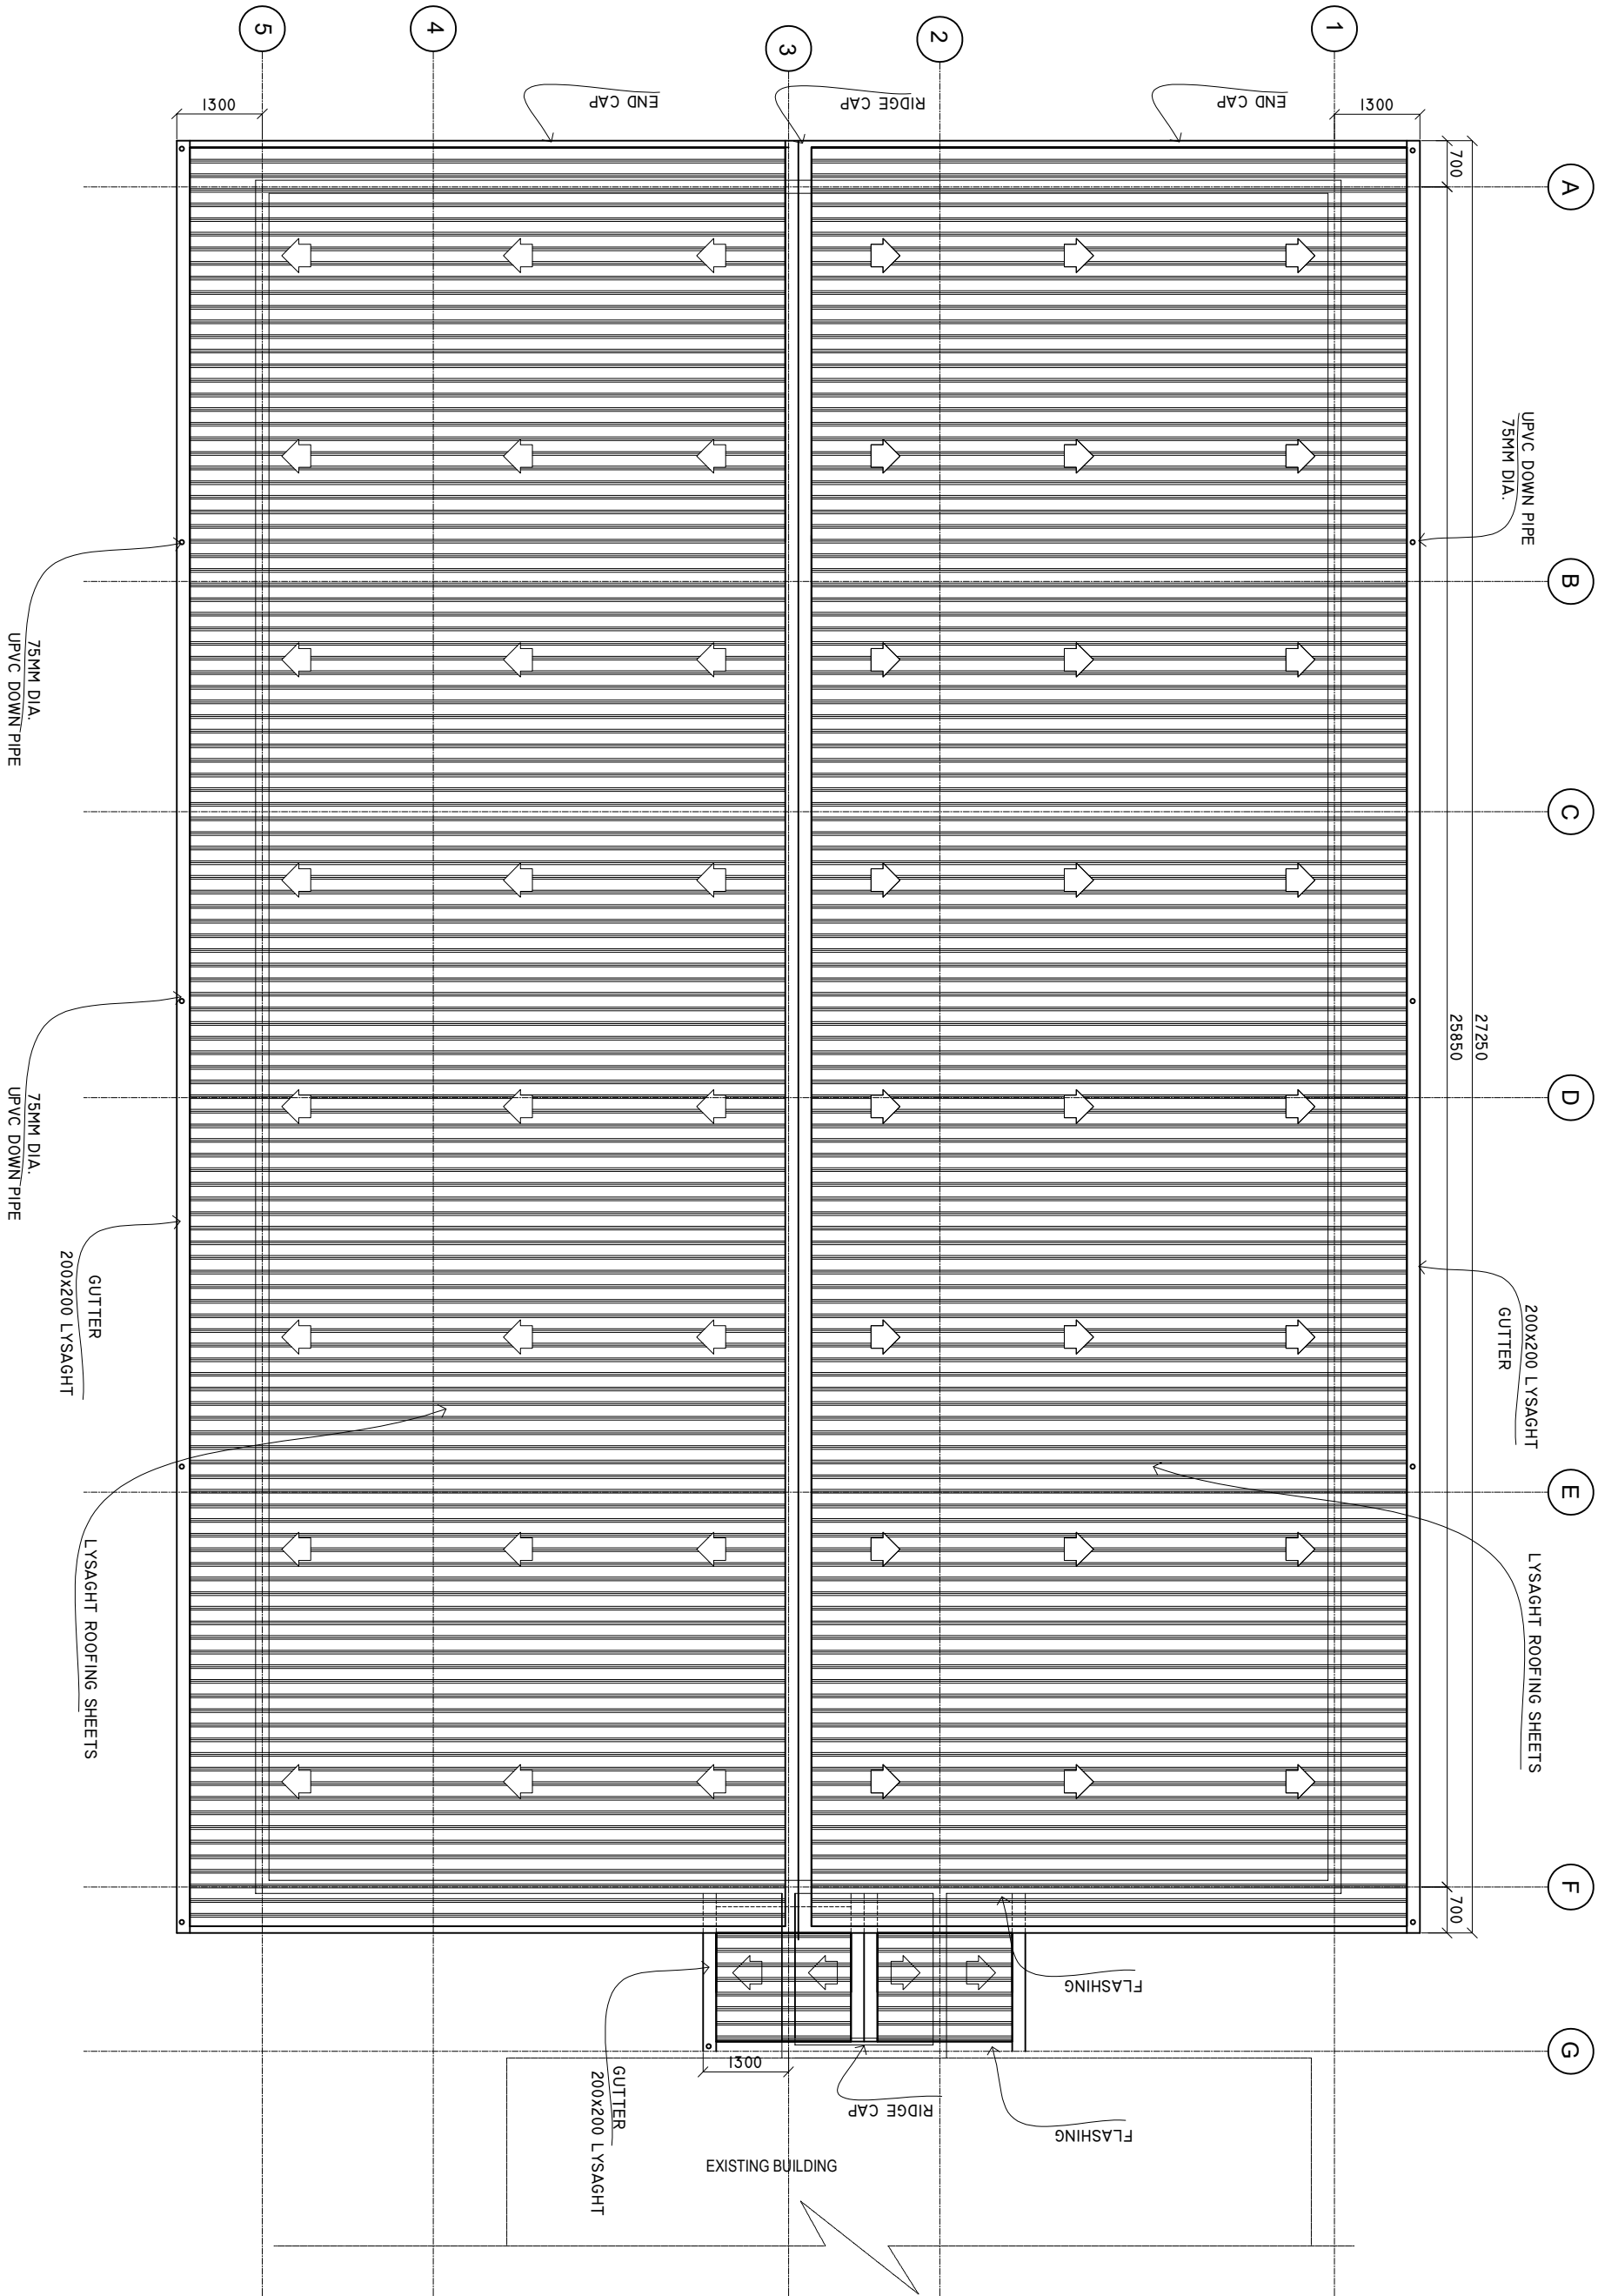

SHEET CONTENTS :	
REVISION NOTES:	
PROJECT: HEALTH CENTER EXTENSION BUILDING TYPE - B	
CLIENT: MINISTRY OF HEALTH	
LOCATION: DIFFERENT ISLAND	
CONTENTS: AS GIVEN	
PROJECT MANAGER:	
DESIGNER: ARIZ	
CIV/STR. ENGINEER:	
SURVEYED BY: -	
DRAWN BY: ARIZ	
CHECKED BY:	
DATE : APRIL 2025	
SHEET NO. : 00/00	
PAPER SIZE: A3	

# ROOF FRAMING PLAN

SCALE: 1 : 100

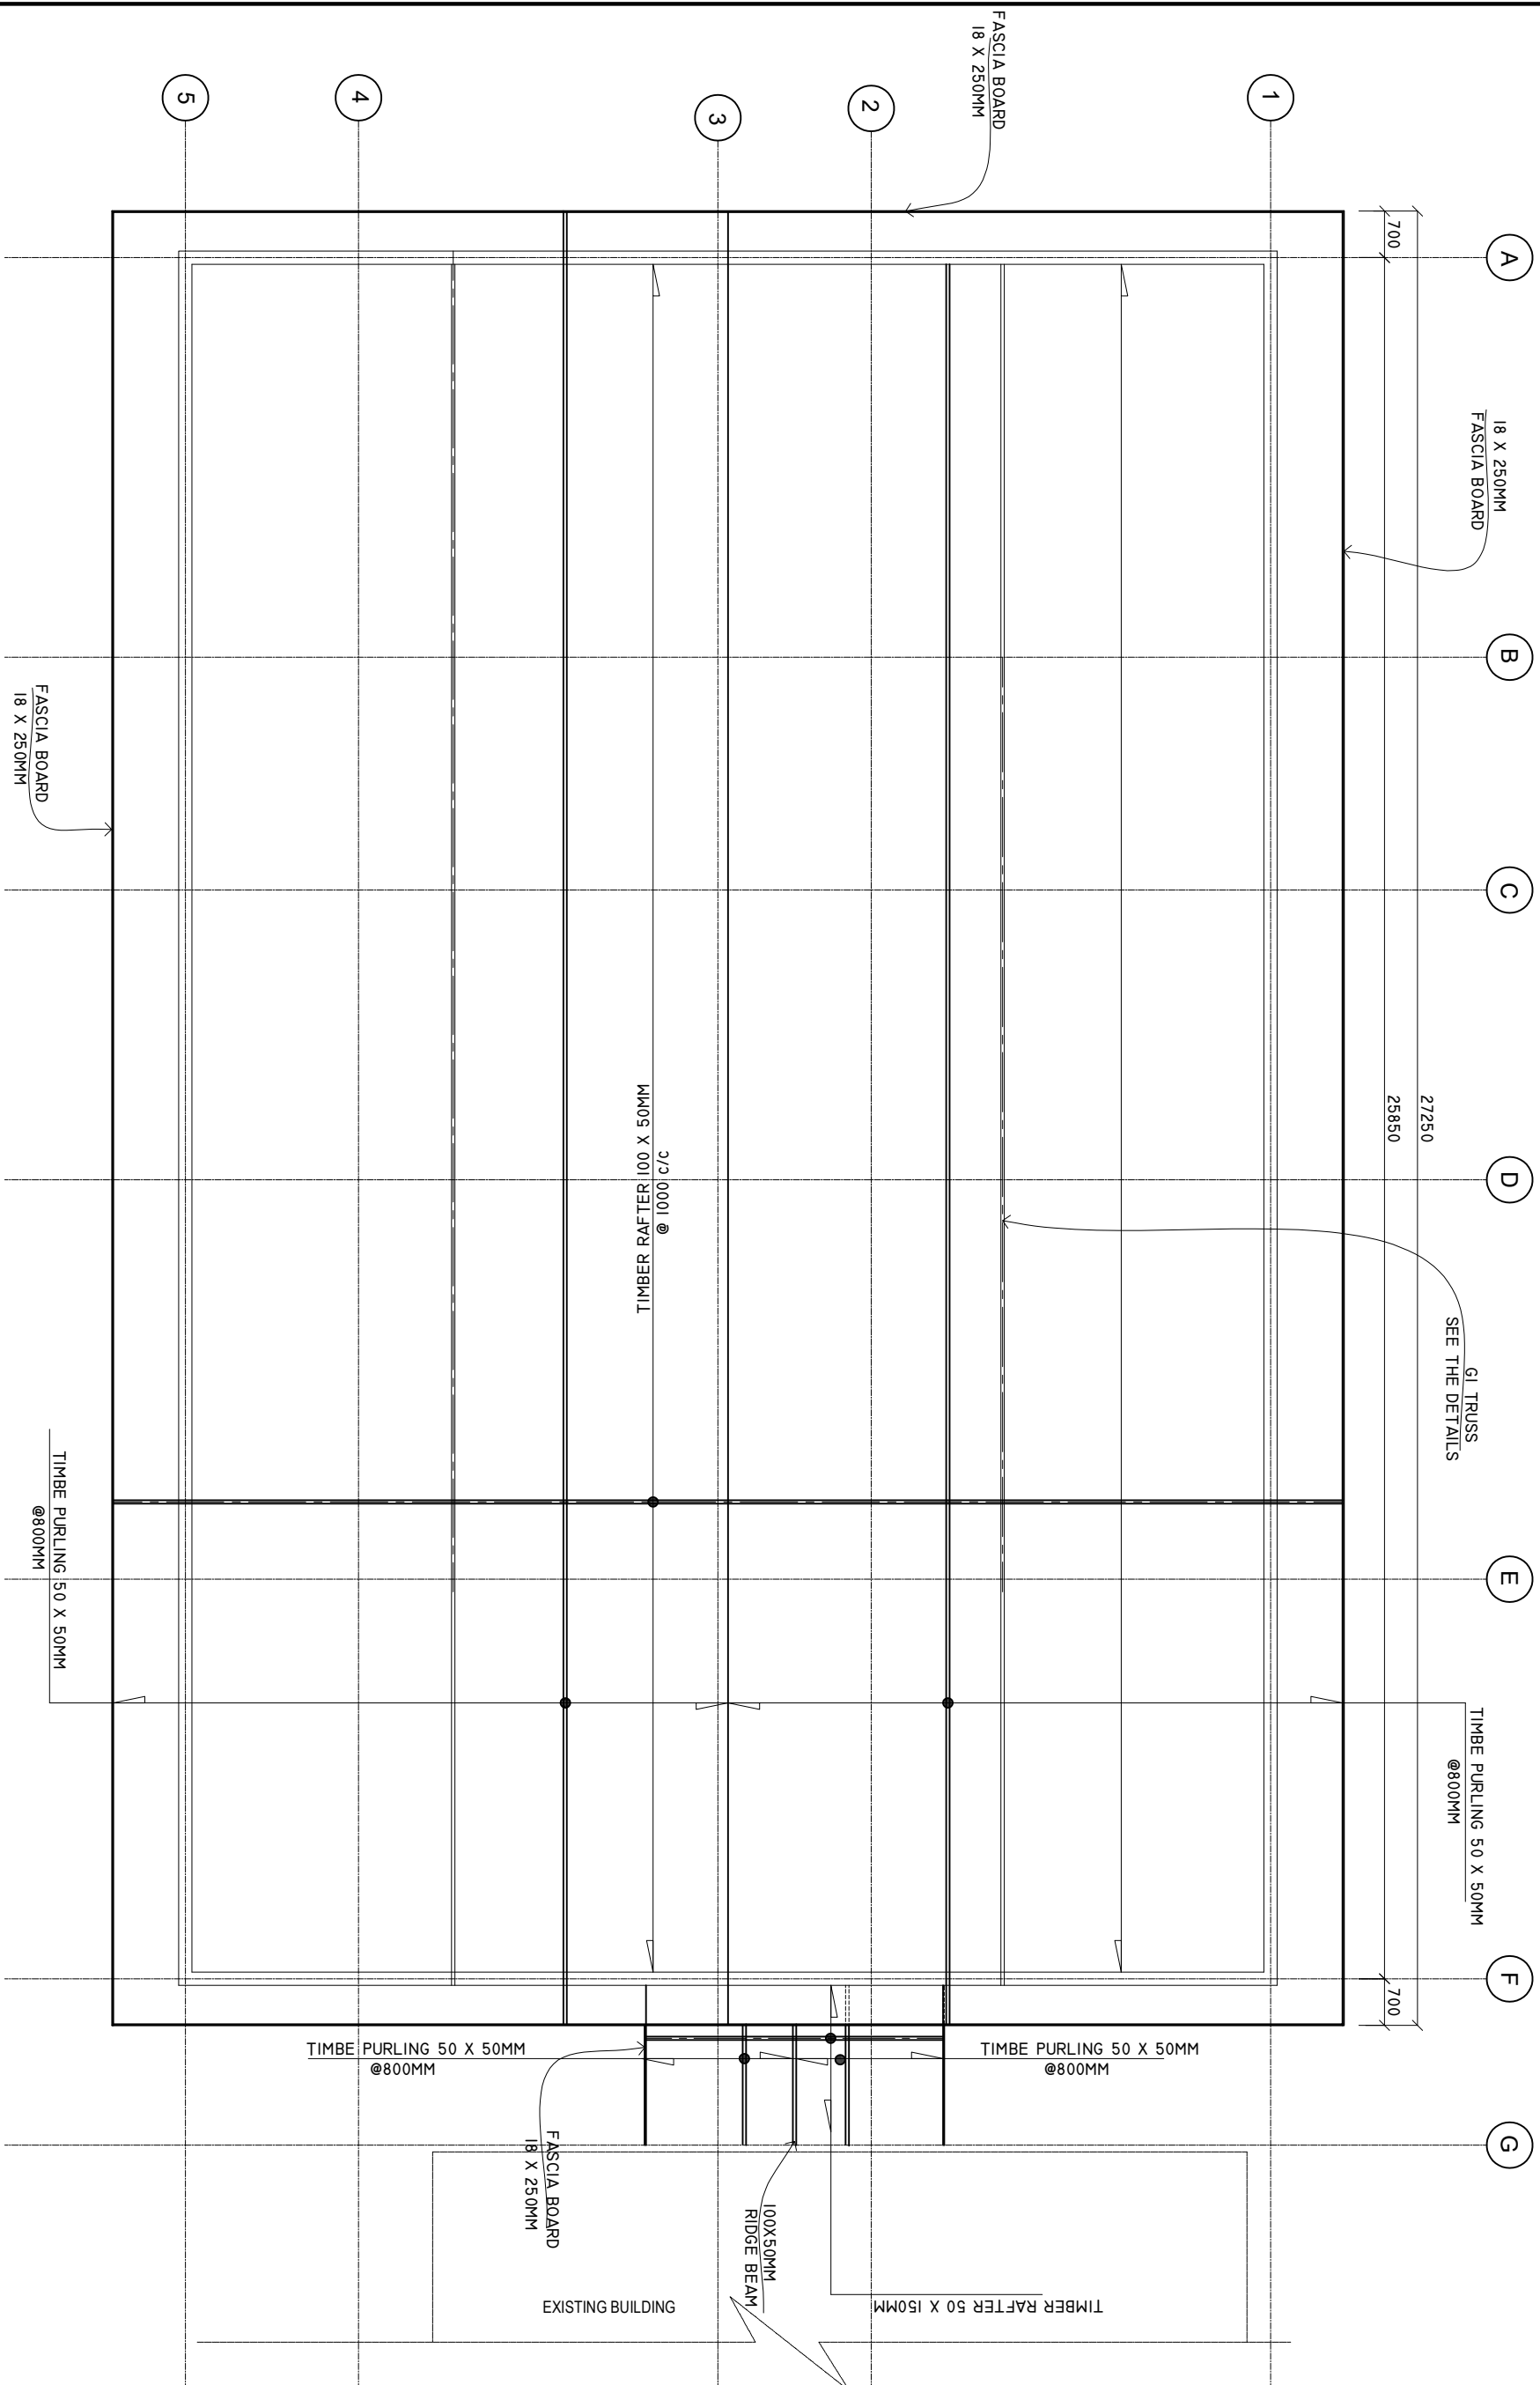

SHEET CONTENTS :
PROJECT:
HEALTH CENTER EXTENSION BUILDING TYPE - B
CLIENT:
MINISTRY OF HEALTH
LOCATION:
DIFFERENT ISLAND
CONTENTS: <i>AS GIVEN</i>
PROJECT MANAGER:
DESIGNER: <i>ARIZ</i>
CIV/STR. ENGINEER:
SURVEYED BY: -
DRAWN BY: <i>ARIZ</i>
CHECKED BY:
DATE : <i>APRIL 2025</i>
SHEET NO. : <i>00/00</i>
PAPER SIZE: <b>A3</b>




*Infrastructure Development Unit  
Ministry of Health  
Roshanee Building  
Sosun Magi'  
Tel: 332 8887, Fax: 3328889  
Email: [projects@health.gov.mv](mailto:projects@health.gov.mv)*



WALL DETAILS BELOW FLOOR SLAB

SCALE: 1 : 100

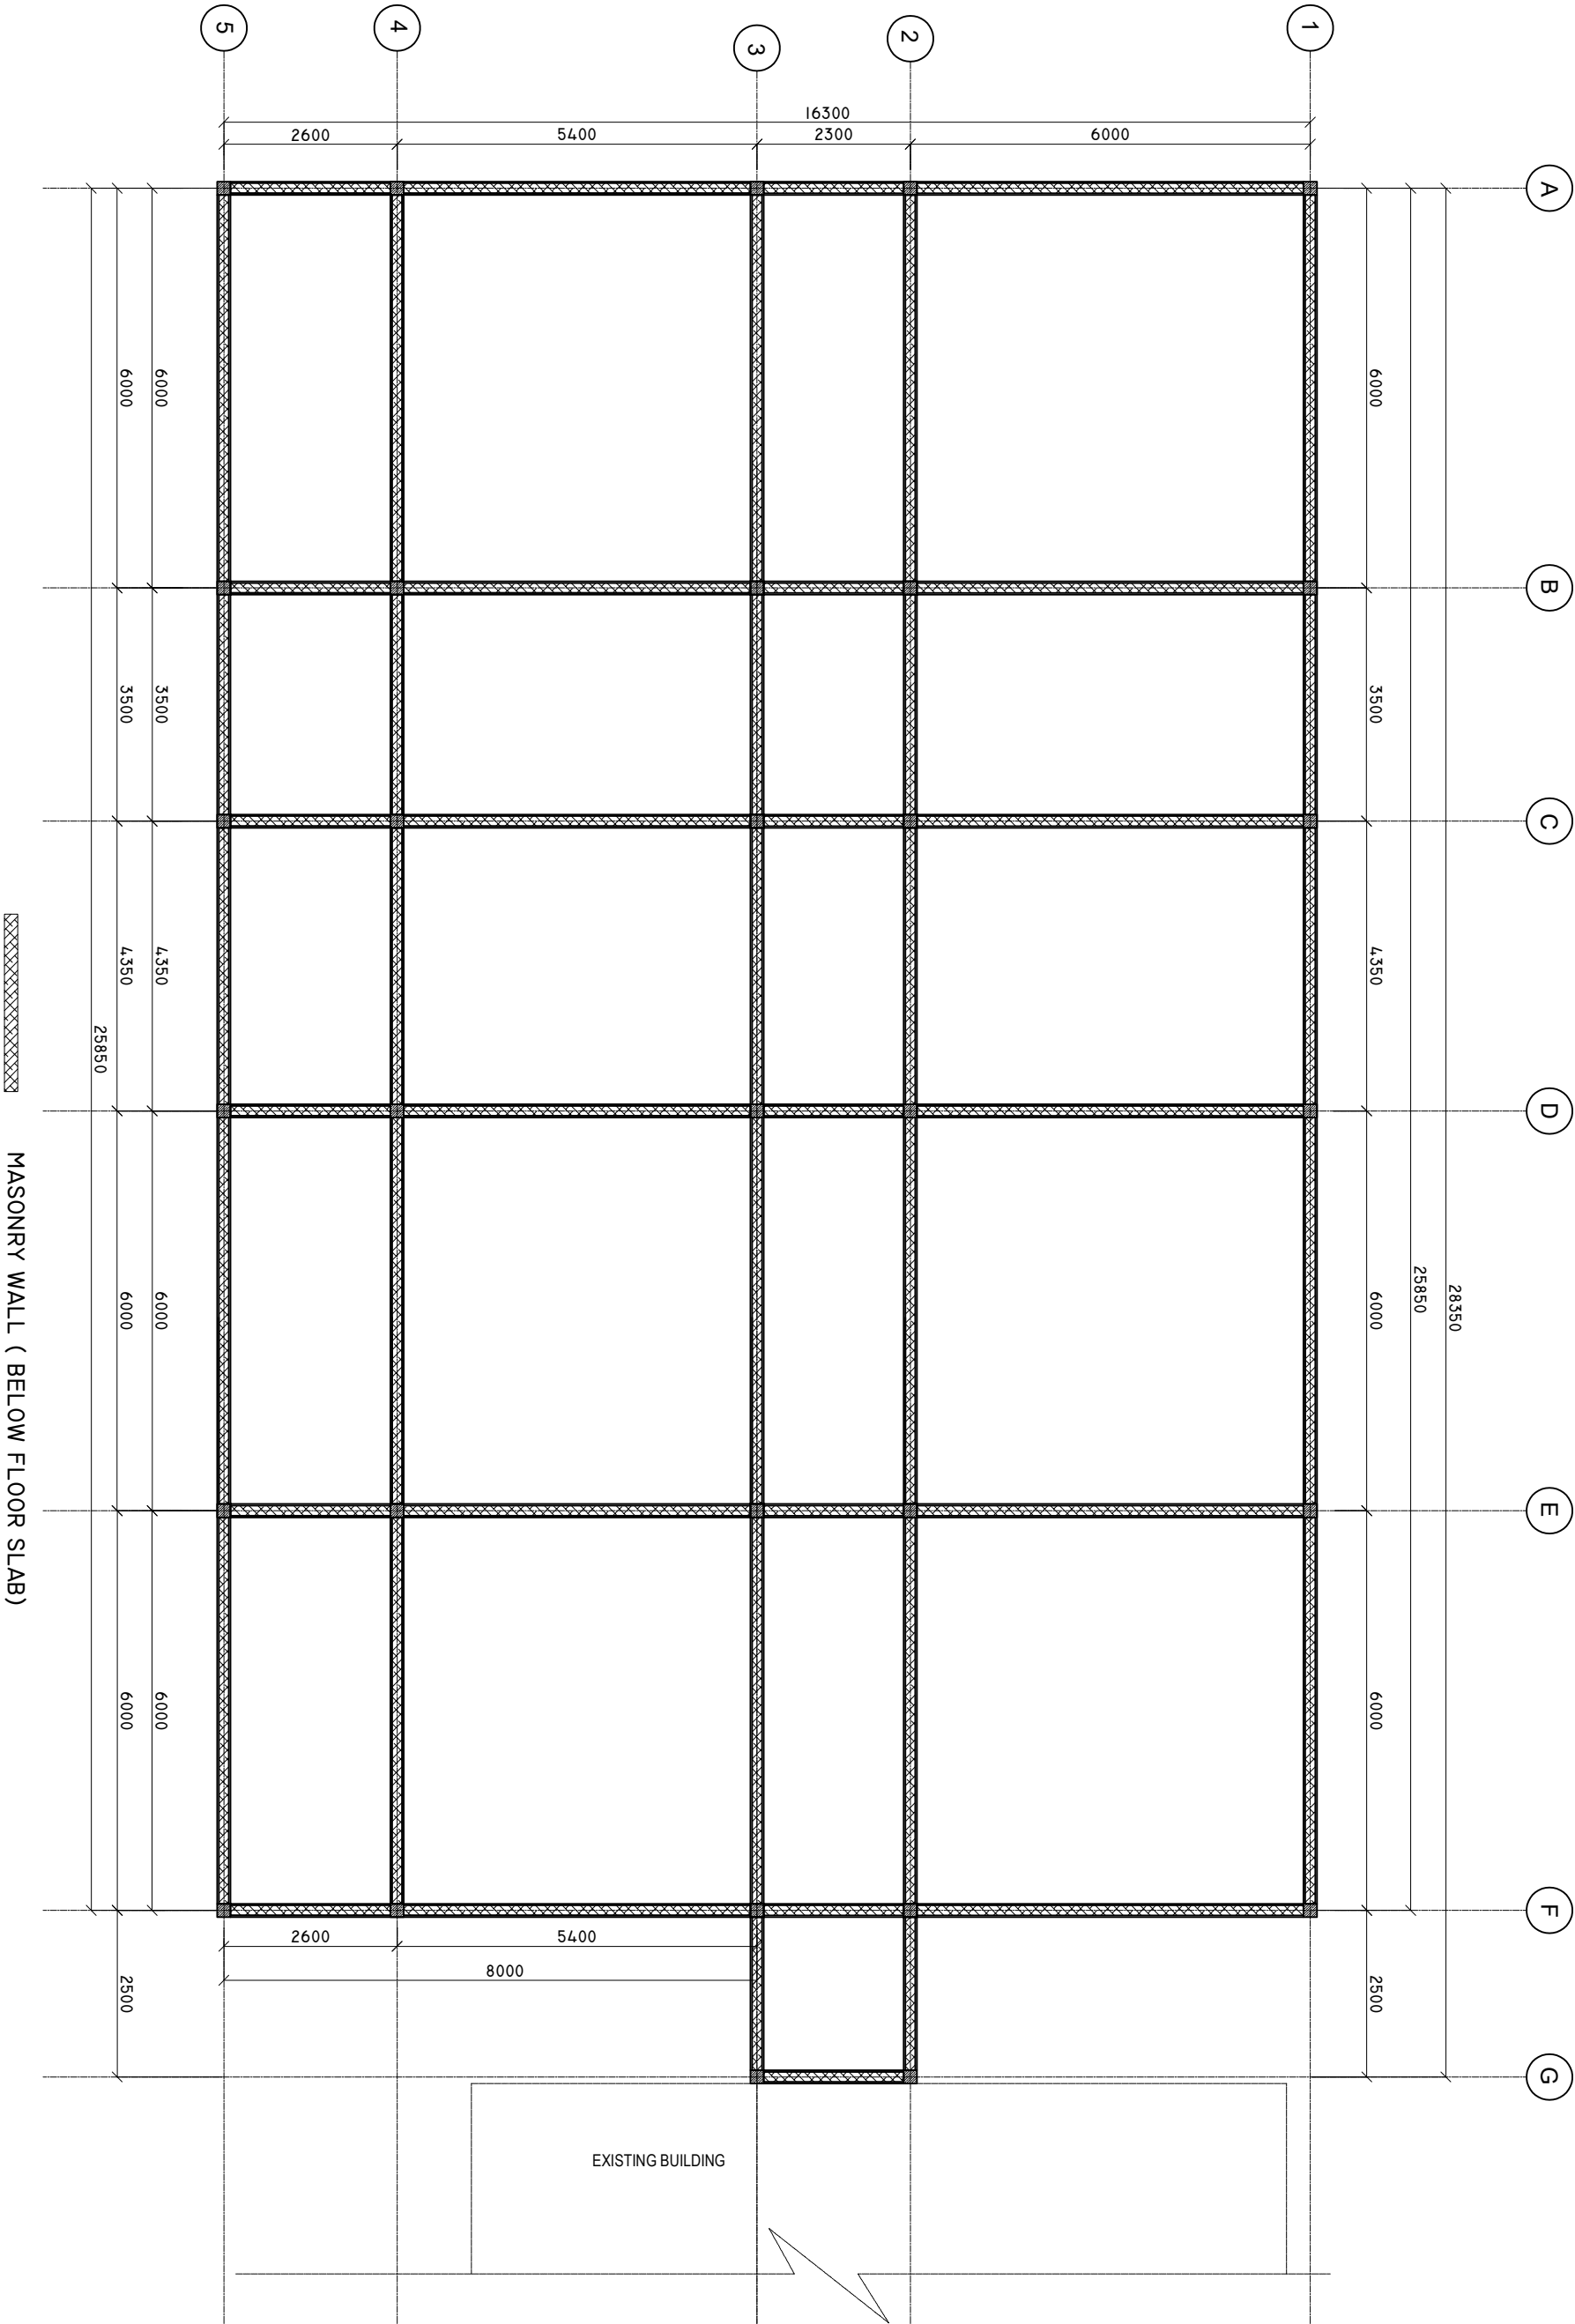

SHEET CONTENTS :

REVISION NOTES:

PROJECT:  
HEALTH CENTER  
EXTENSION BUILDING  
TYPE - B

CLIENT:  
MINISTRY OF HEALTH

LOCATION:  
DIFFERENT ISLAND

CONTENTS: AS GIVEN


PROJECT MANAGER:  
DESIGNER: ARIZ  
CIV/STR. ENGINEER:  
SURVEYED BY: -  
DRAWN BY: ARIZ  
CHECKED BY:  
DATE : APRIL 2025  
SHEET NO. : 00/00  
PAPER SIZE: A3



Infrastructure Development Unit  
Ministry of Health  
Residence Building  
Sossun Alaga  
Tel: 332 8887, Fax: 3328889  
Email: projects@health.gov.mv

WALL DETAILS ABOVE FLOOR SLAB

SCALE: 1 : 100

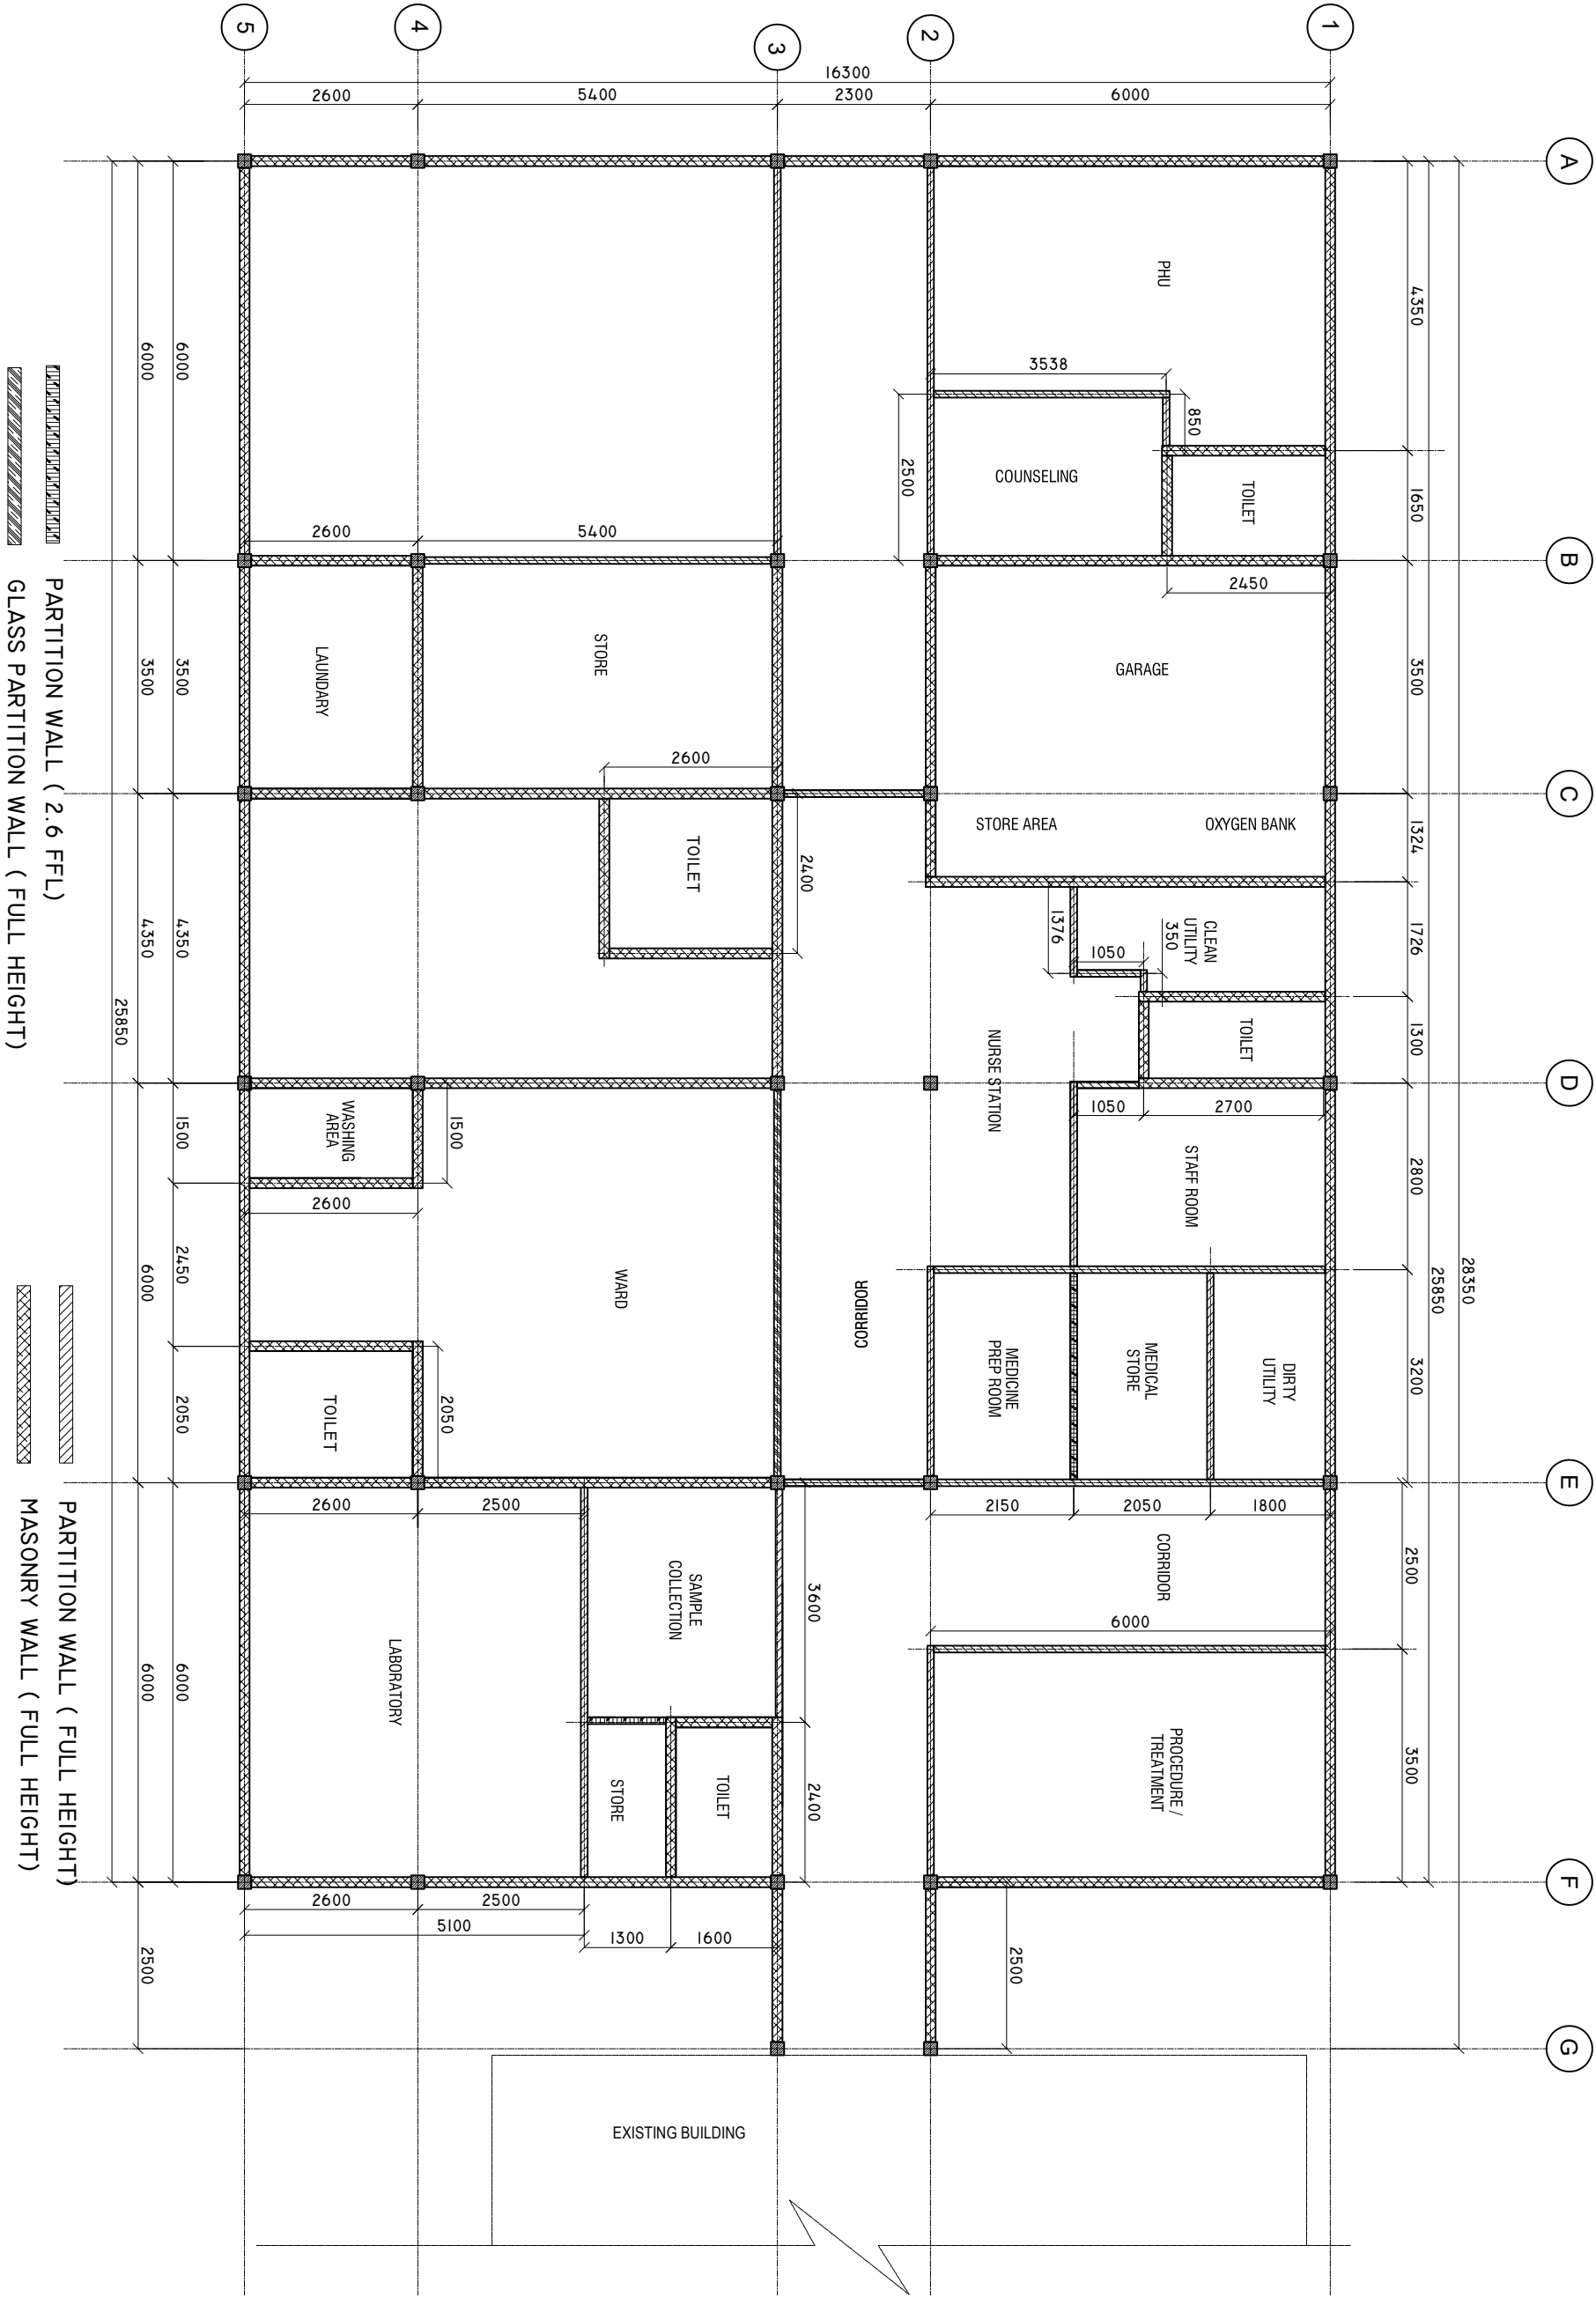

SHEET CONTENTS :

REVISION NOTES:

PROJECT:  
HEALTH CENTER  
EXTENSION BUILDING  
TYPE - B

CLIENT:  
MINISTRY OF HEALTH

LOCATION:  
DIFFERENT ISLAND


CONTENTS: AS GIVEN  
PROJECT MANAGER:  
DESIGNER: ARIZ  
CIV/STR. ENGINEER:  
SURVEYED BY: -  
DRAWN BY: ARIZ  
CHECKED BY:  
DATE : APRIL 2025  
SHEET NO. : 00/00  
PAPER SIZE: A3



Infrastructure Development Unit  
Ministry of Health  
Residence Building  
Sosun Magoi  
Tel: 332 8887, Fax: 3328889  
Email: projects@health.gov.mv


ELEVATION 'A'

SCALE: 1 : 100

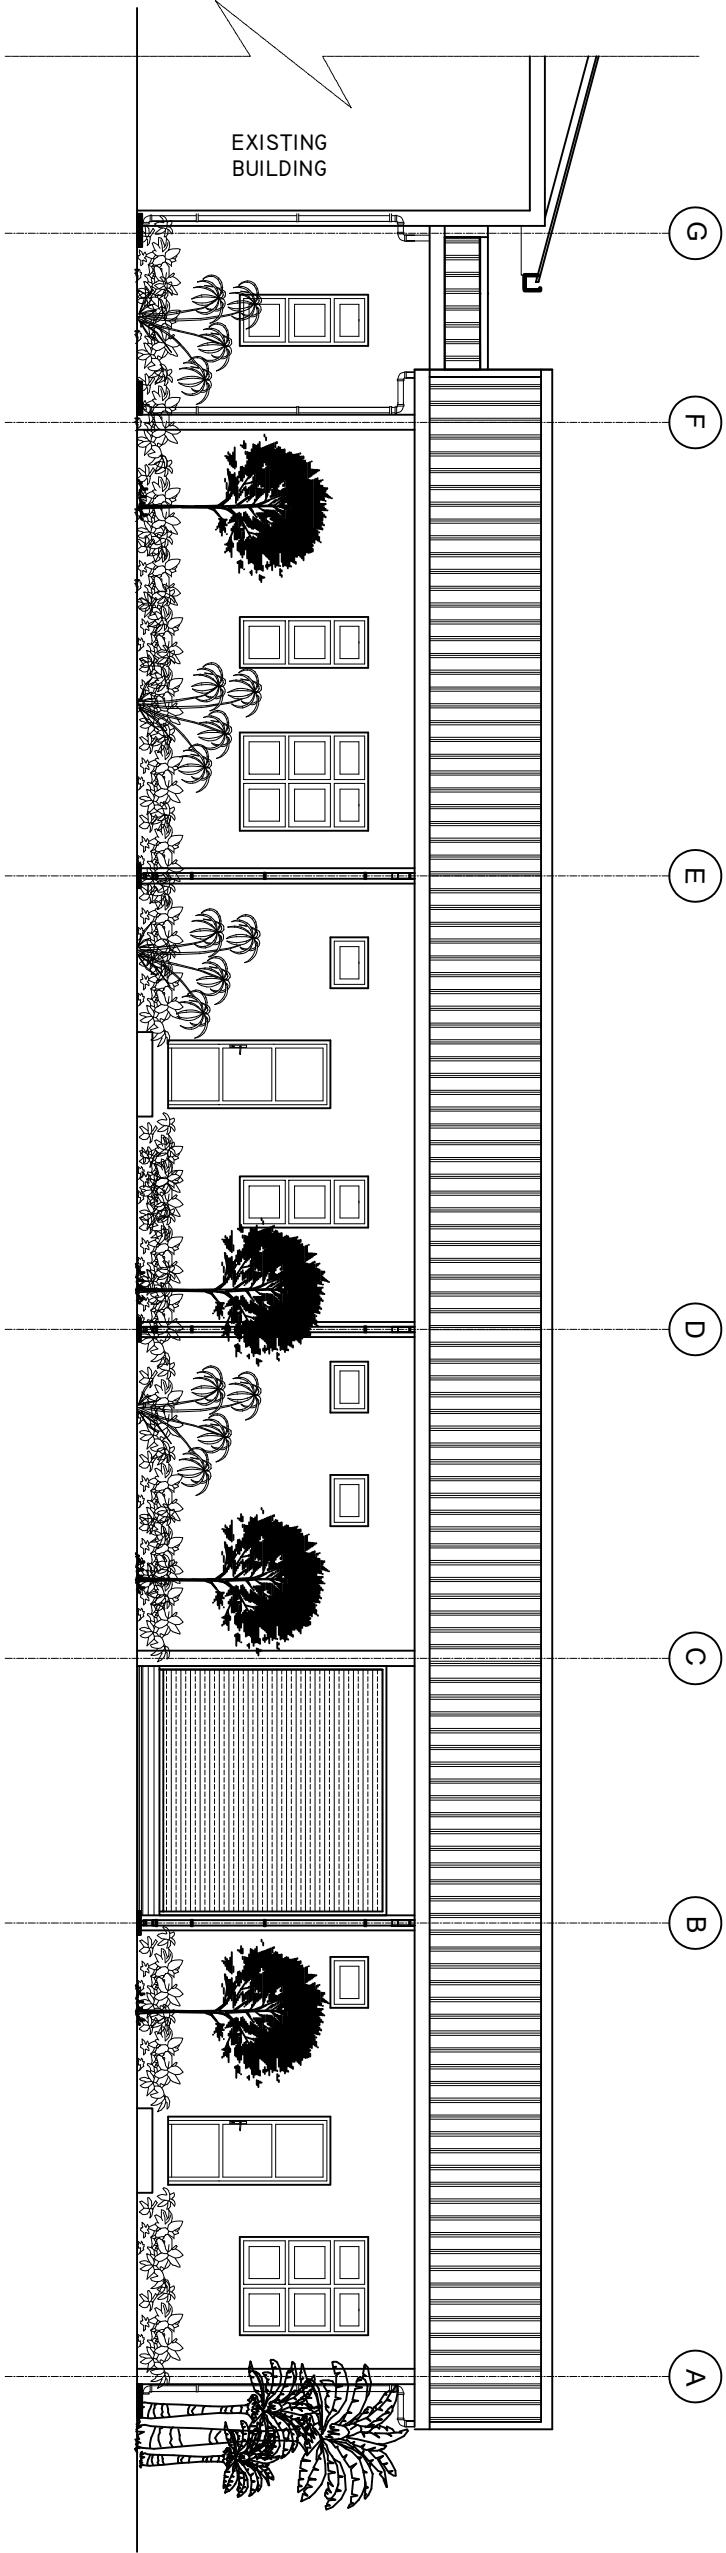

ELEVATION 'B'

SCALE: 1 : 100

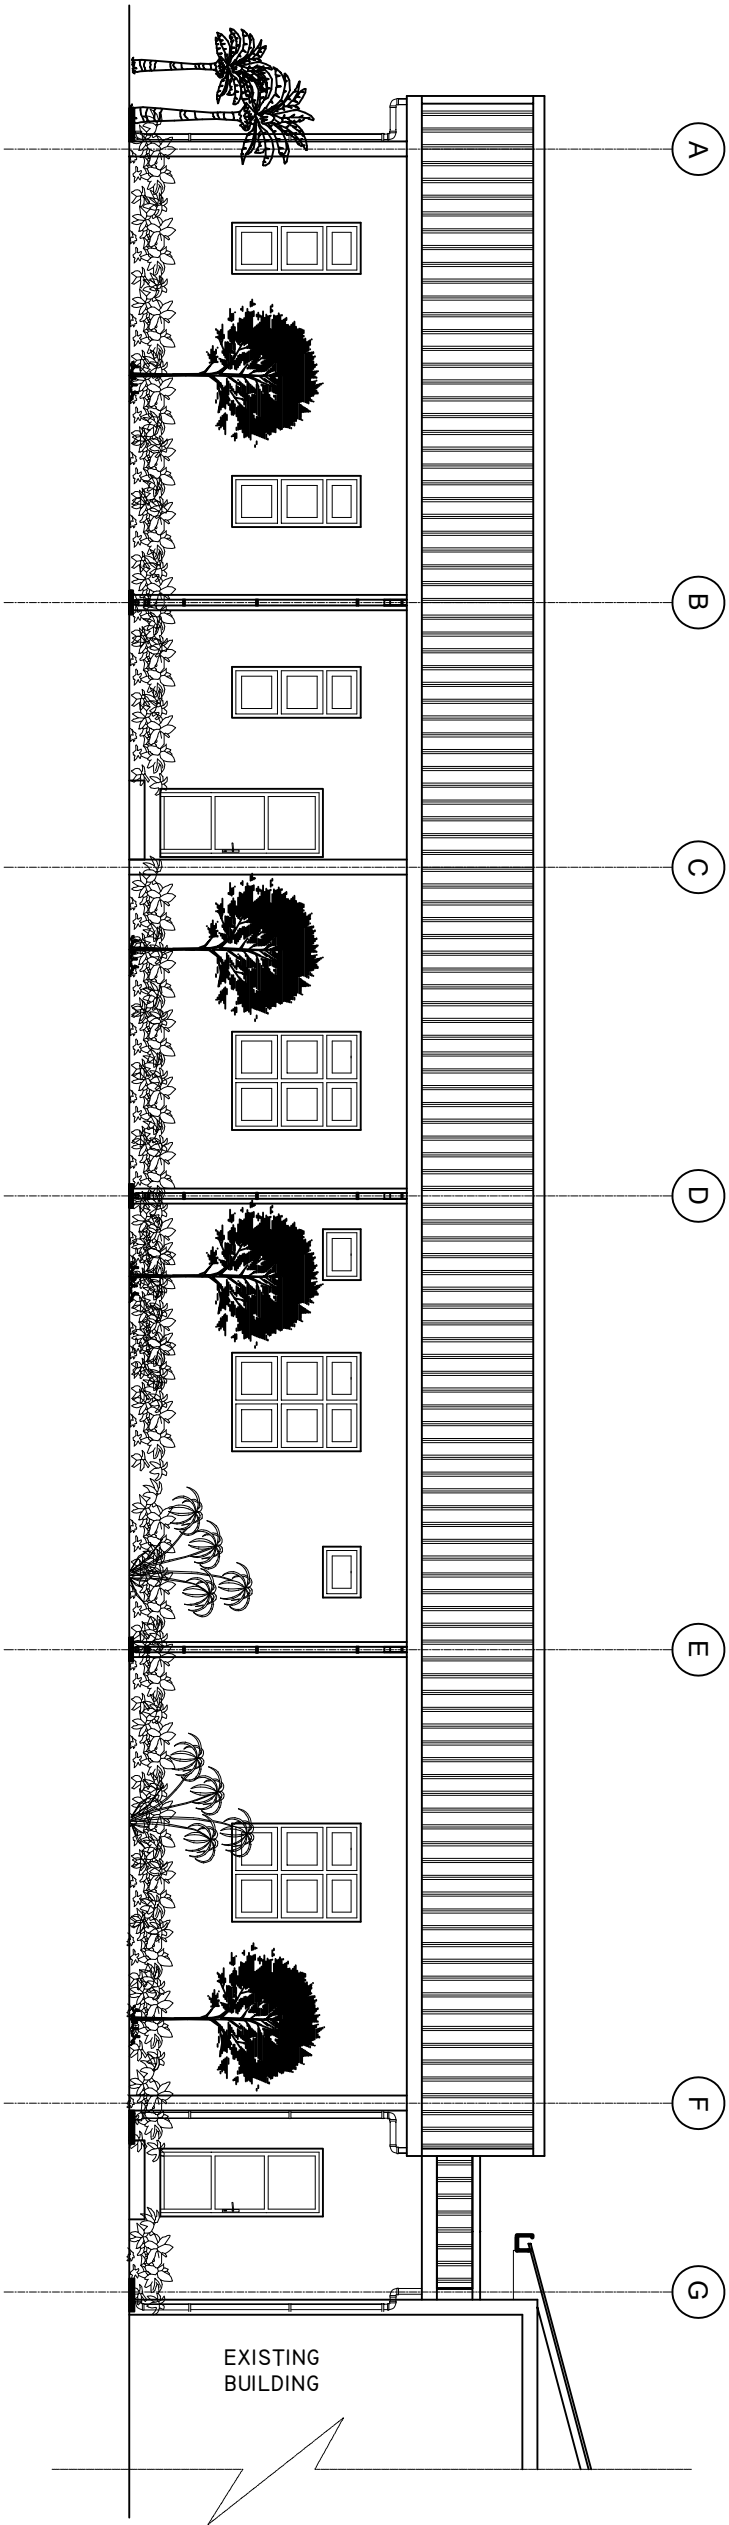

SHEET CONTENTS :

REVISION NOTES:

PROJECT:  
HEALTH CENTER  
EXTENSION BUILDING  
TYPE - B

CLIENT:  
MINISTRY OF HEALTH

LOCATION:  
DIFFERENT ISLAND

CONTENTS: AS GIVEN

PROJECT MANAGER:

DESIGNER: ARIZ

CIV/STR. ENGINEER:

SURVEYED BY: -

DRAWN BY: ARIZ

CHECKED BY:

DATE : APRIL 2025

SHEET NO. : 00/00


PAPER SIZE: A3



Infrastructure Development Unit  
Ministry of Health  
Residence Building  
Sasun Nagar  
Tel: 332 8887, Fax: 3328889  
Email: projects@health.gov.mv

**ELEVATION 'C'**

SCALE: 1 : 100

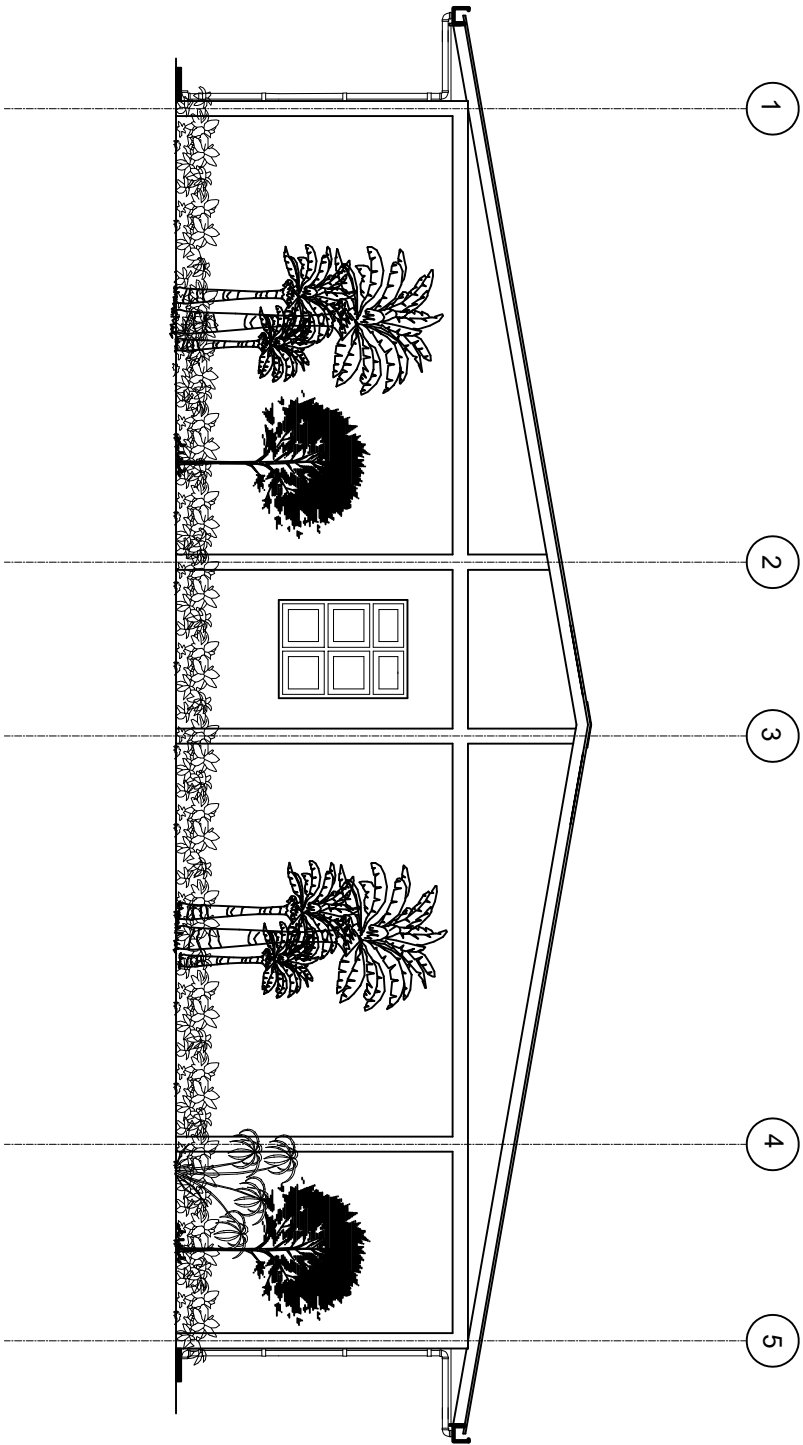

SHEET CONTENTS :	
REVISION NOTES:	
PROJECT: HEALTH CENTER EXTENSION BUILDING TYPE - B	
CLIENT: MINISTRY OF HEALTH	
LOCATION: DIFFERENT ISLAND	
CONTENTS: AS GIVEN	
PROJECT MANAGER:	
DESIGNER: ARIZ	
CIV/STR. ENGINEER:	
SURVEYED BY: -	
DRAWN BY: ARIZ	
CHECKED BY:	
DATE : APRIL 2025	
SHEET NO. : 00/00	
PAPER SIZE: A3	



# DOORS AND WINDOWS SCHEDULE

Scale 1:50

SYMBOL	D1	D2	D3	D4	D5
ELEVATION					
LOCATION	GROUND FLOOR	GROUND FLOOR	GROUND FLOOR	GROUND FLOOR	GROUND FLOOR
DESCRIPTION	40MM THICK OPENABLE DOOR	SLIDING DOOR	50MM THICK OPENABLE TIMBER FRAMED DOOR	50MM THICK OPENABLE TIMBER FRAMED DOOR	40MM THICK OPENABLE ALUMINUM FRAMED DOOR
FRAME	ALUMINUM FRAME 80 MICRON POWDER COATED, BLACK SANDY GRAY	ALUMINUM FRAME 80 MICRON POWDER COATED, BLACK SANDY GRAY	FRAME: 120MM TIMBER FRAME WITH BORDER. PANEL: TIMBER FRAME WITH 6MM PLYWOOD, ON BOTH SIDE	FRAME: 120MM TIMBER FRAME WITH BORDER. PANEL: TIMBER FRAME WITH 6MM PLYWOOD, ON BOTH SIDE	ALUMINUM FRAME 80 MICRON POWDER COATED, BLACK SANDY GRAY
HARDWARE	DOOR CLOSER DEAD LOCKS BUTT HINGE STOPPER HOLDER LONG DOOR HANDLE ON BOTH SIDE, MIN 750MM	DOOR CLOSER HANDLE LOCK BUTT HINGE STOPPER HOLDER KICKER	DOOR CLOSER HANDLE LOCK BUTT HINGE STOPPER HOLDER KICKER	DOOR CLOSER HANDLE LOCK BUTT HINGE STOPPER HOLDER KICKER	DOOR CLOSER HANDLE LOCK BUTT HINGE STOPPER HOLDER
GLAZING	C-6MM ALL FIXED PANELS TO BE DOUBLE GLASSED	C-6MM ALL FIXED PANELS TO BE DOUBLE GLASSED	C-6MM ALL FIXED PANELS TO BE DOUBLE GLASSED	C-6MM ALL FIXED PANELS TO BE DOUBLE GLASSED	C-6MM ALL FIXED PANELS TO BE DOUBLE GLASSED
NOTE	ALL MEASUREMENTS TO BE CHECKED ON SITE	ALL MEASUREMENTS TO BE CHECKED ON SITE	ALL MEASUREMENTS TO BE CHECKED ON SITE	ALL MEASUREMENTS TO BE CHECKED ON SITE	ALL MEASUREMENTS TO BE CHECKED ON SITE

SYMBOL	W1	W2	V1	V1
ELEVATION				
LOCATION	GROUND FLOOR	GROUND FLOOR	GROUND FLOOR	GROUND FLOOR
DESCRIPTION	ALUMINUM FRAMED TOP HUNG WINDOW	ALUMINUM FRAMED TOP HUNG WINDOW	ALUMINUM FRAMED TOP HUNG WINDOW	ALUMINUM TOP HUNG SLIDING GATE
FRAME	ALUMINUM FRAME 80 MICRON POWDER COATED, BLACK SANDY GRAY	ALUMINUM FRAME 80 MICRON POWDER COATED, BLACK SANDY GRAY	120MM ALUMINUM FRAME 60-80 MICRON POWDER COATED, BLACK SANDY GRAY	120MM ALUMINUM FRAME 60-80 MICRON POWDER COATED, BLACK SANDY GRAY
HARDWARE	OPENABLE FRAME HANDLE	OPENABLE FRAME HANDLE	OPENABLE FRAME HANDLE	REMOTE CONTROL
GLAZING	6MM THICK HEAT REFLECTIVE GLASS	6MM THICK HEAT REFLECTIVE GLASS	6MM THICK HEAT REFLECTIVE GLASS	6MM THICK HEAT REFLECTIVE GLASS
NOTE	ALL MEASUREMENTS TO BE CHECKED ON SITE	ALL MEASUREMENTS TO BE CHECKED ON SITE	ALL MEASUREMENTS TO BE CHECKED ON SITE	ALL MEASUREMENTS TO BE CHECKED ON SITE

NOTE: PROVIDE RC LINTEL ABOVE ALL DOOR/WINDOW/VENTILATOR UNITS

NOT FIXED TO BEAMS

AND PROVIDE RC SILL BEAMS UNDER ALL WINDOW UNITS

ALL TIMBER DOORS TO BE MADE OF TIMBER, PUTTY SMOOTHED AND FINISHED WITH ENAMEL PAINT AS SPECIFIED

ALL MEASUREMENTS TO BE CHECKED ON SITE BEFORE FABRICATION

GL = 6MM THICK CLEAR GLASS

GL1 = 6MM THICK HEAT REFLECTIVE GLASS

FG1 = 6MM THICK CLEAR GLASS

FG2 = 8MM THICK LAMINATED, CLEAR GLASS

CL = 6MM THICK POWDER COATED CLADDING.

TM = TREATED TIMBER FRAME WITH 6MM PLYWOOD ON BOTH SIDE AND PAINTING.

DOOR FRAME: MINIMUM 90X50MM

DOOR PANEL FRAME: MINIMUM 100X50MM

WINDOW FRAME: MINIMUM 50X75MM

WINDOW PANEL FRAME: MINIMUM 50X100MM

ALL THE ALUMINUM PROFILE MUST BE MINIMUM 2MM THICK. AND PROFILE MUST BE APPROVED BEFORE FABRICATION.

SHEET CONTENTS :

REVISION NOTES:

PROJECT:

HEALTH CENTER  
EXTENSION BUILDING  
TYPE - B

CLIENT:

MINISTRY OF HEALTH

LOCATION:

DIFFERENT ISLAND

CONTENTS: AS GIVEN

PROJECT MANAGER:

DESIGNER: ARIZ

CIV/STR. ENGINEER:

SURVEYED BY: -

DRAWN BY: ARIZ

CHECKED BY:

DATE : APRIL 2025

SHEET NO. : 00/00

PAPER SIZE: A3




Infrastructure Development Unit  
Ministry of Health  
Residence Building  
Sasun Nagar  
Tel: 332 8887, Fax: 3328889  
Email: projects@health.gov.mv



COLUMN AND FOOTIONG PLAN

SCALE: 1 : 100

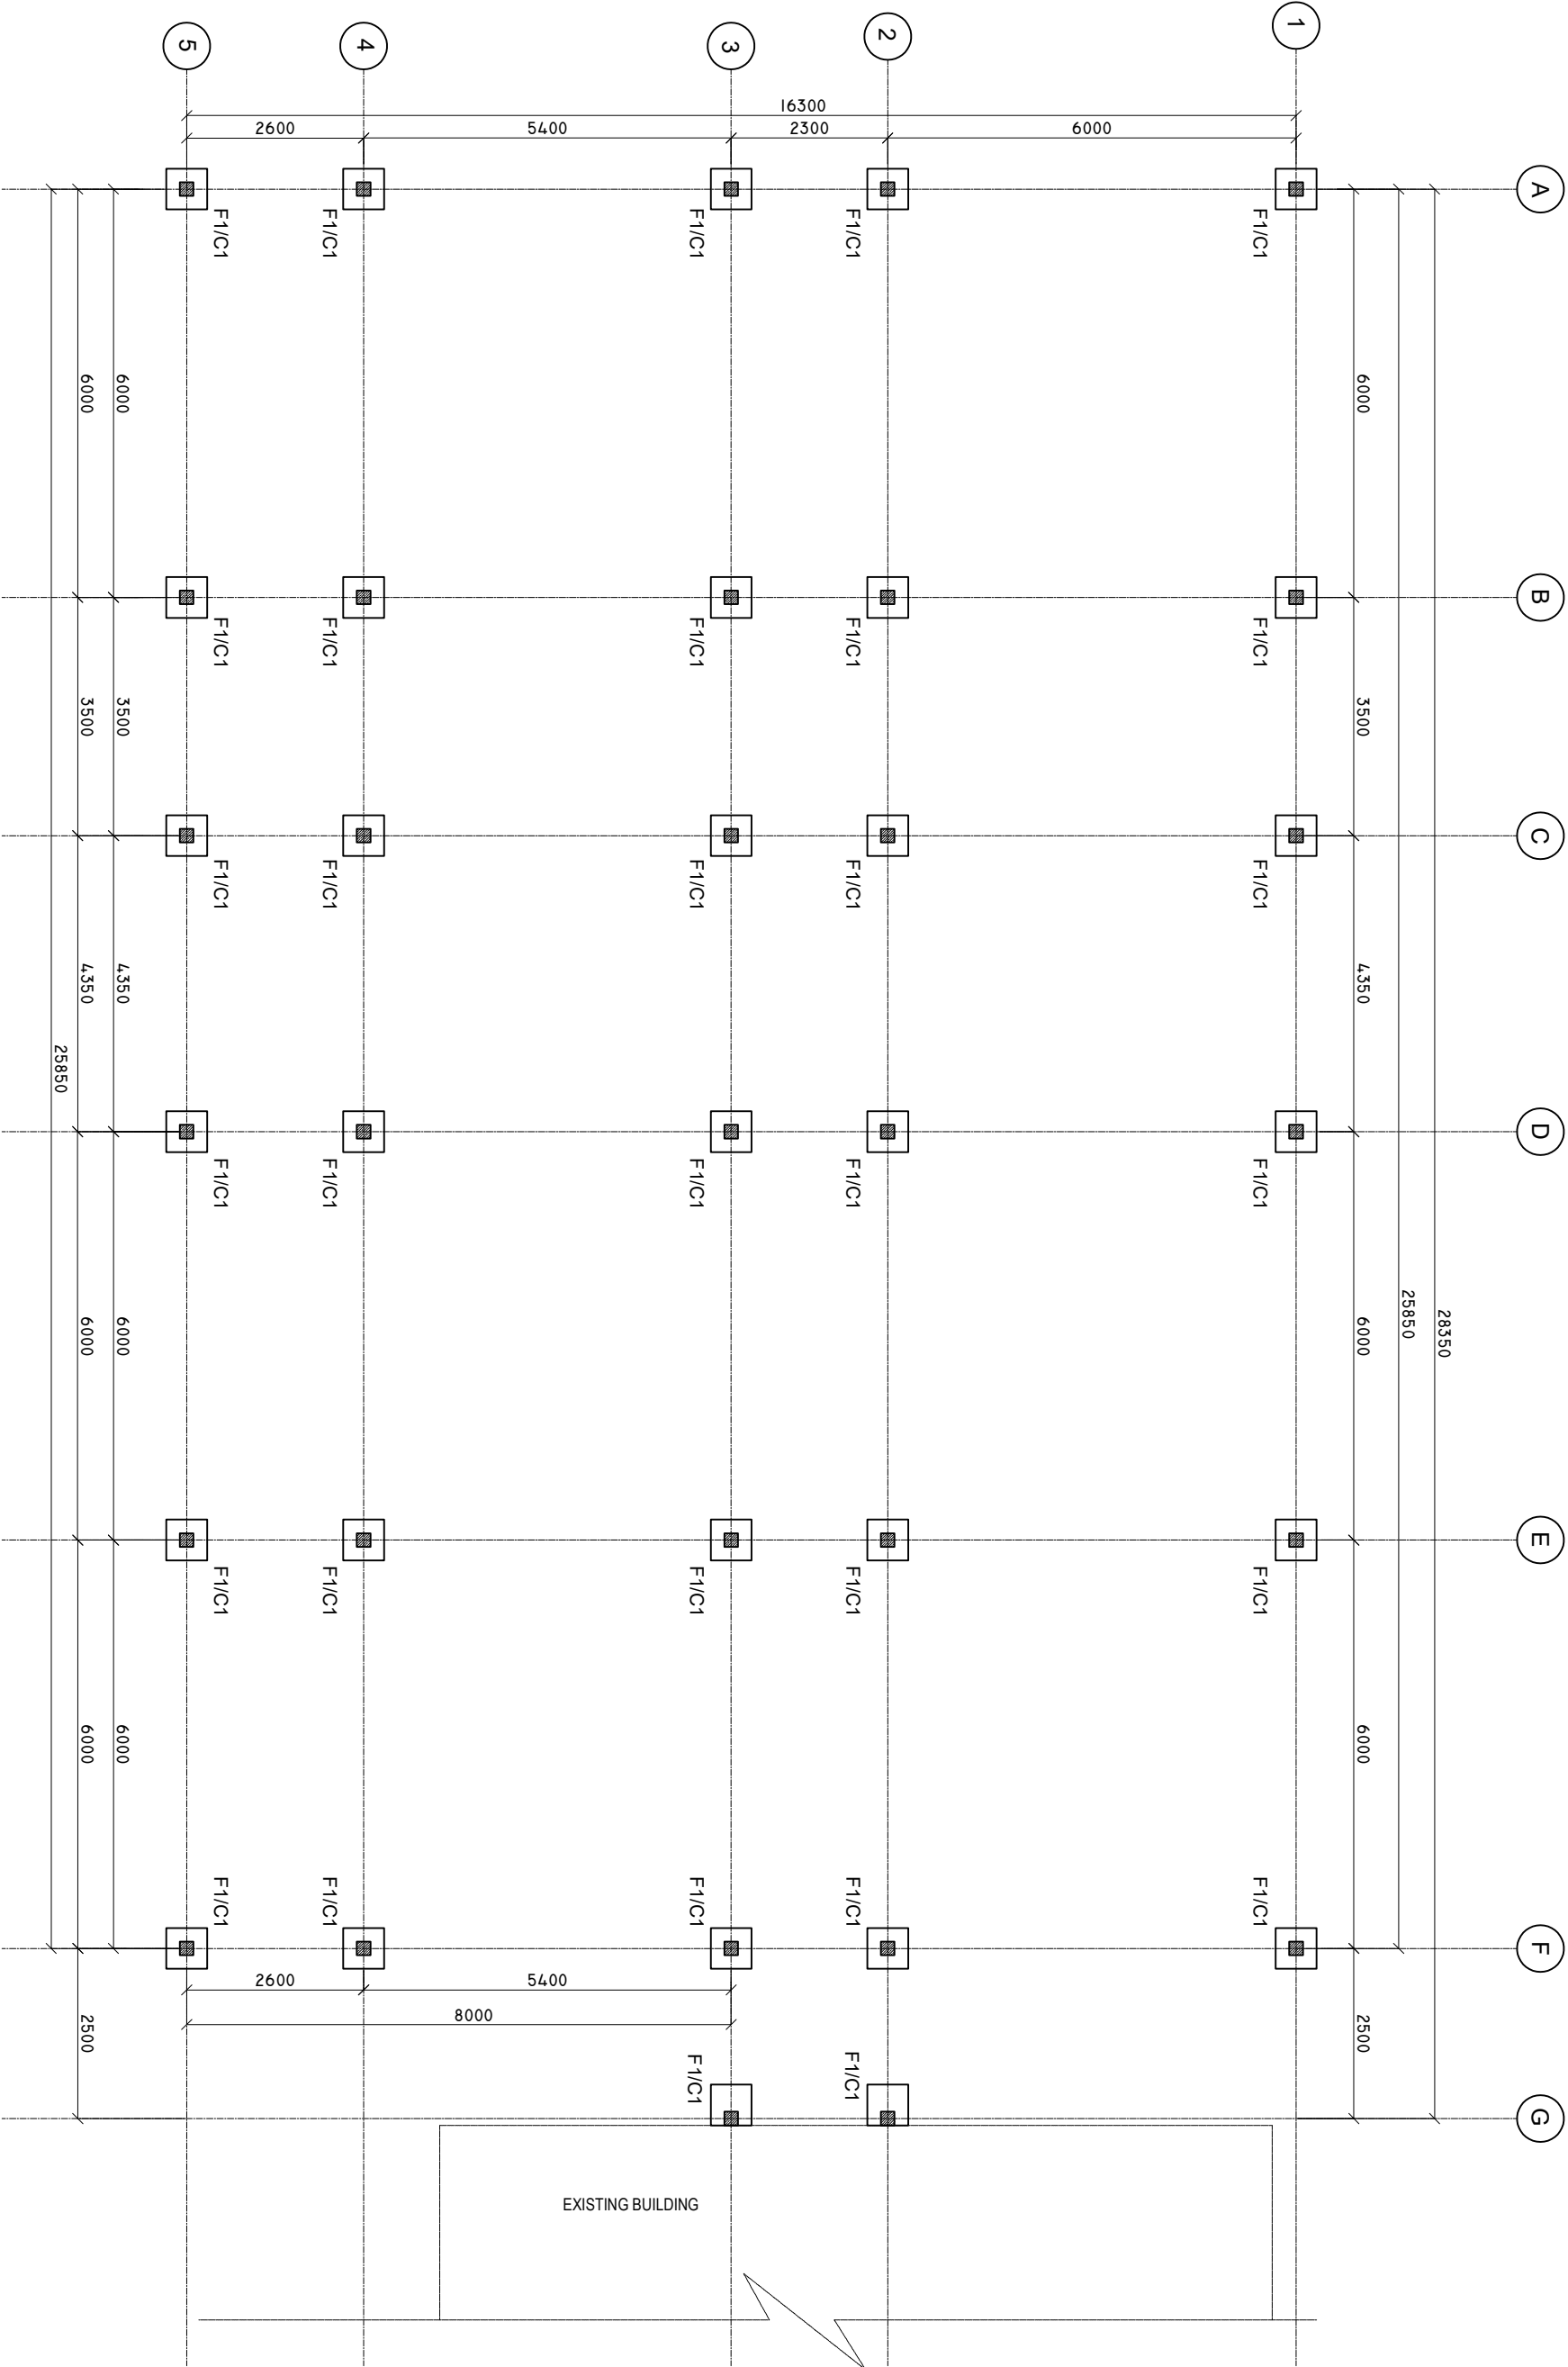

SHEET CONTENTS :

REVISION NOTES:

PROJECT:  
HEALTH CENTER  
EXTENSION BUILDING  
TYPE - B

CLIENT:  
MINISTRY OF HEALTH

LOCATION:  
DIFFERENT ISLAND

CONTENTS: AS GIVEN

PROJECT MANAGER:  
DESIGNER: ARIZ  
CIV/STR. ENGINEER:  
SURVEYED BY: -  
DRAWN BY: ARIZ  
CHECKED BY:  
DATE: .APRIL 2025  
SHEET NO. : 00/00  
PAPER SIZE: A3




Infrastructure Development Unit  
Ministry of Health  
Residence Building  
Sosun Mager  
Tel: 332 8887, Fax: 3328889  
Email: projects@health.gov.mv



TIE BEAM PLAN

SCALE: 1 : 100

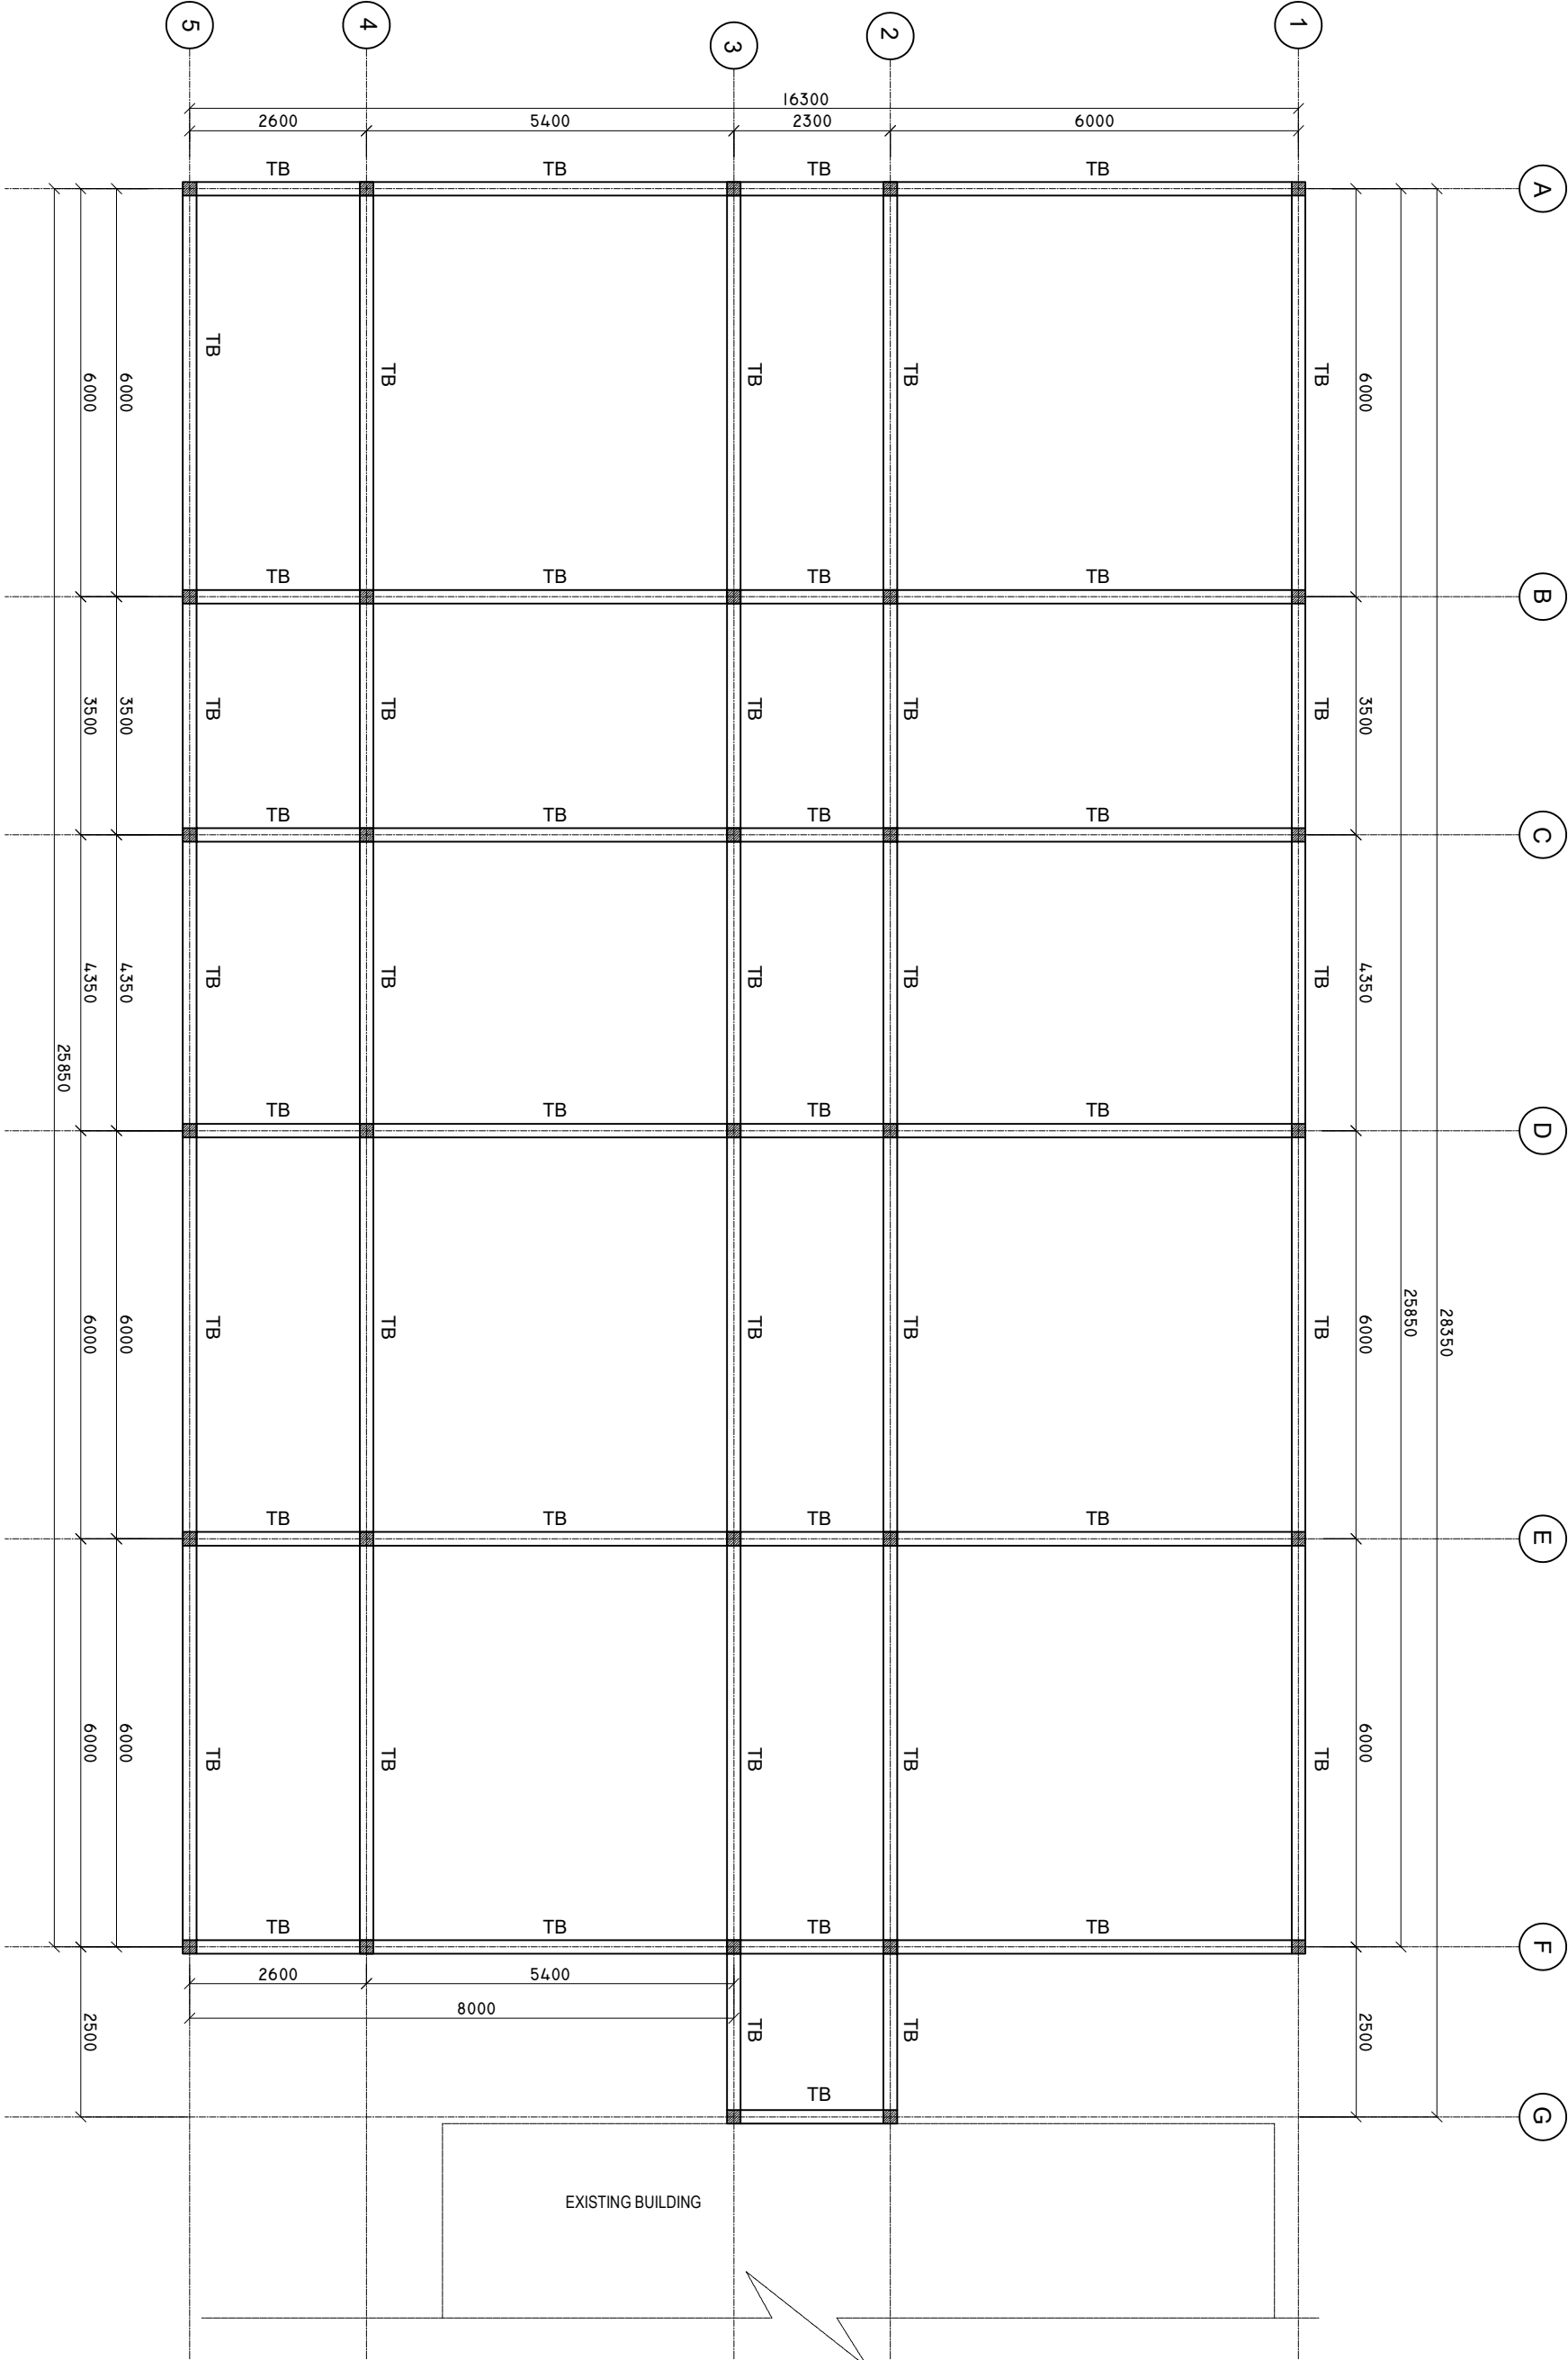

SHEET CONTENTS :

REVISION NOTES:

PROJECT:  
HEALTH CENTER  
EXTENSION BUILDING  
TYPE - B

CLIENT:  
MINISTRY OF HEALTH

LOCATION:  
DIFFERENT ISLAND

CONTENTS: AS GIVEN

PROJECT MANAGER:

DESIGNER: ARIZ

CIV/STR. ENGINEER:

SURVEYED BY: -

DRAWN BY: ARIZ

CHECKED BY:

DATE : APRIL 2025

SHEET NO. : 00/00


PAPER SIZE: A3



Infrastructure Development Unit  
Ministry of Health  
Residence Building  
Sosun Magoi  
Tel: 332 8887, Fax: 3328889  
Email: projects@health.gov.mv

ROOF BEAM PLAN

SCALE: 1 : 100

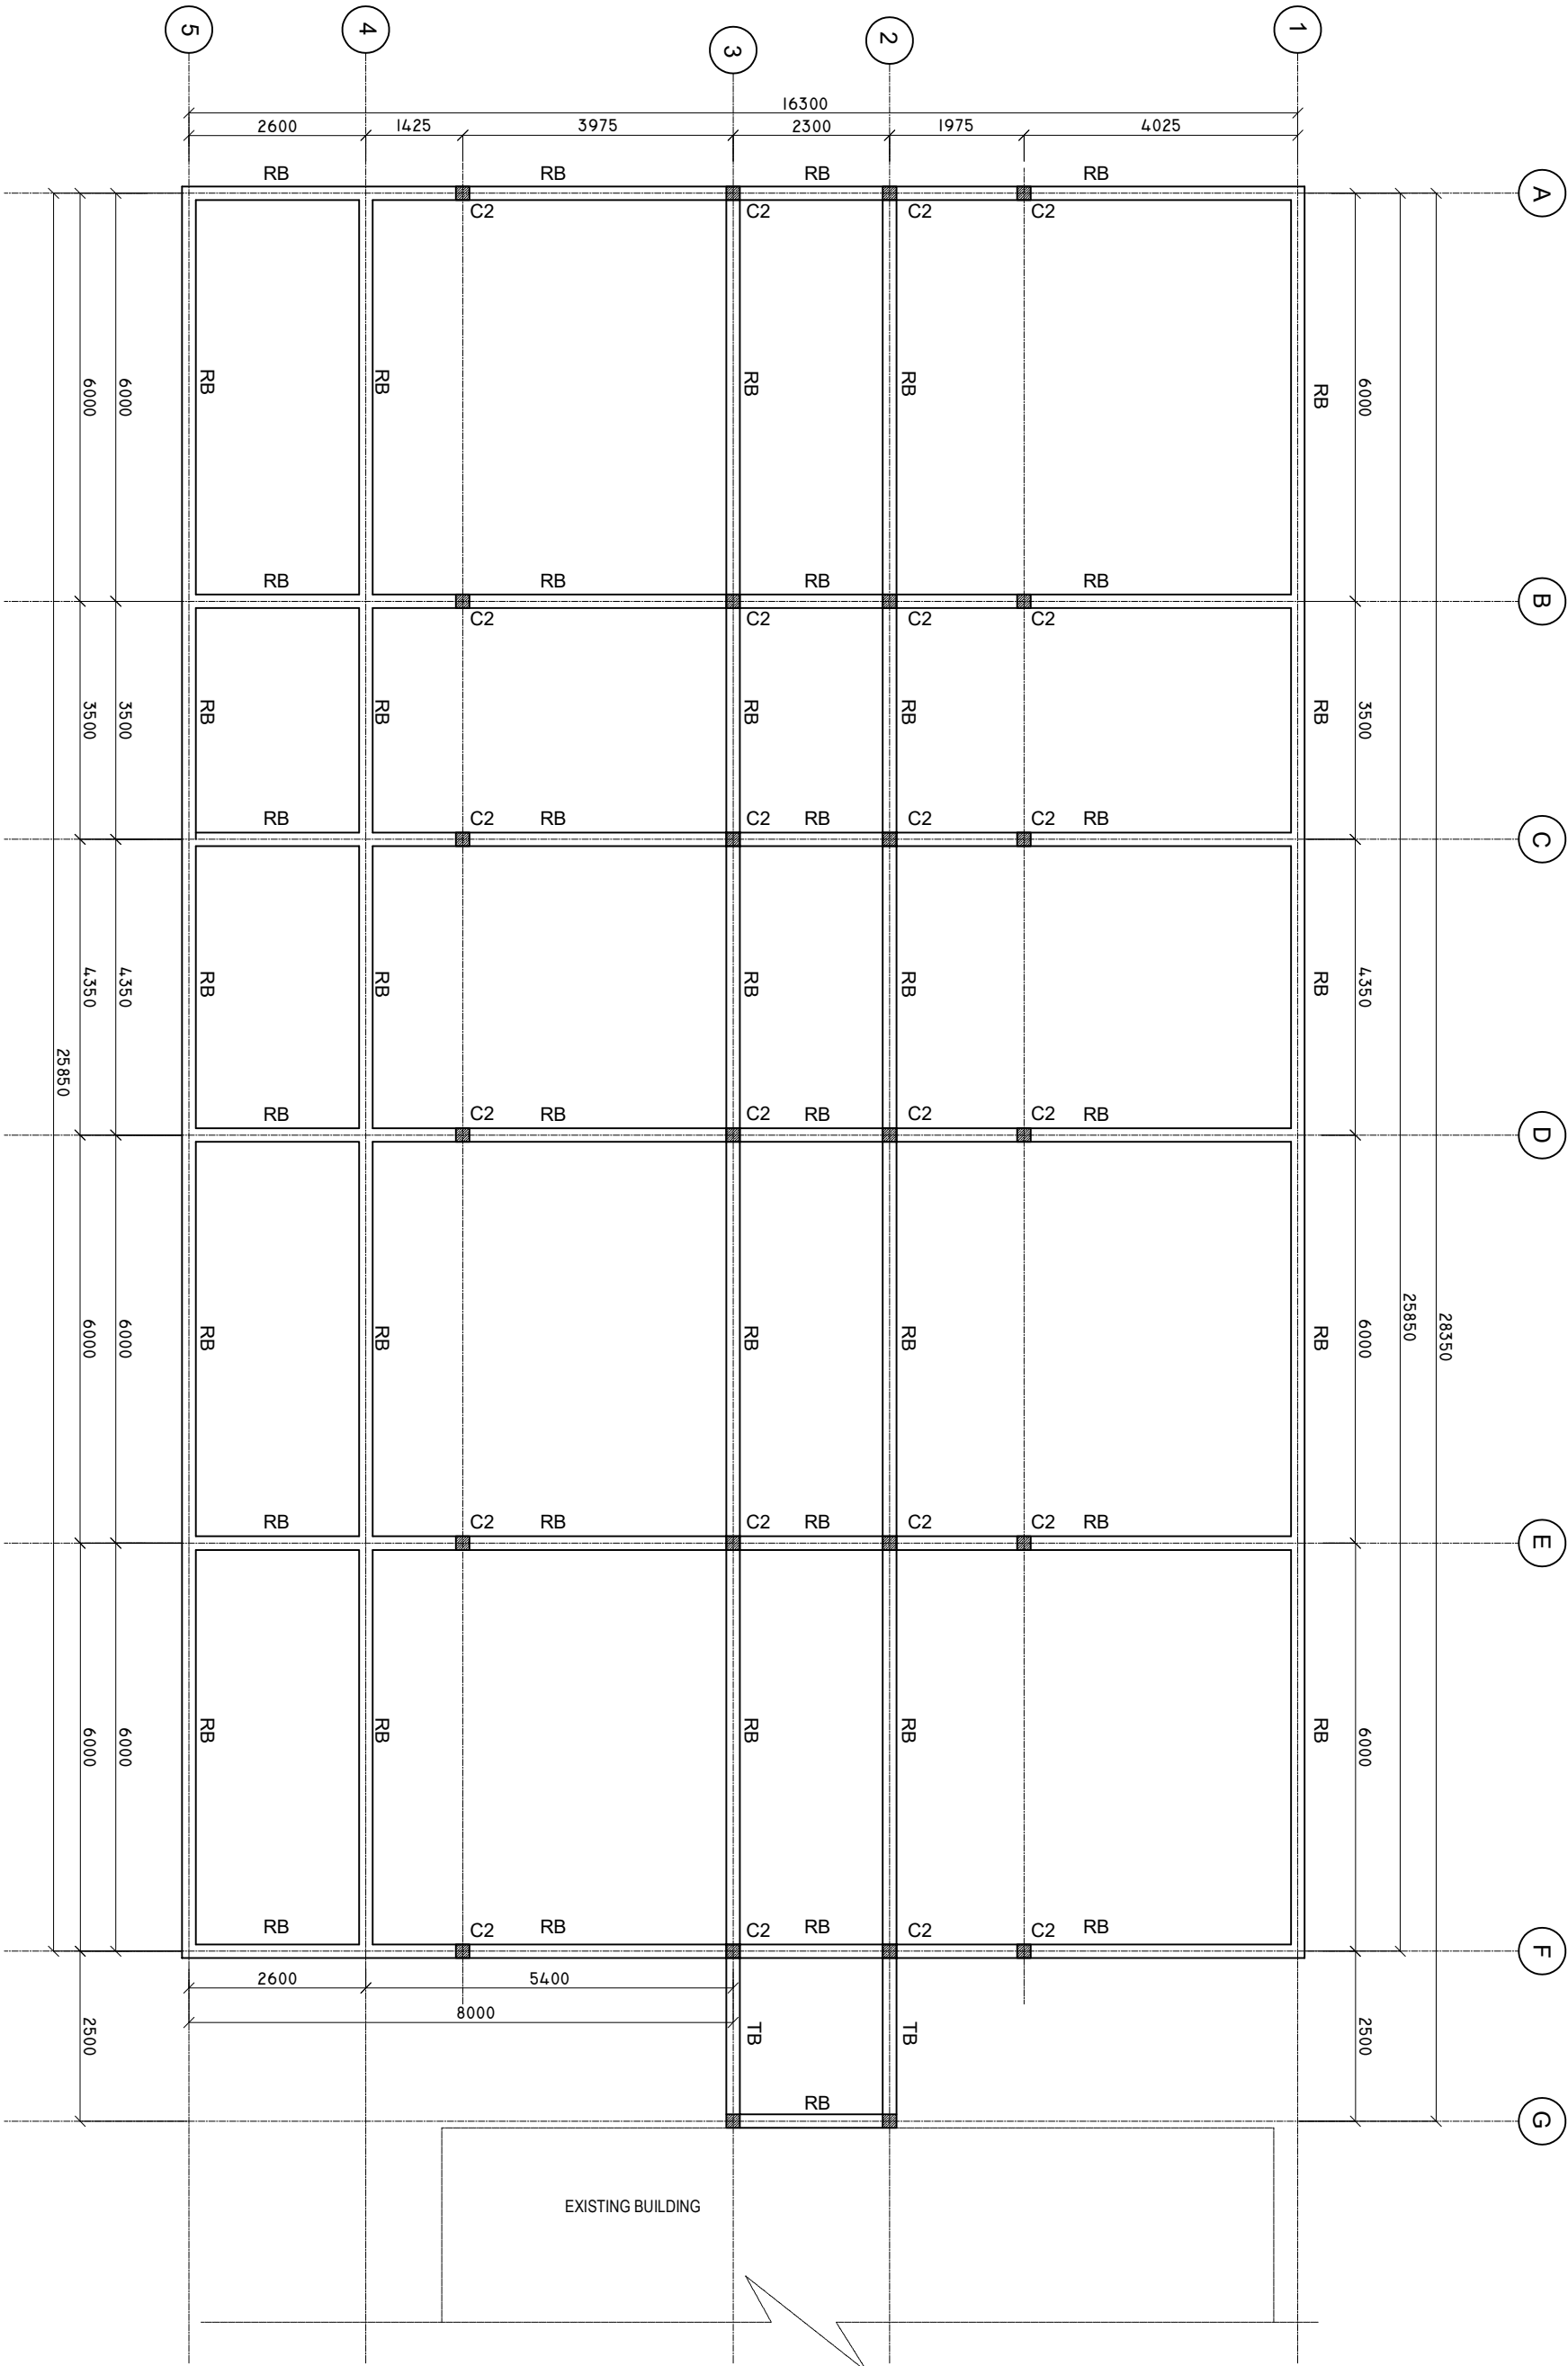

SHEET CONTENTS :

REVISION NOTES:

PROJECT:  
HEALTH CENTER  
EXTENSION BUILDING  
TYPE - B

CLIENT:  
MINISTRY OF HEALTH

LOCATION:  
DIFFERENT ISLAND

CONTENTS: AS GIVEN

PROJECT MANAGER:

DESIGNER: ARIZ

CIV/STR. ENGINEER:

SURVEYED BY: -

DRAWN BY: ARIZ

CHECKED BY:

DATE : APRIL 2025

SHEET NO. : 00/00


PAPER SIZE: A3




Infrastructure Development Unit  
Ministry of Health  
Roshanee Building  
Sosun Magoi  
Tel: 332 8887, Fax: 3328889  
Email: projects@health.gov.mv

DETAILS R/C

SCALE: 1 : 25

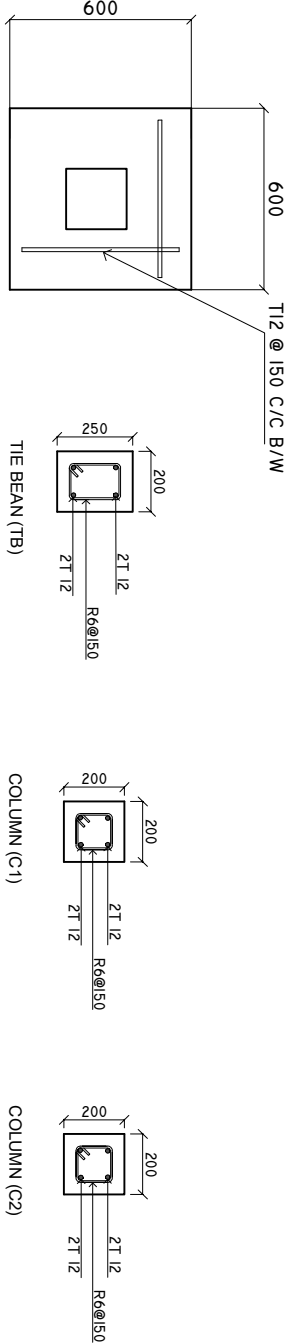

F1

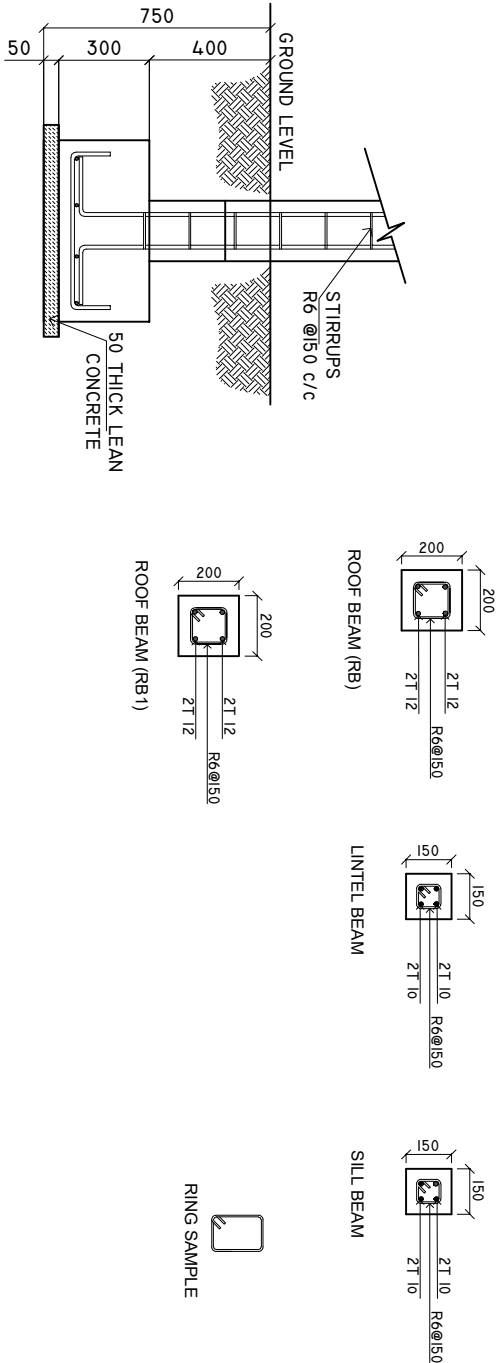

MINIMUM 50MM COVER BELOW GROUND LEVEL	ALL BAR BENDING & OVERLAPS AS PER ACTUAL BS STANDARD.
MINIMUM 30MM COVER ABOVE GROUND LEVEL	

NOTE:  
LINTEL BEAMS TO BE LAID ABOVE AND BELOW ALL WINDOWS AND ALL DOORS.

SHEET CONTENTS :

REVISION NOTES:

PROJECT:

HEALTH CENTER  
EXTENSION BUILDING  
TYPE - B

CLIENT:

MINISTRY OF HEALTH

LOCATION:

DIFFERENT ISLAND

CONTENTS: AS GIVEN

PROJECT MANAGER:

DESIGNER: ARIZ

CIV/STR. ENGINEER:

SURVEYED BY: -

DRAWN BY: ARIZ

CHECKED BY:

DATE : APRIL 2025

SHEET NO. : 00/00

PAPER SIZE: A3




Infrastructure Development Unit  
Ministry of Health  
Rostunee Building  
Sossun Maqur  
Tel: 332 8887, Fax: 3328889  
Email: projects@health.gov.mv

## TRUSS DETAILS

**SCALE: 1 : 25**


GL PIPE 25MM DIA.

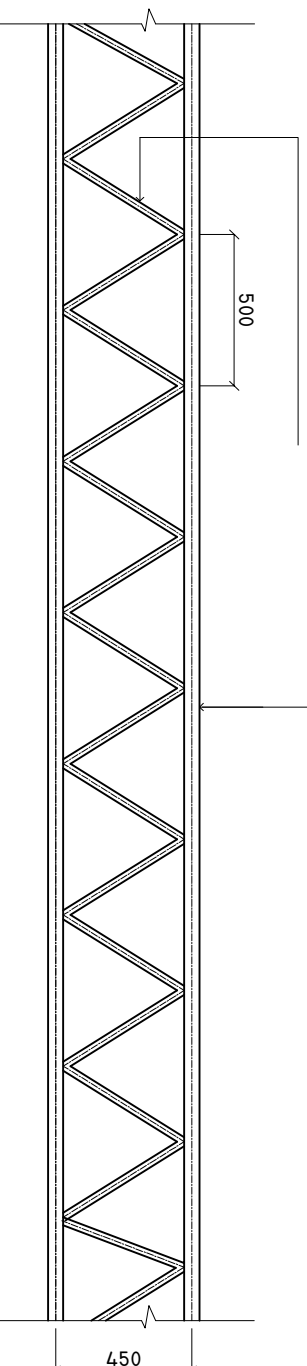

THICKNESS OF GI PIPE MUST BE MINIMUM 2MM.

## CONNECTION DETAILS

**SCALE: 1 : 25**

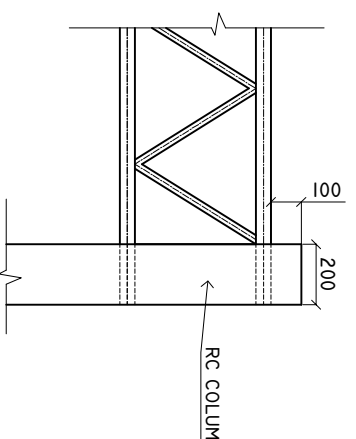

THICKNESS OF GI PIPE MUST BE MINIMUM 2MM.


50X50MM EQUAL ANGLE WELDED TO THE TRUSS  
AND ANCHOR WITH RAFTERS.

SHEET CONTENTS :
REVISION NOTES:
PROJECT:
HEALTH CENTER EXTENSION BUILDING TYPE - B
CLIENT:
MINISTRY OF HEALTH
LOCATION:
DIFFERENT ISLAND
CONTENTS: AS GIVEN
PROJECT MANAGER:
DESIGNER: ARIZ
CIV/STR. ENGINEER:
SURVEYED BY: -
DRAWN BY: ARIZ
CHECKED BY:
DATE : APRIL 2025
SHEET NO. : 00/00
PAPER SIZE: A3



*Infrastructure Development Unit  
Ministry of Health  
Roshanee Building  
Sosun Magu'  
Tel: 332 8887, Fax: 3328889  
Email: [projects@health.gov.mv](mailto:projects@health.gov.mv)*

**DETAIL A**  
**SCALE: 1 : 10**

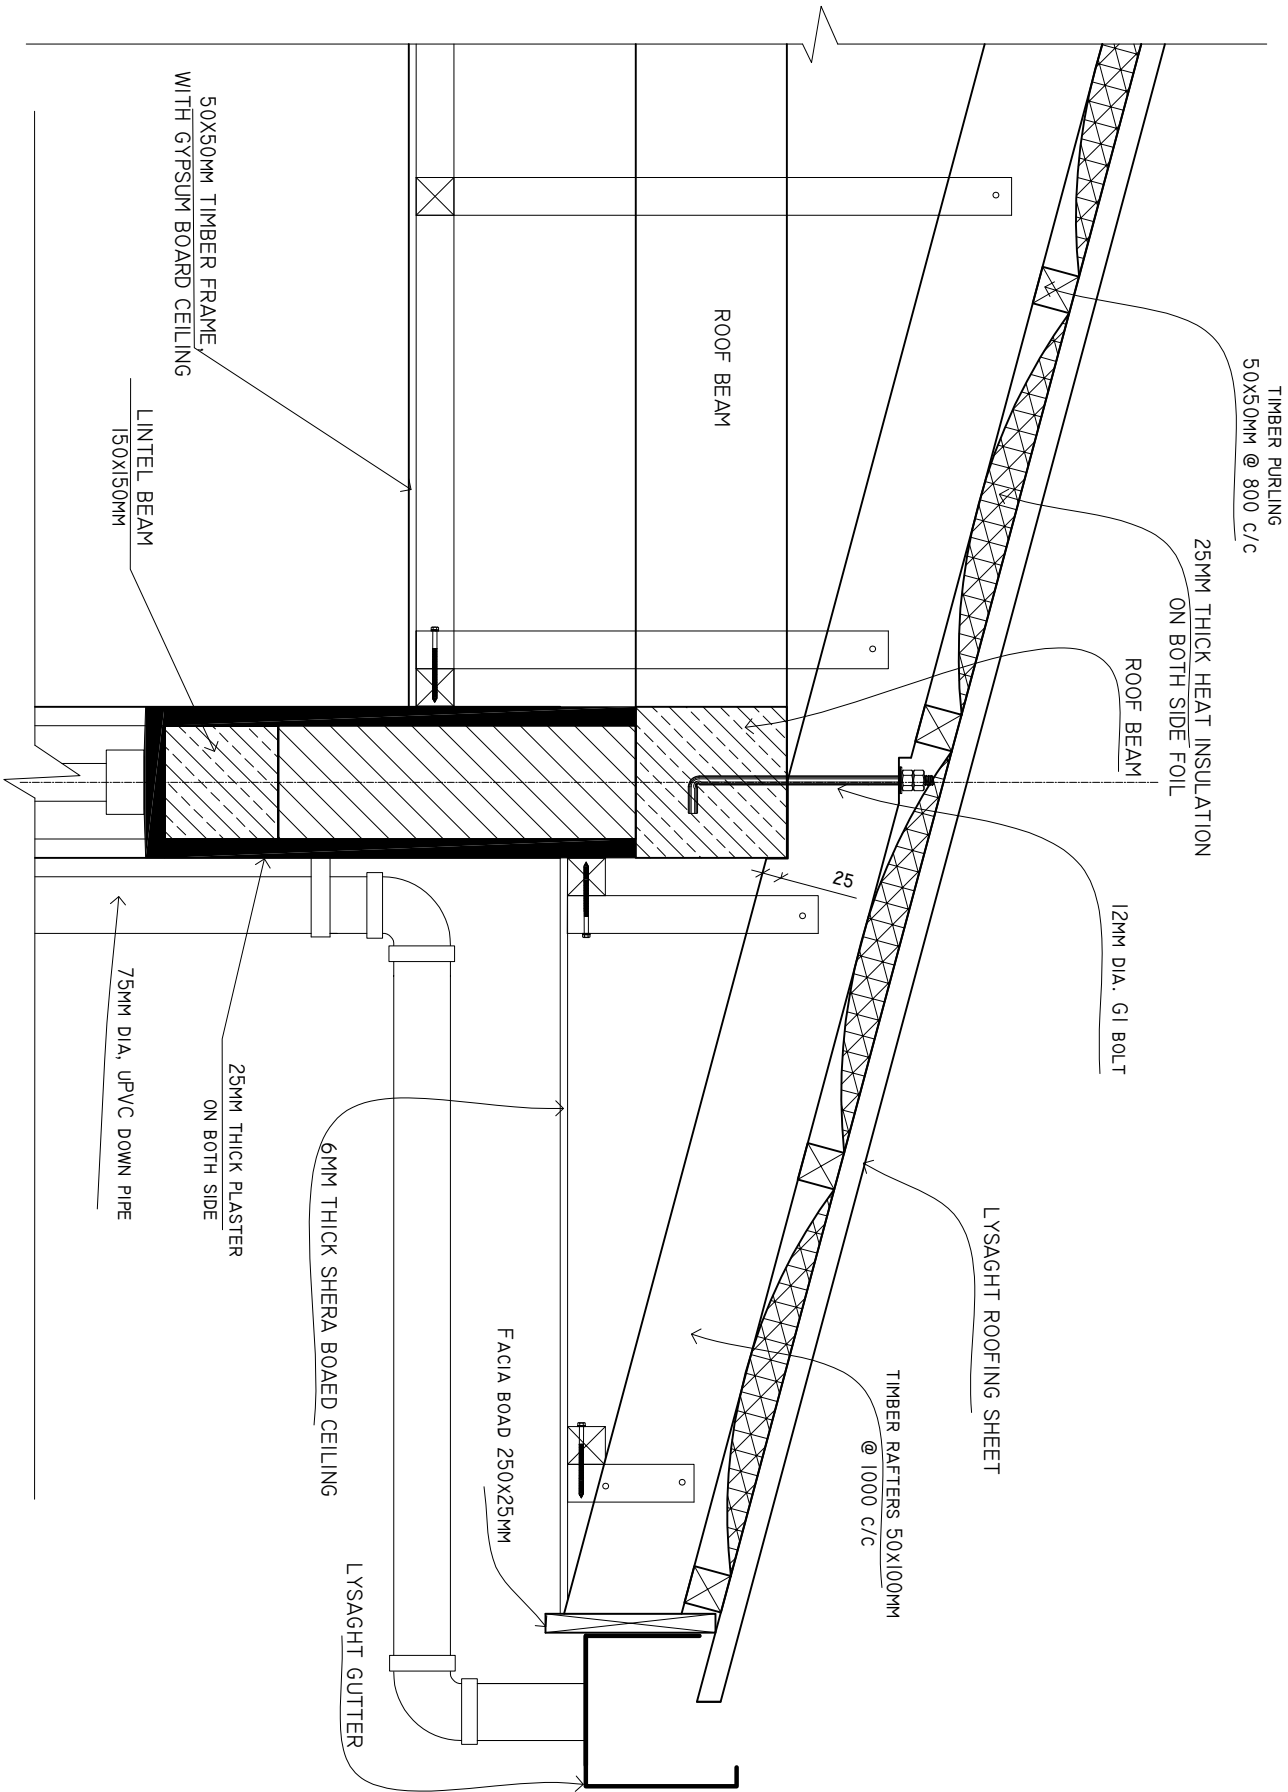

SHEET CONTENTS :

REVISION NOTES:

PROJECT:  
HEALTH CENTER  
EXTENSION BUILDING  
TYPE - B

CLIENT:  
MINISTRY OF HEALTH

LOCATION:  
DIFFERENT ISLAND

CONTENTS: AS GIVEN

PROJECT MANAGER:

DESIGNER: ARIZ

CIV/STR. ENGINEER:

SURVEYED BY: -

DRAWN BY: ARIZ

CHECKED BY:

DATE : APRIL 2025

SHEET NO. : 00/00


PAPER SIZE: A3



Infrastructure Development Unit  
Ministry of Health  
Resilience Building  
Sosun Magoi  
Tel: 332 8887, Fax: 3328889  
Email: projects@health.gov.mv

## DETAIL B

**SCALE: 1 : 10**

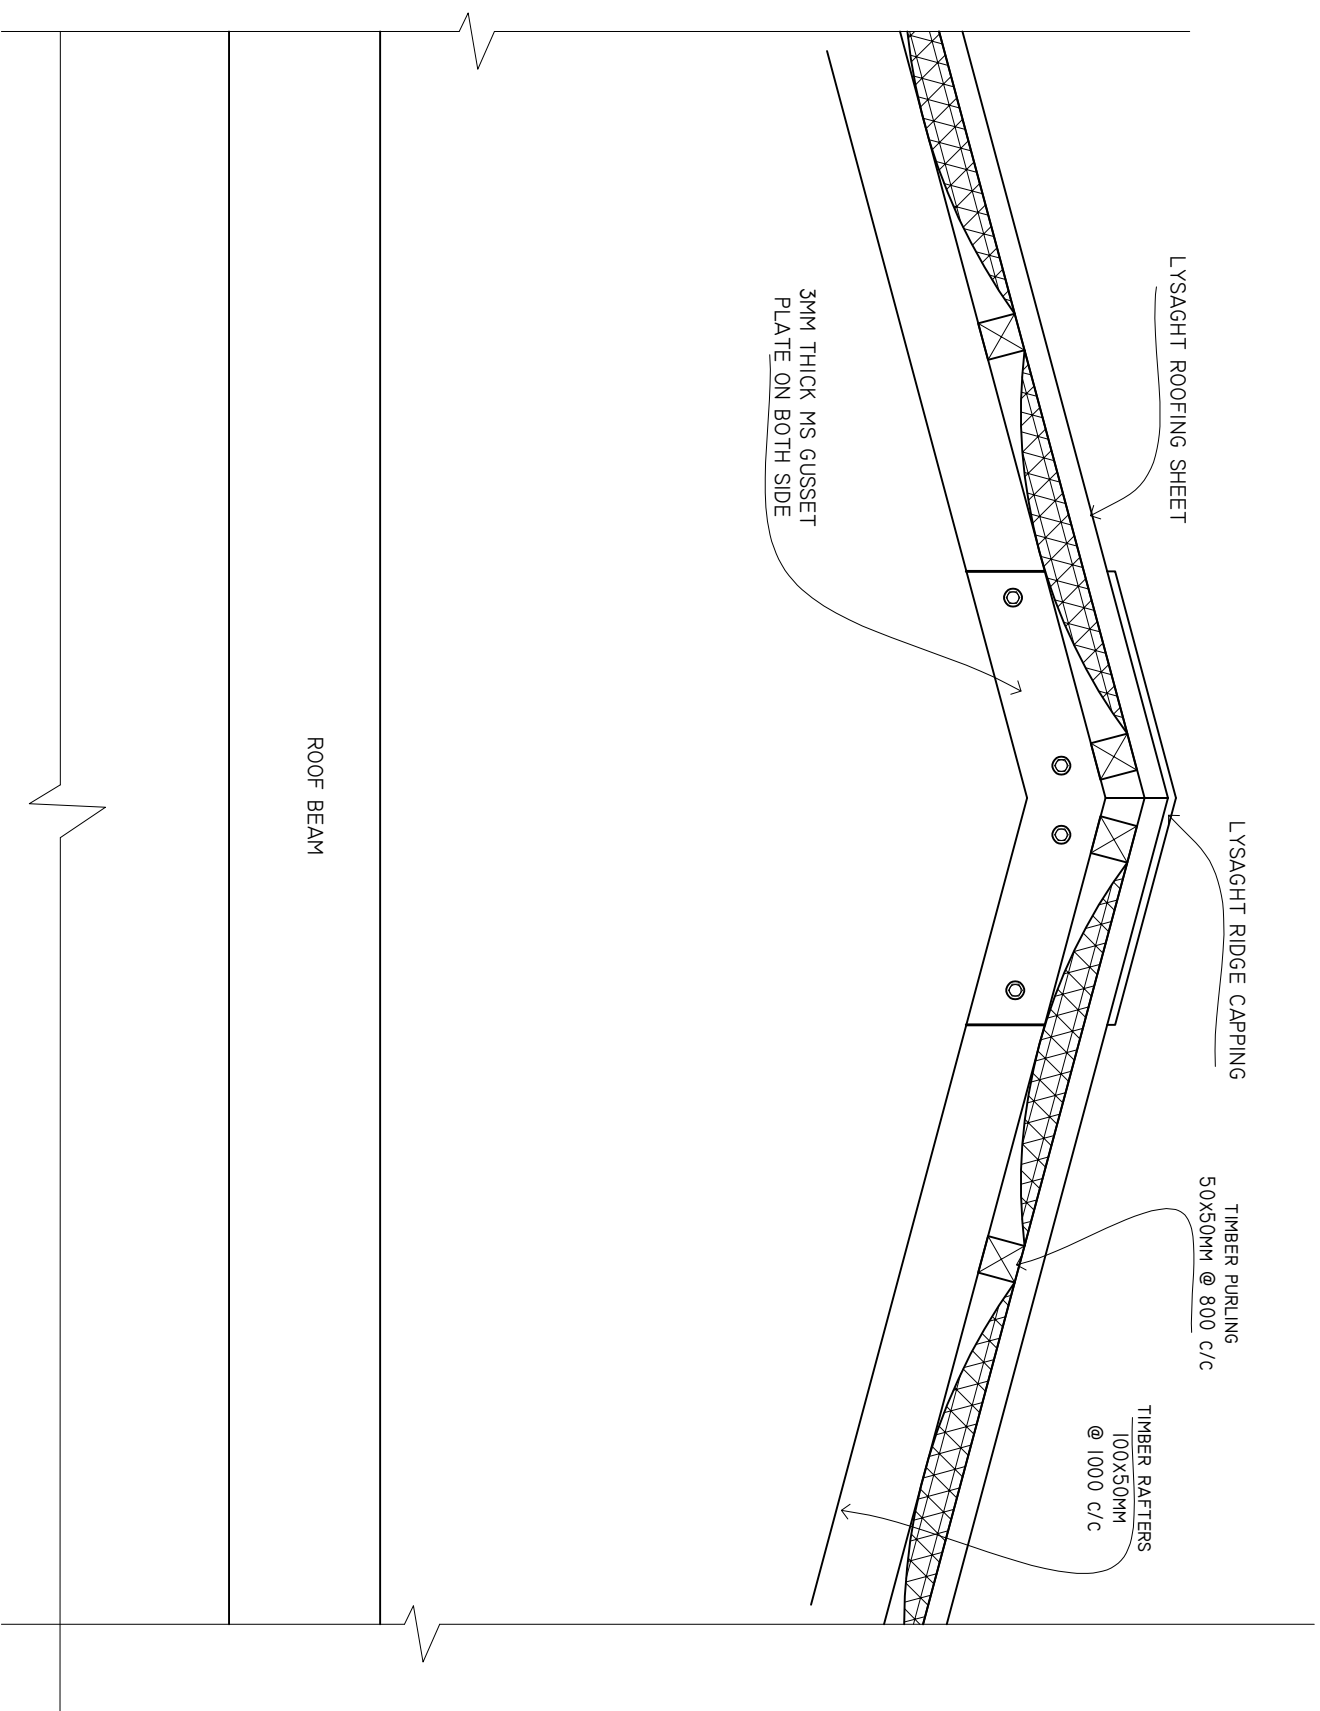

SHEET CONTENTS :
PROJECT:
HEALTH CENTER EXTENSION BUILDING TYPE - B
CLIENT:
MINISTRY OF HEALTH
LOCATION:
DIFFERENT ISLAND
CONTENTS: AS GIVEN
PROJECT MANAGER:
DESIGNER: ARIZ
CIV/STR. ENGINEER:
SURVEYED BY: -
DRAWN BY: ARIZ
CHECKED BY:
DATE : APRIL 2025
SHEET NO. : 00/00
PAPER SIZE: A3




*Infrastructure Development Unit  
Ministry of Health  
Roshanee Building  
Sosun Magi'  
Tel: 332 8887, Fax: 3328889  
Email: [projects@health.gov.mv](mailto:projects@health.gov.mv)*



DETAILS C  
PARTITION DETAILS


SCALE: 1 : 25

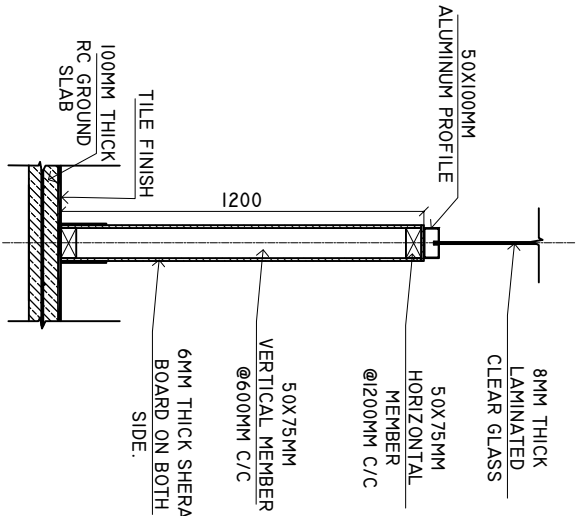

NOTE: PARTITION WORKS TO BE START AFTER TILLING WORKS.

DETAILS D  
PARTITION DETAILS


SCALE: 1 : 25

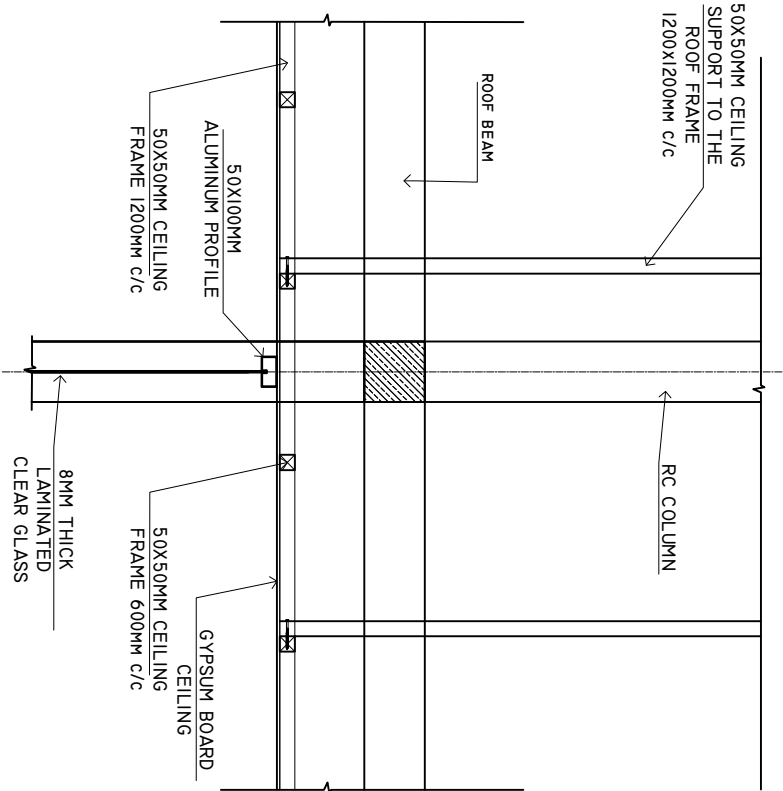

NOTE: PARTITION WORKS TO BE START AFTER CEILING WORKS.

BOX DETAILS FOR AC PIPE LINE

SCALE: 1 : 25

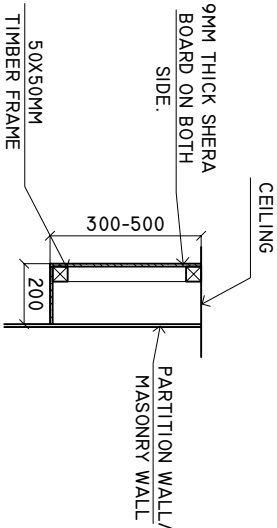

SHEET CONTENTS :

REVISION NOTES:

PROJECT:

HEALTH CENTER  
EXTENSION BUILDING  
TYPE - B

CLIENT:

MINISTRY OF HEALTH

LOCATION:

DIFFERENT ISLAND

CONTENTS: AS GIVEN

PROJECT MANAGER:

DESIGNER: ARIZ

CIV/STR. ENGINEER:

SURVEYED BY: -

DRAWN BY: ARIZ

CHECKED BY:

DATE : APRIL 2025

SHEET NO. : 00/00


PAPER SIZE: A3



Infrastructure Development Unit  
Ministry of Health  
Roshanee Building  
Sosun Maqat  
Tel: 332 8887, Fax: 3328889  
Email: projects@health.gov.mv

CROSS SECTION X-X

SCALE: 1 : 50

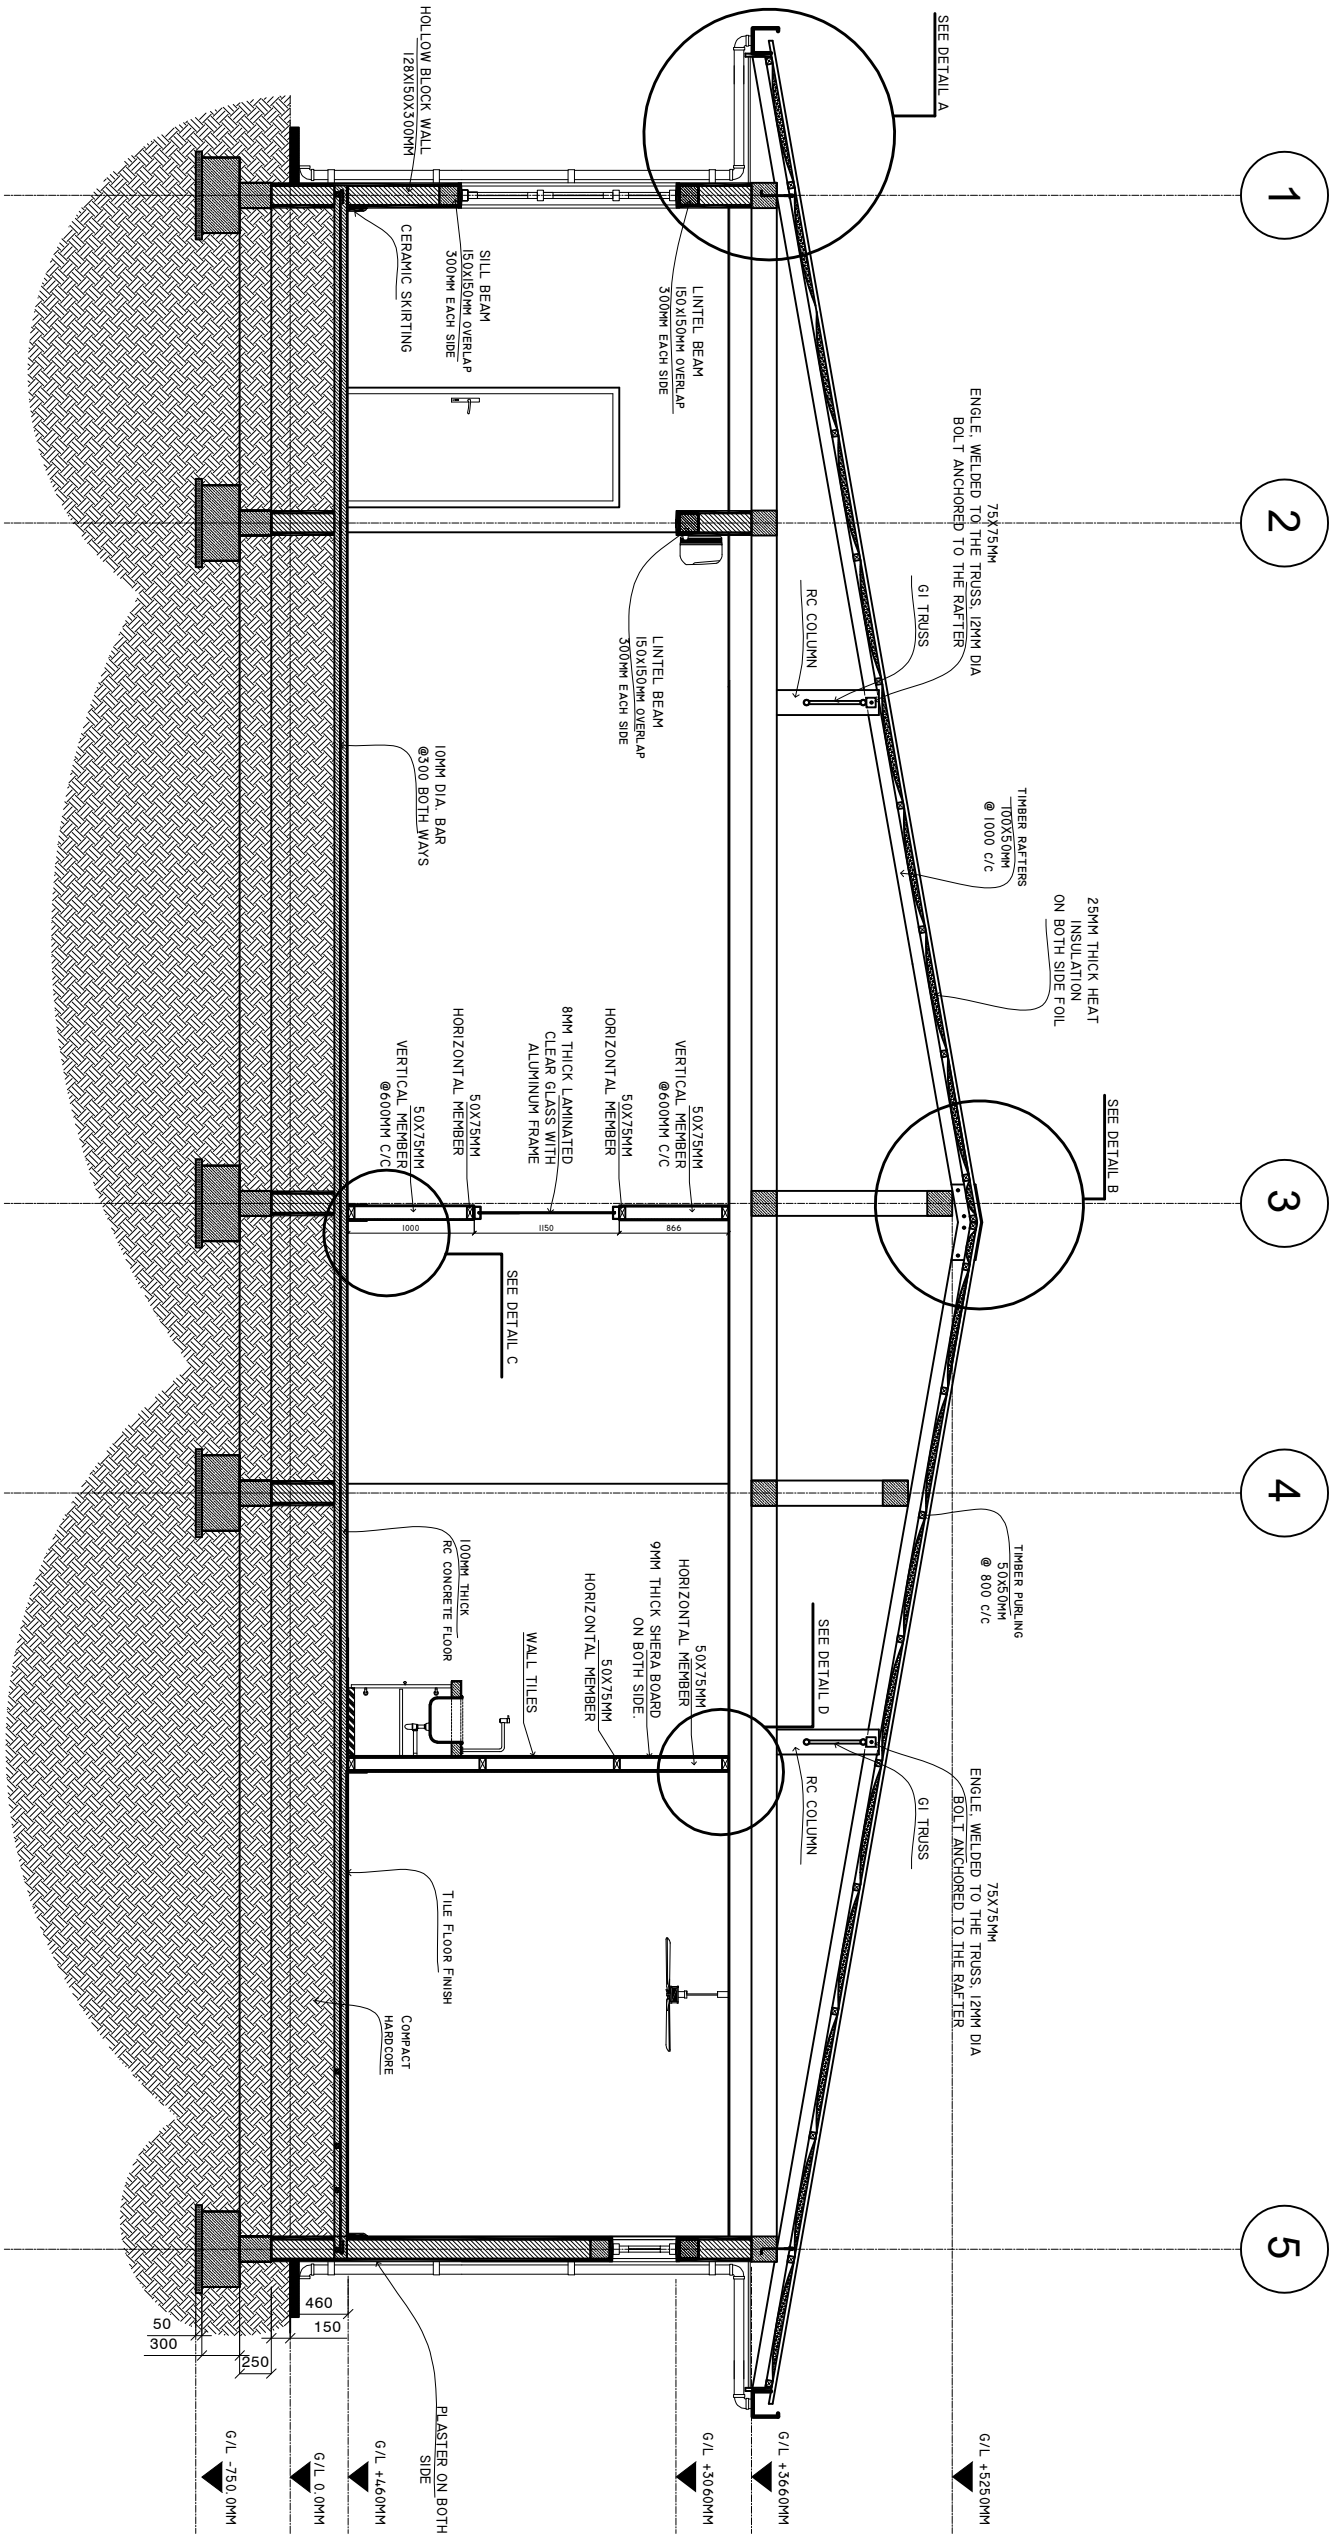

SHEET CONTENTS :

REVISION NOTES:

PROJECT:  
HEALTH CENTER  
EXTENSION BUILDING  
TYPE - B

CLIENT:

MINISTRY OF HEALTH

LOCATION:

DIFFERENT ISLAND

CONTENTS: AS GIVEN

PROJECT MANAGER:

DESIGNER: ARIZ

CIV/STR. ENGINEER:

SURVEYED BY: -

DRAWN BY: ARIZ

CHECKED BY:

DATE: : APRIL 2025

SHEET NO. : 00/00

PAPER SIZE: A3




Infrastructure Development Unit  
Ministry of Health  
Restaurante Building  
Sasun Nagar  
Tel: 332 8887, Fax: 3328889  
Email: projects@health.gov.mv

# NURSE STATION SINK CUPBOARD


## SINK CUPBOARD.

SCALE: 1 : 20

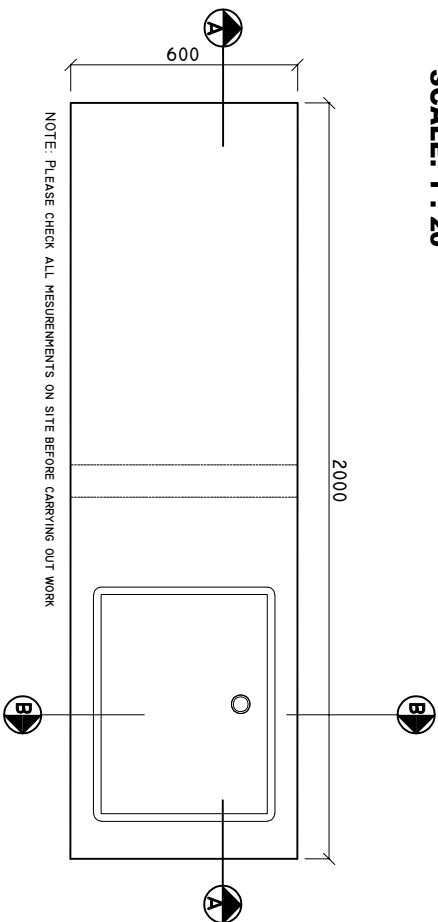

## SINK CUPBOARD SECTION A-A


SCALE: 1 : 20

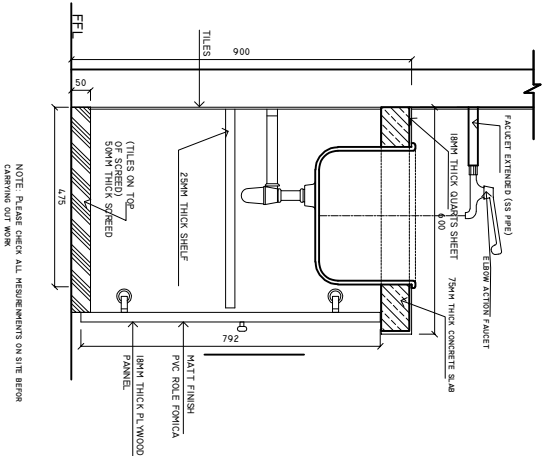

## SINK CUPBOARD


### DETAIL B-B

SCALE: 1 : 20

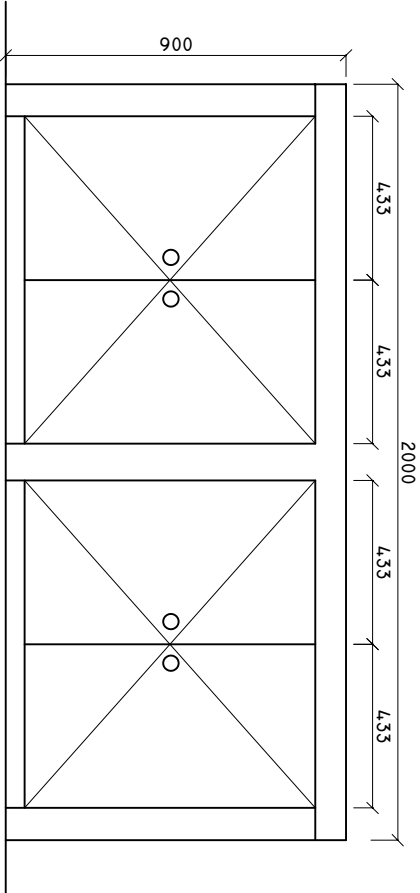

## SINK CUPBOARD ELEVATION

SCALE: 1 : 20

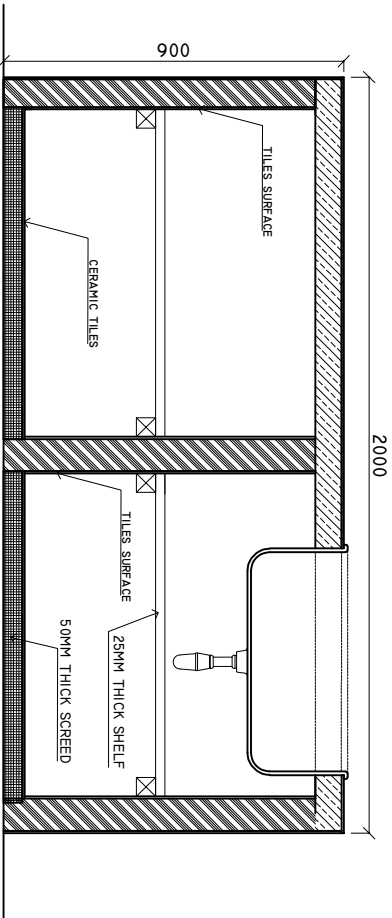

## SINK CUPBOARD DETAIL A-A

SCALE: 1 : 20

SHEET CONTENTS :

REVISION NOTES:

PROJECT:  
HEALTH CENTER  
EXTENSION BUILDING  
TYPE - B

CLIENT:  
MINISTRY OF HEALTH

LOCATION:  
DIFFERENT ISLAND

CONTENTS: AS GIVEN

PROJECT MANAGER:

DESIGNER: ARIZ

CIV/STR. ENGINEER:

SURVEYED BY: -

DRAWN BY: ARIZ

CHECKED BY:

DATE : APRIL 2025

SHEET NO. : 00/00


PAPER SIZE: A3



Infrastructure Development Unit  
Ministry of Health  
Rostume Building  
Sosun Magoi  
Tel: 332 8887, Fax: 3328889  
Email: projects@health.gov.mv

## SINK CUPBOARD.


**SCALE: 1 : 20**

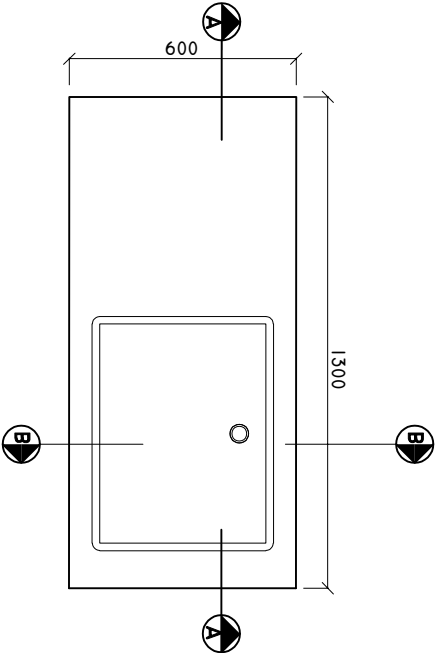

**NOTE: PLEASE CHECK ALL MESUREMENTS ON SITE BEFORE CARRYING OUT WORK**


## SINK CUPBOARD SECTION A-A

**SCALE: 1 : 20**

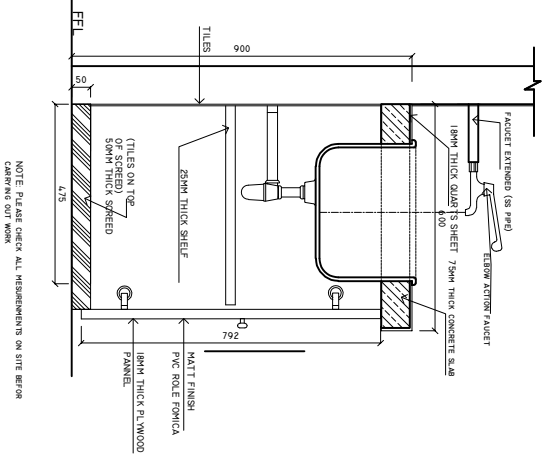

## SINK CUPBOARD


**SCALE: 1 : 20**

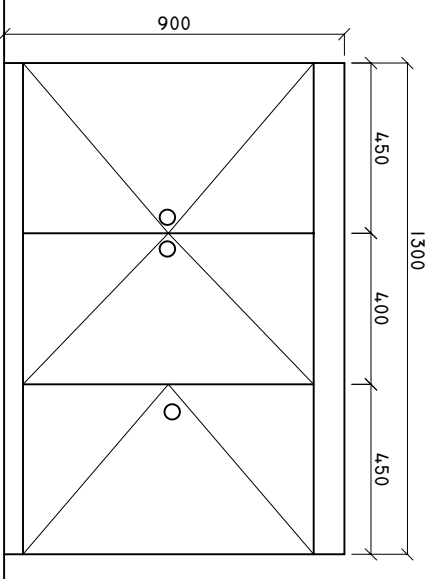

**NOTE: PLEASE CHECK ALL MESUREMENTS ON SITE BEFOR CARRYING OUT WORK**

## SINK CUPBOARD ELEVATION

**SCALE: 1 : 20**

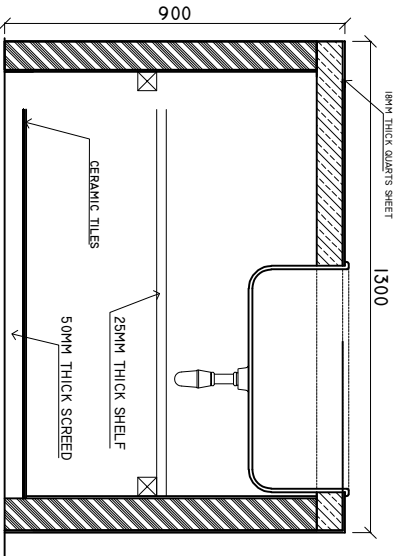

## SINK CUPBOARD DETAIL A-A

**SCALE: 1 : 20**


SHEET CONTENTS :	
REVISION NOTES:	
PROJECT:	
HEALTH CENTER	
EXTENSION BUILDING	
TYPE - B	
CLIENT:	
MINISTRY OF HEALTH	
LOCATION:	
DIFFERENT ISLAND	
CONTENTS: AS GIVEN	
PROJECT MANAGER:	
DESIGNER: ARIZ	
CIV/STR. ENGINEER:	
SURVEYED BY: -	
DRAWN BY: ARIZ	
CHECKED BY:	
DATE : APRIL 2023	
SHEET NO. : 00/100	
PAPER SIZE: A3	



Infrastructure Development Unit  
Ministry of Health  
Roshanee Building  
Sosun Magdi  
Tel: 332 8887, Fax: 3328889  
Email: [projects@health.gov.mv](mailto:projects@health.gov.mv)

LAB SINK CUPBOARD PLAN


SCALE: 1 : 20

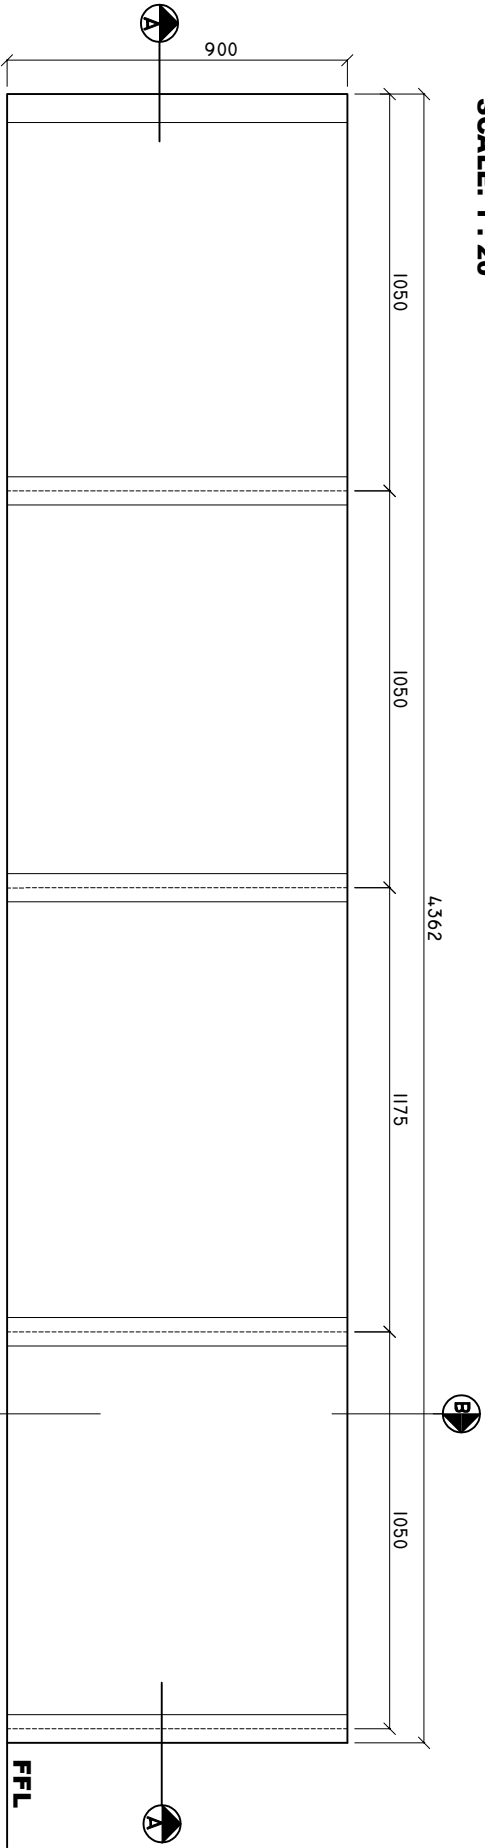

NOTE: PLEASE CHECK ALL MEASUREMENTS ON SITE BEFORE CARRYING OUT WORK

LAB SINK CUPBOARD SECTION A-A


SCALE: 1 : 20

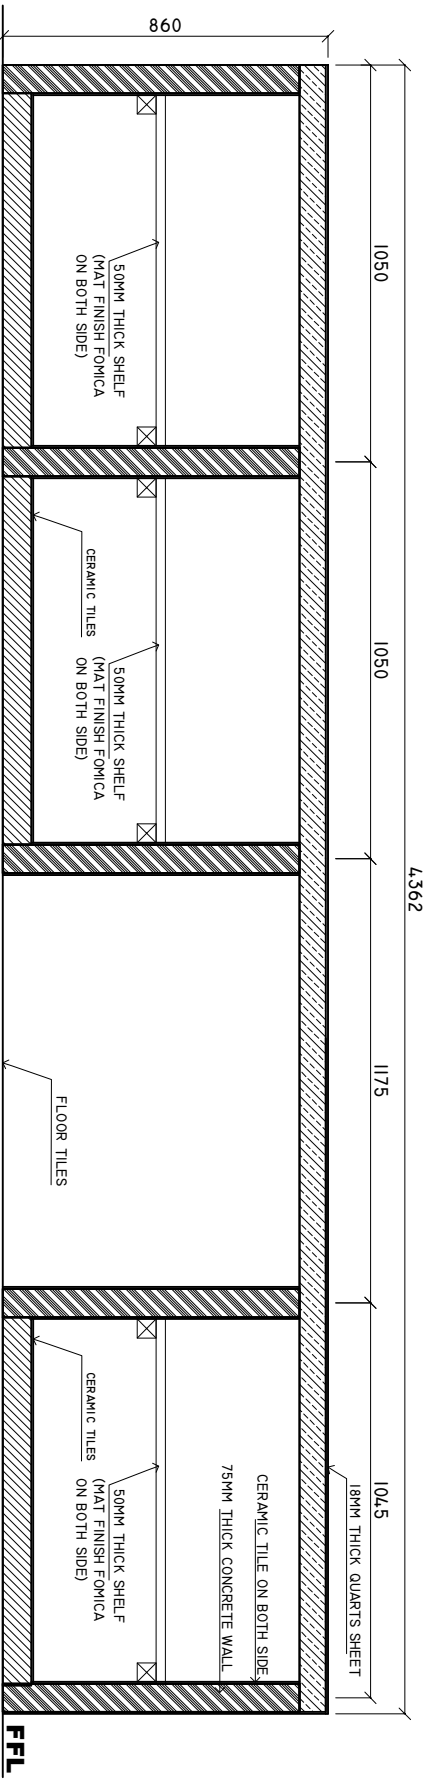

NOTE: PLEASE CHECK ALL MEASUREMENTS ON SITE BEFORE CARRYING OUT WORK

LAB SINK CUPBOARD  
FRONT ELEVATION

SCALE: 1 : 20

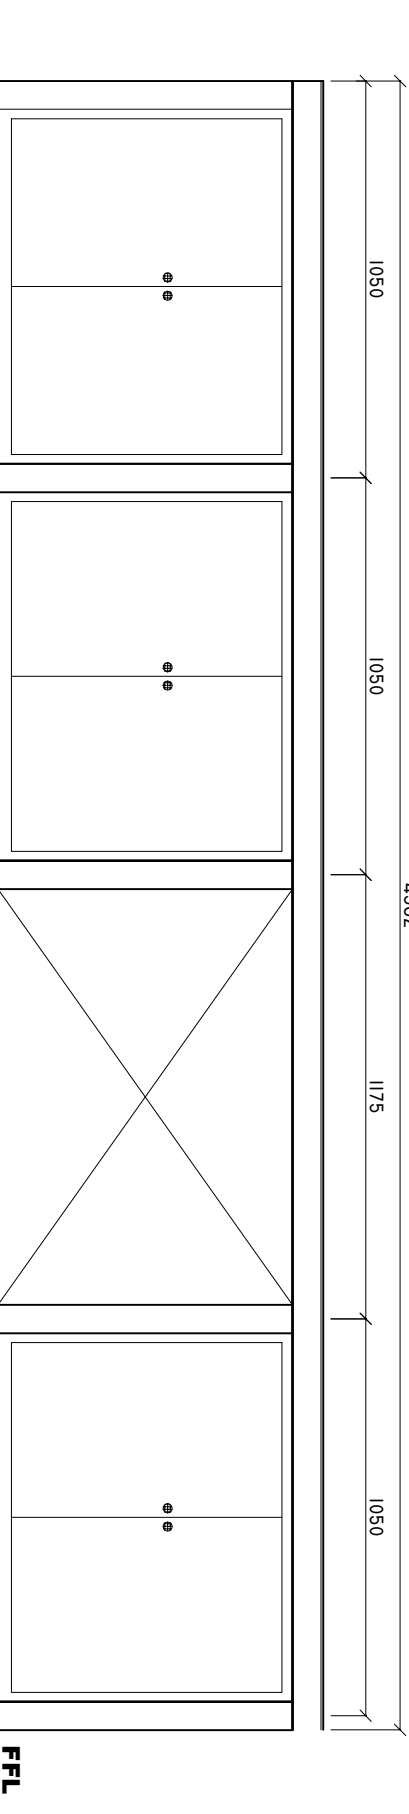

NOTE: PLEASE CHECK ALL MEASUREMENTS ON SITE BEFORE CARRYING OUT WORK

SHEET CONTENTS :

REVISION NOTES:

PROJECT:

HEALTH CENTER  
EXTENSION BUILDING  
TYPE - B

CLIENT:

MINISTRY OF HEALTH

LOCATION:

DIFFERENT ISLAND

CONTENTS: AS GIVEN

PROJECT MANAGER:

DESIGNER: ARIZ

CIV/STR. ENGINEER:

SURVEYED BY: -

DRAWN BY: ARIZ

CHECKED BY:

DATE : APRIL 2025

SHEET NO. : 00/00


PAPER SIZE: A3



Infrastructure Development Unit  
Ministry of Health  
Roshumei Building  
Sosun Magoi  
Tel: 332 8887, Fax: 3328889  
Email: projects@health.gov.mv

LAB SINK CUPBOARD PLAN


SCALE: 1 : 20

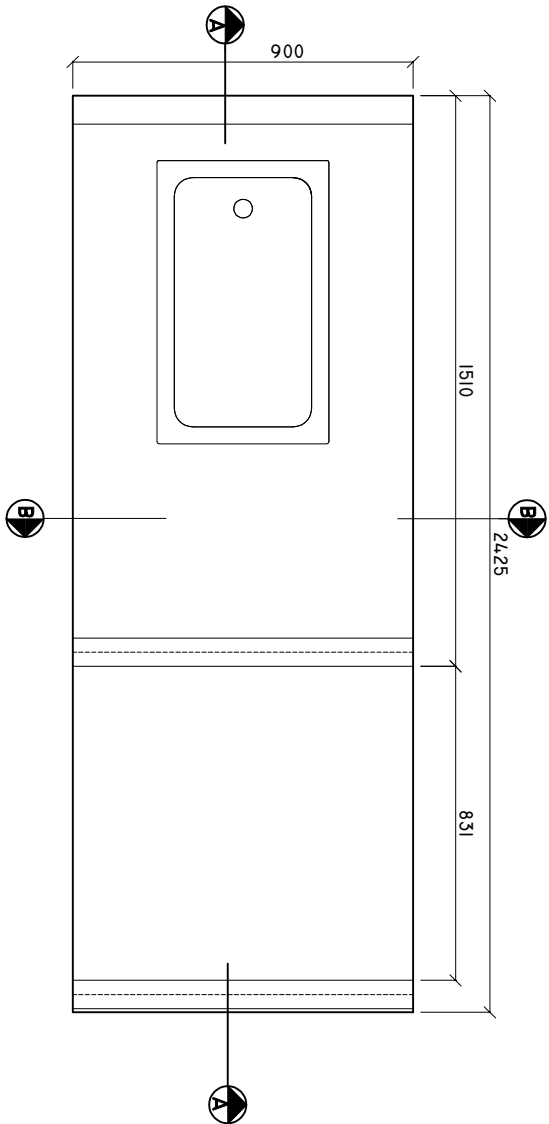

NOTE: PLEASE CHECK ALL MEASUREMENTS ON SITE BEFORE CARRYING OUT WORK

LAB SINK CUPBOARD SECTION A-A


SCALE: 1 : 20

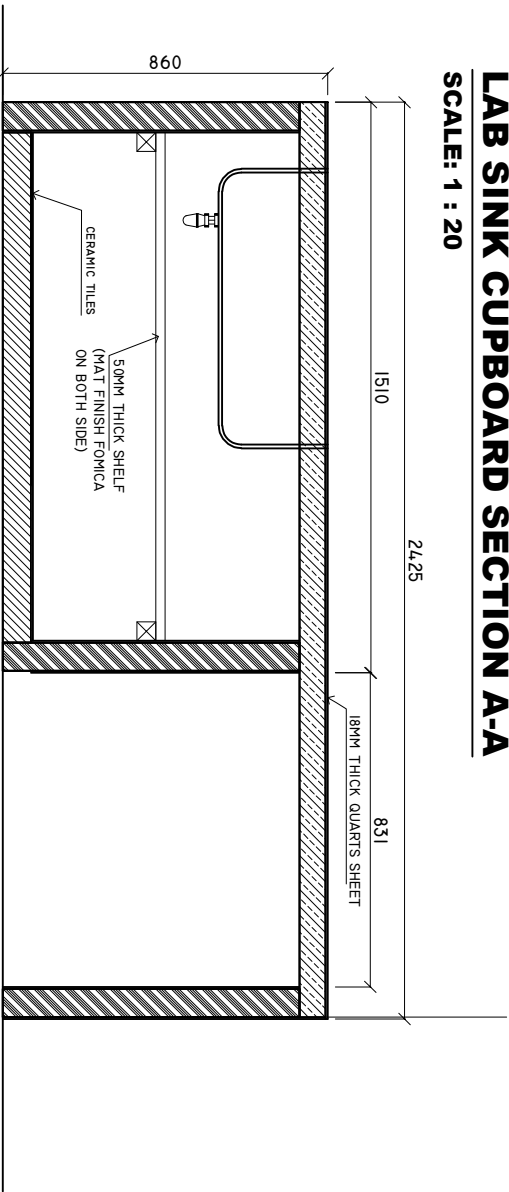

NOTE: PLEASE CHECK ALL MEASUREMENTS ON SITE BEFORE CARRYING OUT WORK

LAB SINK CUPBOARD  
FRONT ELEVATION

 SCALE: 1 : 20



SHEET CONTENTS :

REVISION NOTES:

PROJECT:  
HEALTH CENTER  
EXTENSION BUILDING  
TYPE - B

CLIENT:  
MINISTRY OF HEALTH

LOCATION:  
DIFFERENT ISLAND

CONTENTS: AS GIVEN

PROJECT MANAGER:

DESIGNER: ARIZ

CIV/STR. ENGINEER:

SURVEYED BY: -

DRAWN BY: ARIZ

CHECKED BY:

DATE : APRIL 2025

SHEET NO. : 00/00


PAPER SIZE: A3



Infrastructure Development Unit  
Ministry of Health  
Roshanee Building  
Sosun Magoi  
Tel: 332 8887, Fax: 3328889  
Email: projects@health.gov.mv




LAB SINK CUPBOARD  
DETAIL B-B  
SCALE: 1 : 10

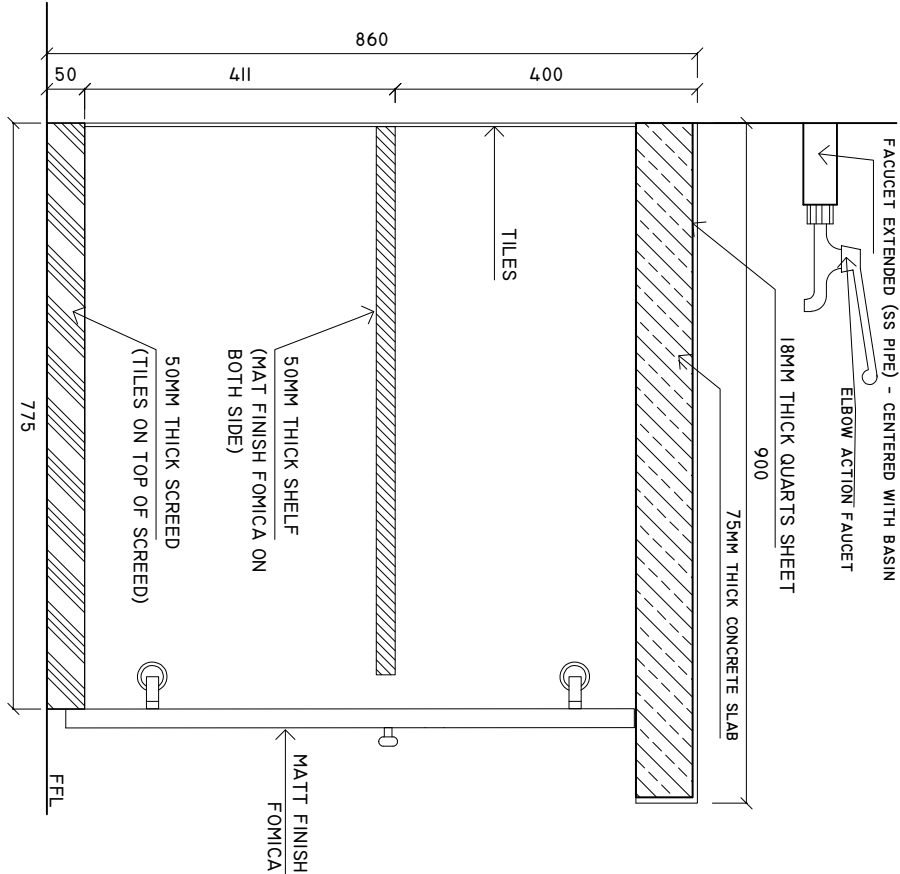

NOTE: PLEASE CHECK ALL MESUREMENTS ON SITE BEFOR  
CARRYING OUT WORK

LAB SINK CUPBOARD  
DETAIL B-B  
SCALE: 1 : 10

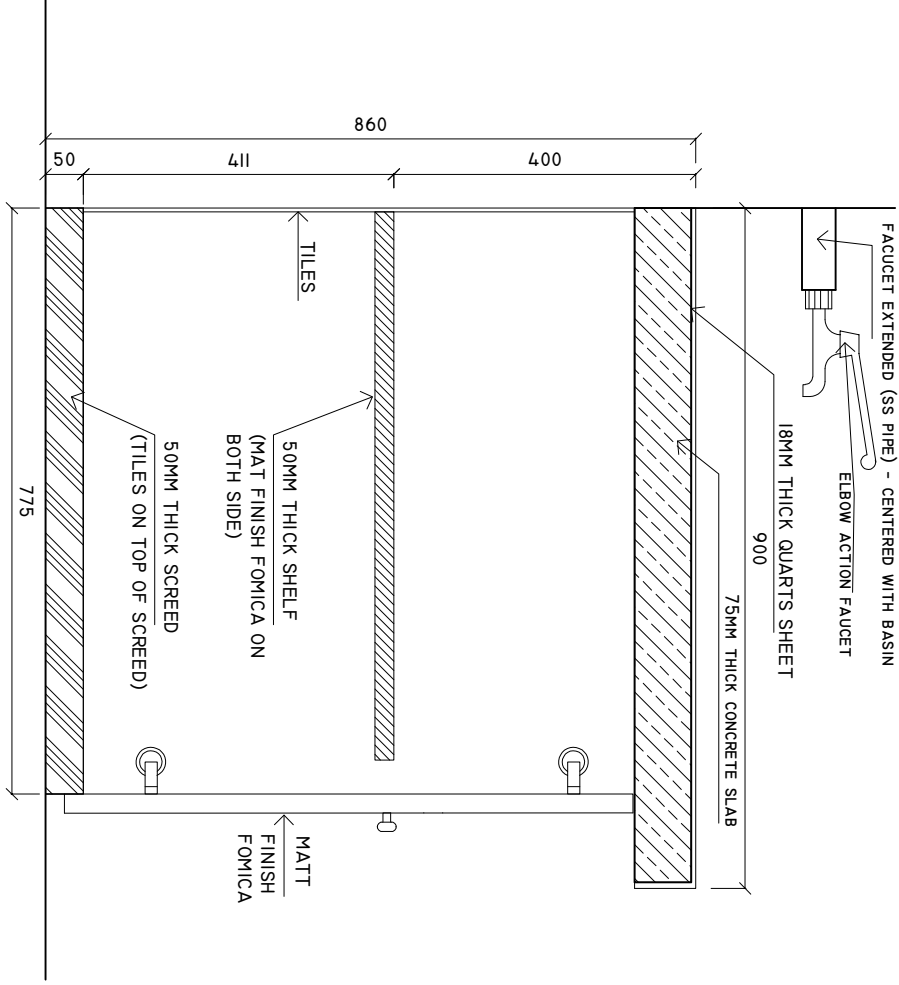

NOTE: PLEASE CHECK ALL MESUREMENTS ON SITE BEFOR  
CARRYING OUT WORK

SHEET CONTENTS :

REVISION NOTES:

PROJECT:

HEALTH CENTER  
EXTENSION BUILDING  
TYPE - B

CLIENT:

MINISTRY OF HEALTH

LOCATION:

DIFFERENT ISLAND

CONTENTS: AS GIVEN

PROJECT MANAGER:

DESIGNER: ARIZ

CIV/STR. ENGINEER:

SURVEYED BY: -

DRAWN BY: ARIZ

CHECKED BY:

DATE : APRIL 2025

SHEET NO. : 00/00


PAPER SIZE: A3



Infrastructure Development Unit  
Ministry of Health  
Rostume Building  
Sosun Maqul  
Tel: 332 8887, Fax: 3328889  
Email: projects@health.gov.mv

ELECTRICAL LAYOUT

SCALE: 1 : 100

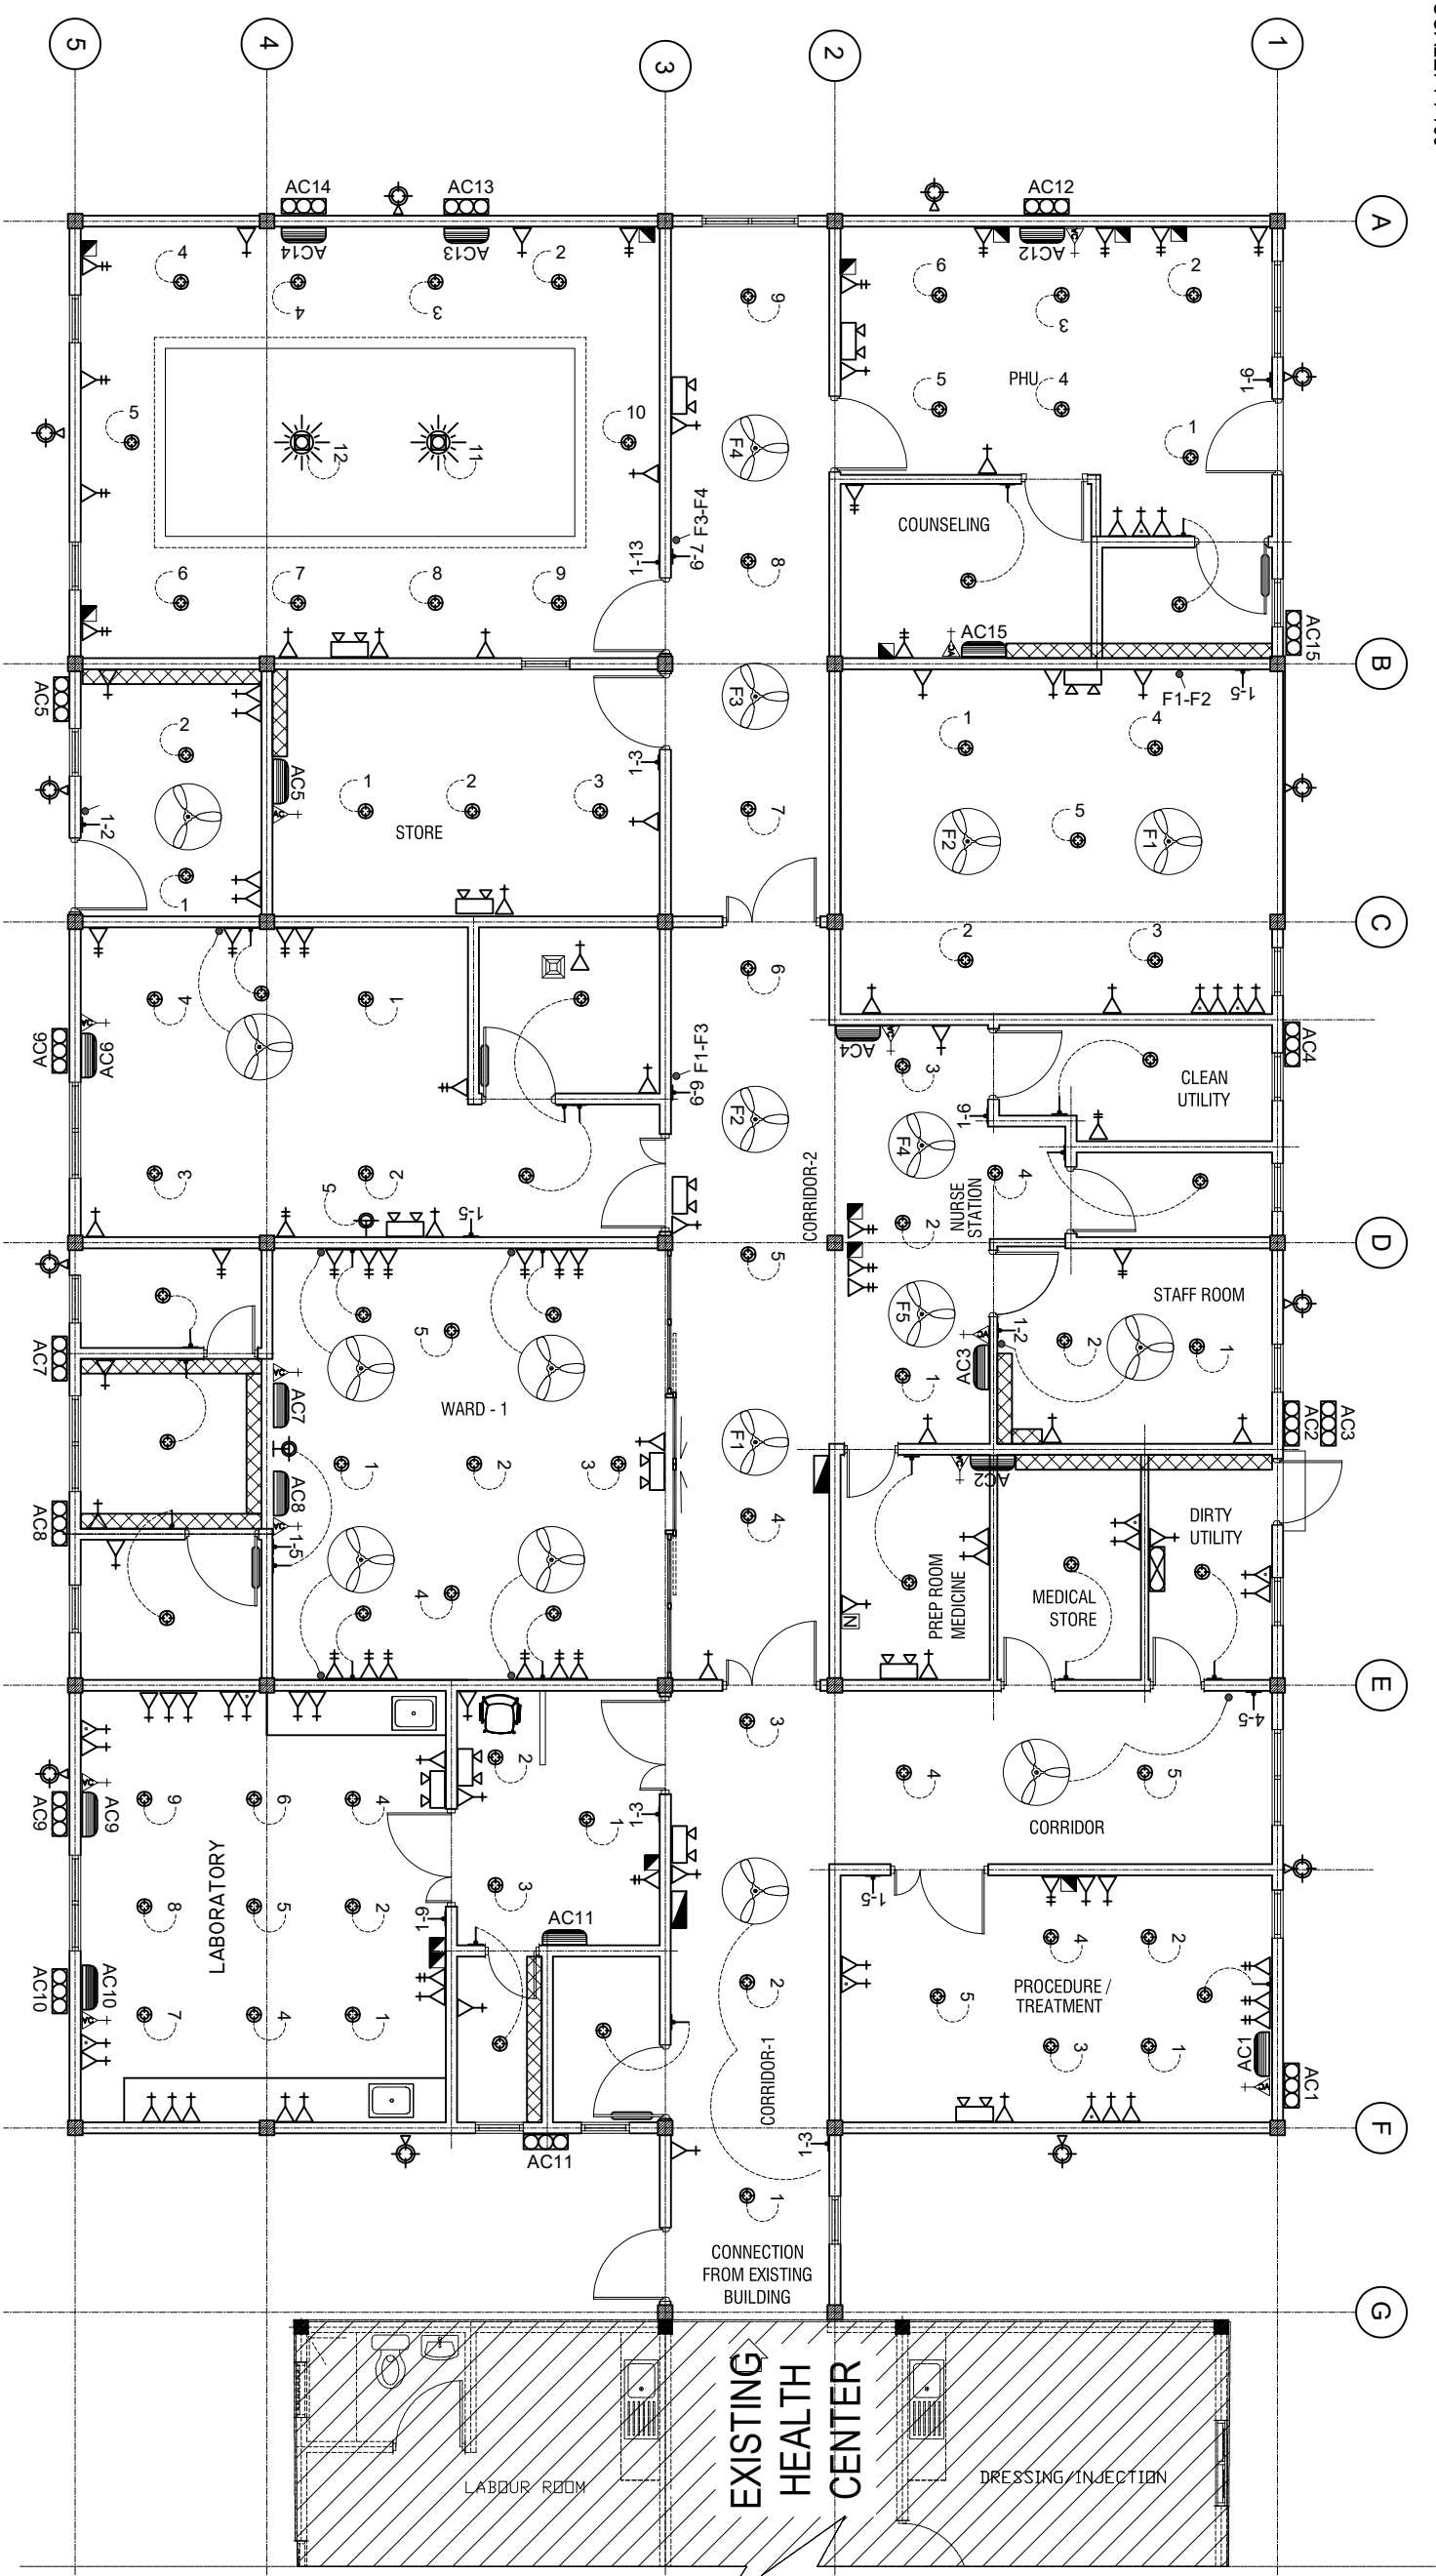

LEGEND

SYMBOL	DESCRIPTION
	LED BULB WITH 150MM DOWN LIGHT
	1 x 13 AMP SOCKET OUTLET (1200MM ABOVE FFL)
	1 x 13 AMP SOCKET OUTLET (300MM ABOVE FFL)
	1 x 15 AMP SOCKET OUTLET (300MM ABOVE FFL)
	1 x 15 AMP AC SOCKET OUTLET (50MM BLW. CEILING)
	ONE WAY SWITCH
	EMERGENCY LIGHT
	DISTRIBUTION BOARD ( WALL EMBEDDED )
	WALL MOUNT FAN
	NETWORK SOCKET (300MM ABOVE FFL)
	1 x 13 AMP SOCKET OUTLET (200MM BELOW CEILING)
	FAN REGULATOR

LEGEND

SYMBOL	DESCRIPTION
	5W DIMABLE LIGHT WITH COVERED
	OUTDOOR LIGHT
	NETWORK SWITCH
	PABX
	AC WALL MOUNT UNIT
	AC INDOOR UNIT, CEILING CASSETTE TYPE
	300X300MM HEAVY DUTY EXHAUST
	DUCT FOR AC PIPE LINES, 300-500X200MM
	CHANDELIER WITH EIGHT BULB.

NOTE: EACH LIGHT MUST BE CONTROLLED BY A SINGLE SWITCH.  
PANTRY AND LAB AREA SOCKET HEIGHT IS ONE METER FROM FFL.

SHEET CONTENTS :

REVISION NOTES:

PROJECT:  
HEALTH CENTER  
EXTENSION BUILDING  
TYPE - B

CLIENT:  
MINISTRY OF HEALTH

LOCATION:  
DIFFERENT ISLAND

CONTENTS: AS GIVEN

PROJECT MANAGER:

DESIGNER: ARIZ

CIV/STR. ENGINEER:

SURVEYED BY: -

DRAWN BY: ARIZ

CHECKED BY:

DATE : APRIL 2025

SHEET NO. : 00/00

PAPER SIZE: A3




Infrastructure Development Unit  
Ministry of Health  
Residence Building  
Sasun Nagar  
Tel: 332 8887, Fax: 3328889  
Email: projects@health.gov.mv

# DH. BANDIDHOO HEALTH CENTER

## PORTICO AND PAVING AREA.

SCALE: 1 : 100

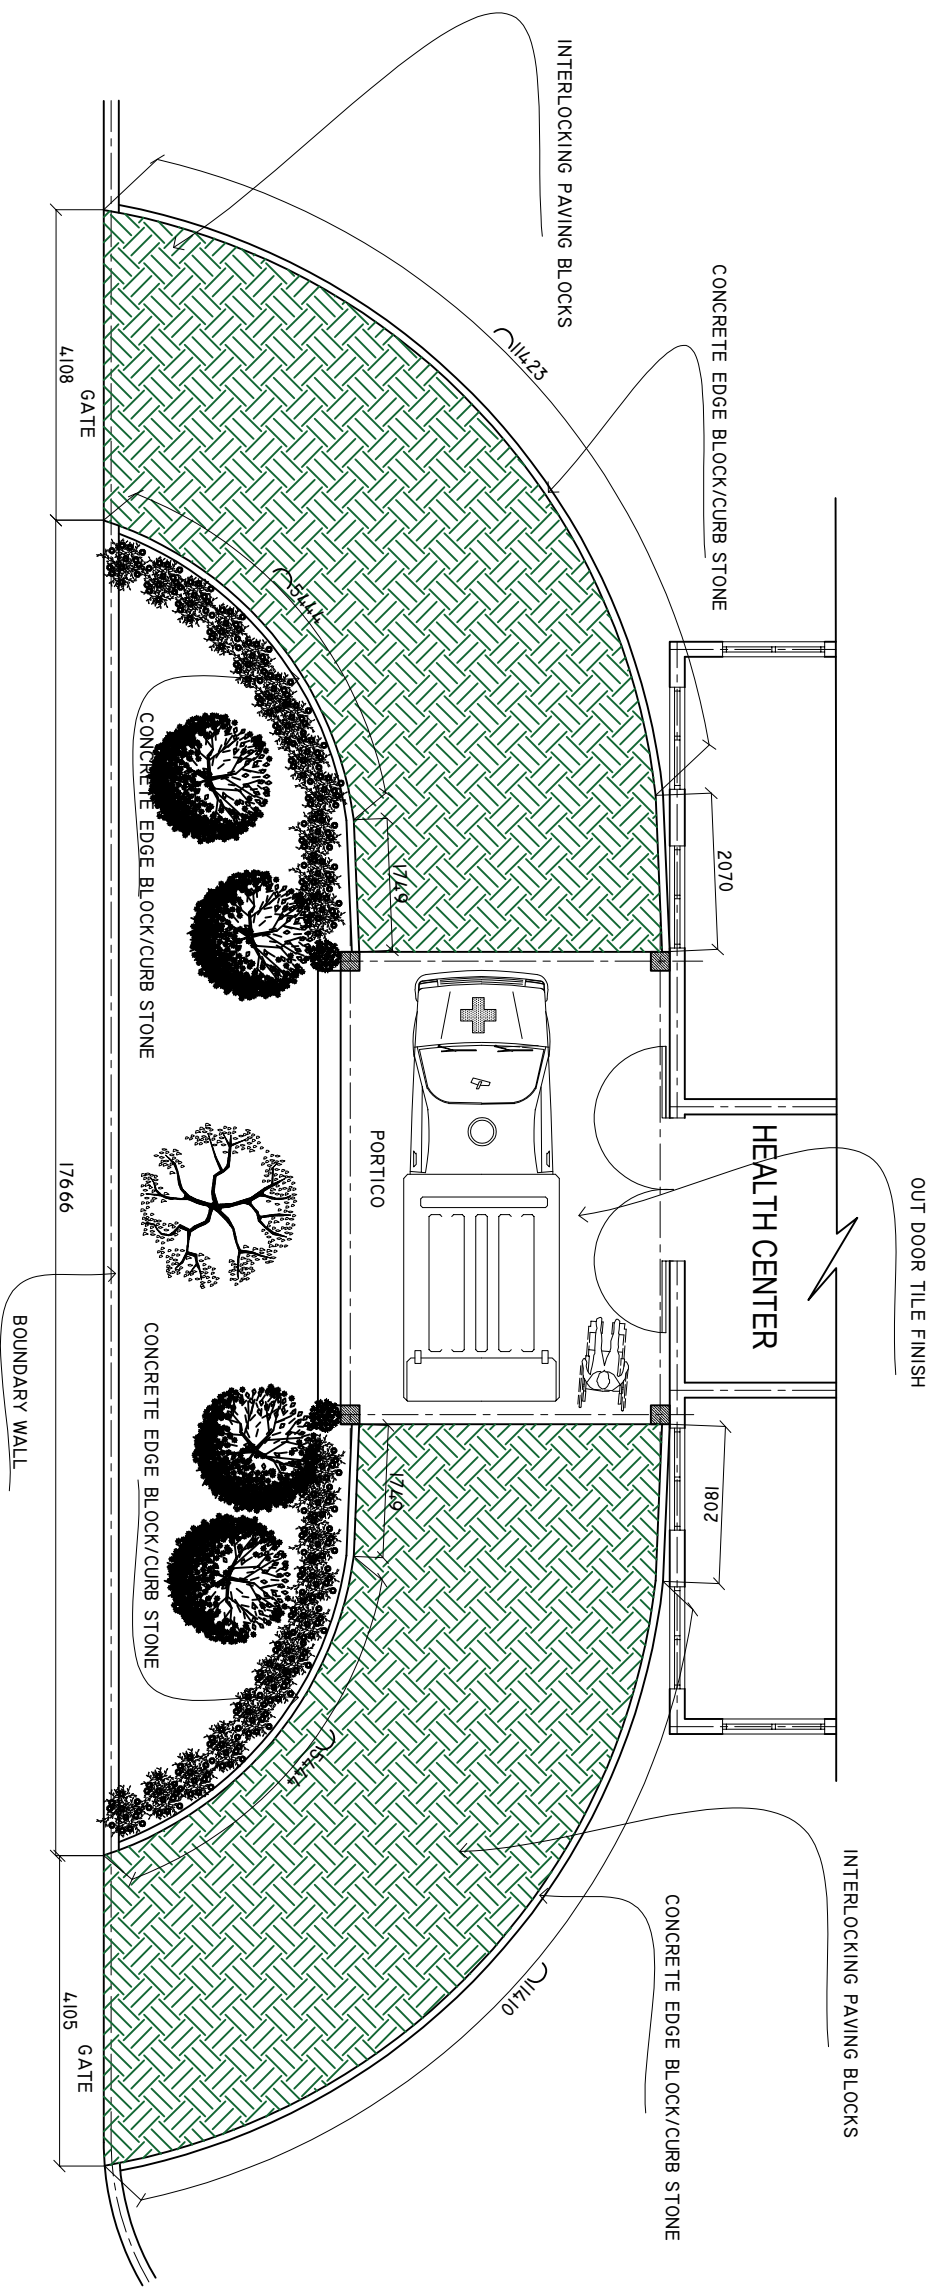

SHEET CONTENTS :

REVISION NOTES:

PROJECT:

CONSTRUCTION OF  
AMBULANCE PORTICO

CLIENT:

MINISTRY OF HEALTH

LOCATION:

DIFFERENT ISLANDS

CONTENTS: AS GIVEN

PROJECT MANAGER:

DESIGNER: ARIZ

CIV/STR. ENGINEER:

SURVEYED BY: -

DRAWN BY: ARIZ

CHECKED BY:

DATE : FEBRUARY 2021

SHEET NO. : /

PAPER SIZE: A3

